


ARC FLASH VALUES ARE PRELIMINARY AND WILL BE FINALIZED DURING CONSTRUCTION.

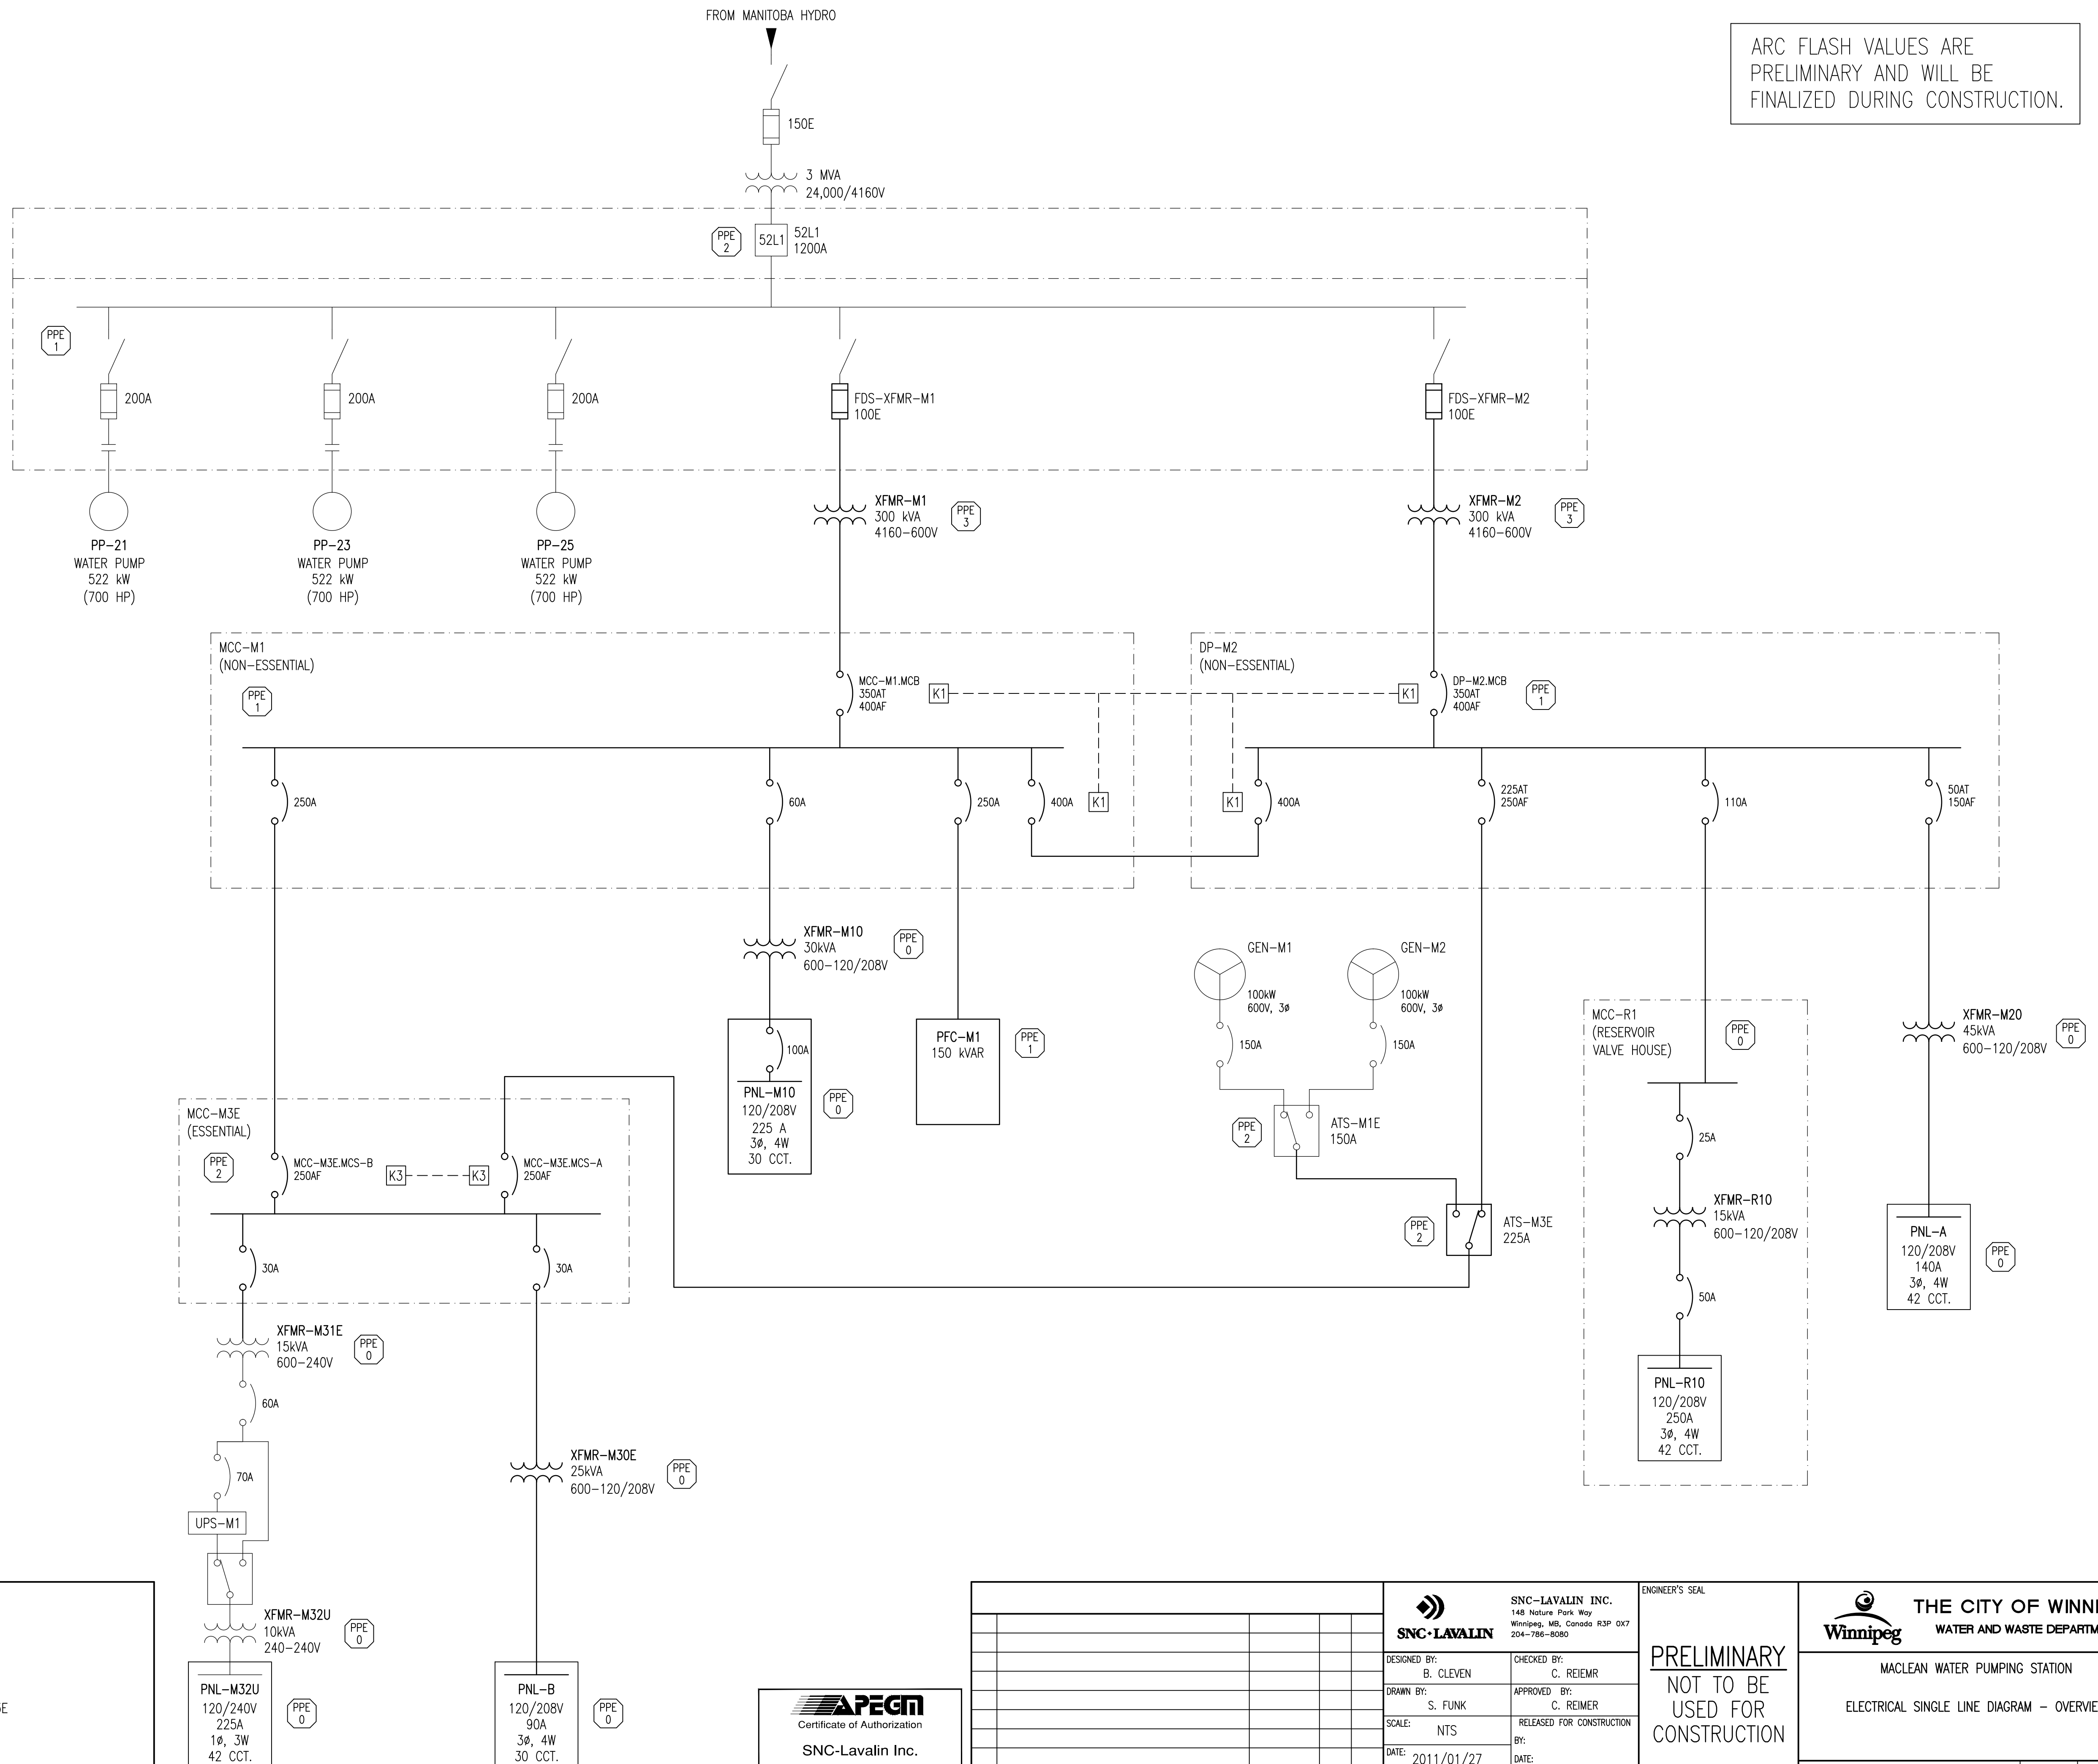

LAST SAVE: 2012/07/26 - 3:53pm
 PATH: M:\508955\GEN\47ELE\DD - General DWG\1-0630M-E002-001-00.dwg

1-0630M-E0025	ELECTRICAL SINGLE LINE DIAGRAM - MCC-M3E
1-0630M-E0024	ELECTRICAL SINGLE LINE DIAGRAM - DP-M2
1-0630M-E0023	ELECTRICAL SINGLE LINE DIAGRAM - MCC-M1
1-0630M-E0001	ELECTRICAL SINGLE LINE DIAGRAM LEGEND AND DETAILS
DRAWING NUMBER	REFERENCE DRAWINGS



00	ISSUED FOR TENDER, BID OPP: 490-2012	2012/07/23	BJC	CJR
NO.	REVISIONS	DATE	DESIGN	CHECK

SNC-LAVALIN INC. 148 Nature Park Way Winnipeg, MB, Canada R3P 0X7 204-786-8080	
DESIGNED BY: B. CLEVEN	CHECKED BY: C. REIEMR
DRAWN BY: S. FUNK	APPROVED BY: C. REIMER
SCALE: NTS	RELEASED FOR CONSTRUCTION BY: DATE: 2011/01/27
CONSULTANT NO.: 508955-0000-47DD-0022	

ENGINEER'S SEAL
PRELIMINARY
 NOT TO BE
 USED FOR
 CONSTRUCTION

THE CITY OF WINNIPEG WATER AND WASTE DEPARTMENT			
MACLEAN WATER PUMPING STATION			
ELECTRICAL SINGLE LINE DIAGRAM - OVERVIEW			
CITY DRAWING NUMBER	SHEET	REV.	SIZE
1-0630M-E0022	001	00	A1