


LEGEND:

- EXISTING
- NEW WORK
- - - FUTURE

ARC FLASH VALUES ARE PRELIMINARY AND WILL BE FINALIZED DURING CONSTRUCTION.

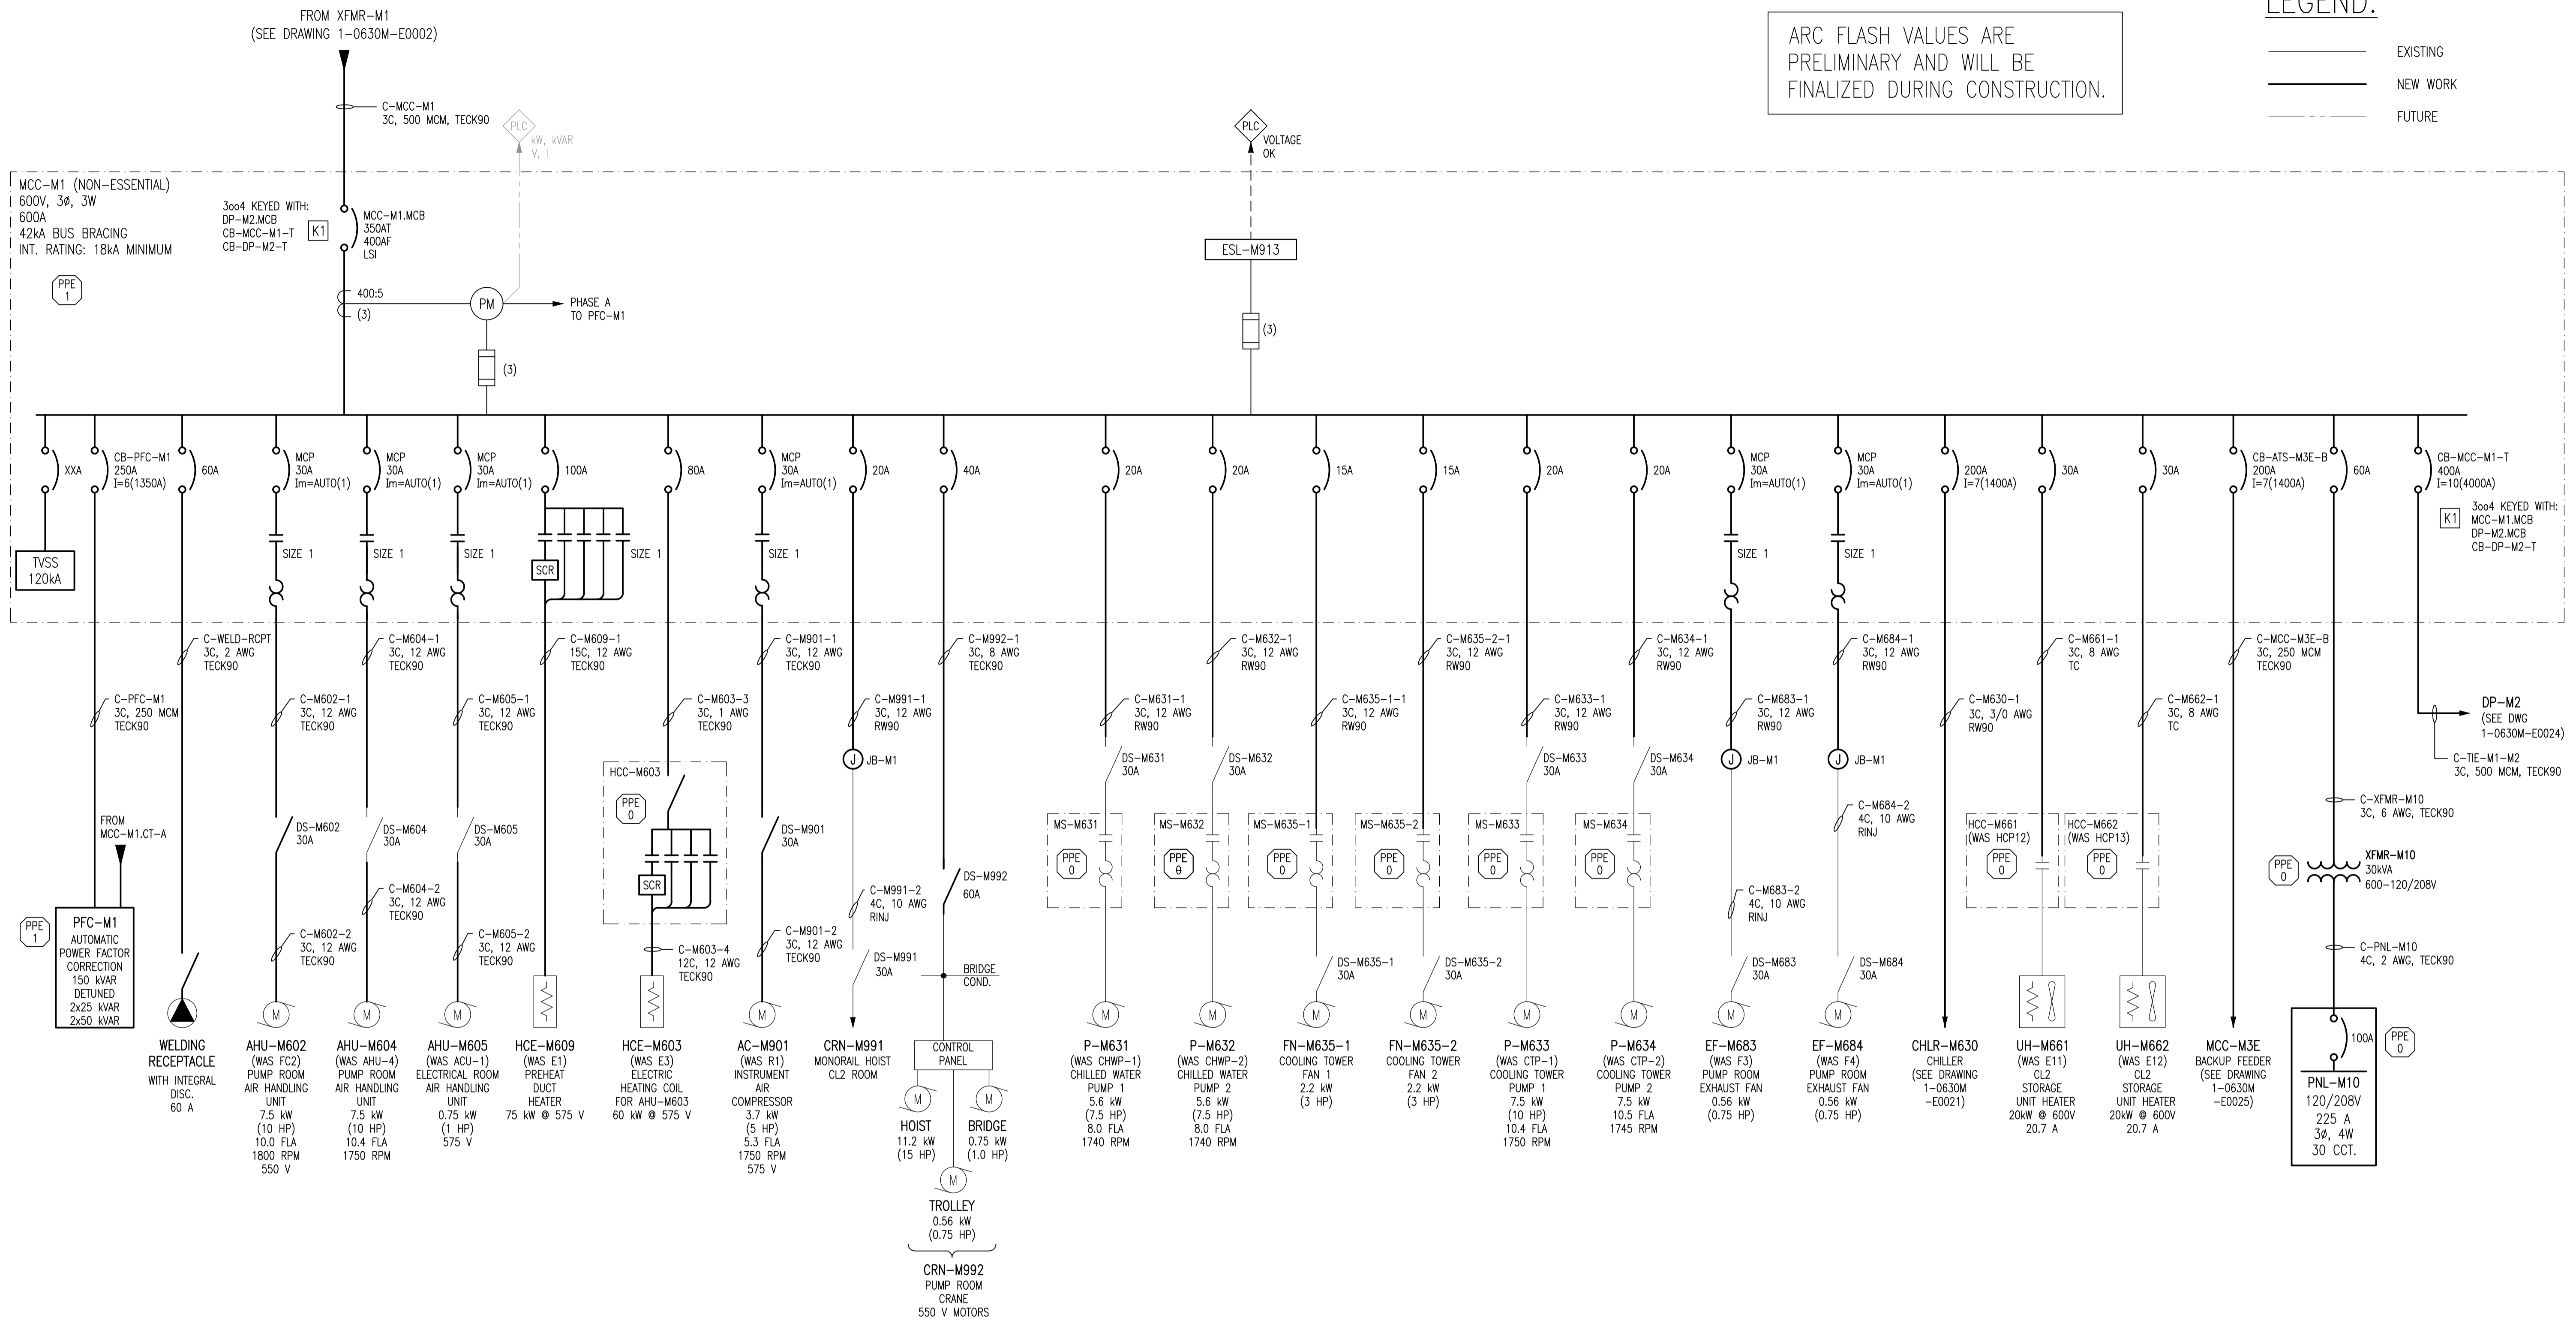

LAST SAVE: 2012/07/26 - 3:53pm
PATH: M:\508955\AENG\47ELE\DD - General DWG\1-0630M-E0023-001-00.dwg

1-0630M-E0028	MCC SCHEDULES
1-0630M-E0026	MCC ELEVATION AND DETAILS
1-0630M-E0004	SINGLE LINE DIAGRAM, DP-M2
1-0630M-E0001	ELECTRICAL SINGLE LINE DIAGRAM LEGEND AND DETAILS
DRAWING NUMBER	REFERENCE DRAWINGS



00	ISSUED FOR TENDER, BID OPP: 490-2012	2012/07/23	BJC	CJR
NO.	REVISIONS	DATE	DESIGN	CHECK

<p>SNC-LAVALIN INC. 148 Nature Park Way Winnipeg, MB, Canada R3P 0X7 204-786-8080</p>	
DESIGNED BY: B. CLEVEN	CHECKED BY: C. REIMER
DRAWN BY: S. FUNK	APPROVED BY: C. REIMER
SCALE: NTS	RELEASED FOR CONSTRUCTION BY:
DATE: 2011/01/25	DATE:
CONSULTANT NO.: 508955-0000-47DD-0023	

ENGINEER'S SEAL

PRELIMINARY
NOT TO BE
USED FOR
CONSTRUCTION

THE CITY OF WINNIPEG
WATER AND WASTE DEPARTMENT

MACLEAN WATER PUMPING STATION

ELECTRICAL SINGLE LINE DIAGRAM
MCC-M1

CITY DRAWING NUMBER	SHEET	REV.	SIZE
1-0630M-E0023	001	00	A1

1-0630M-E0023-001-00.dwg