


LEGEND:


---	BURIED
---	EXISTING
---	NEW WORK

CONTINUED ON DRAWING 1-0630M-E0041-001

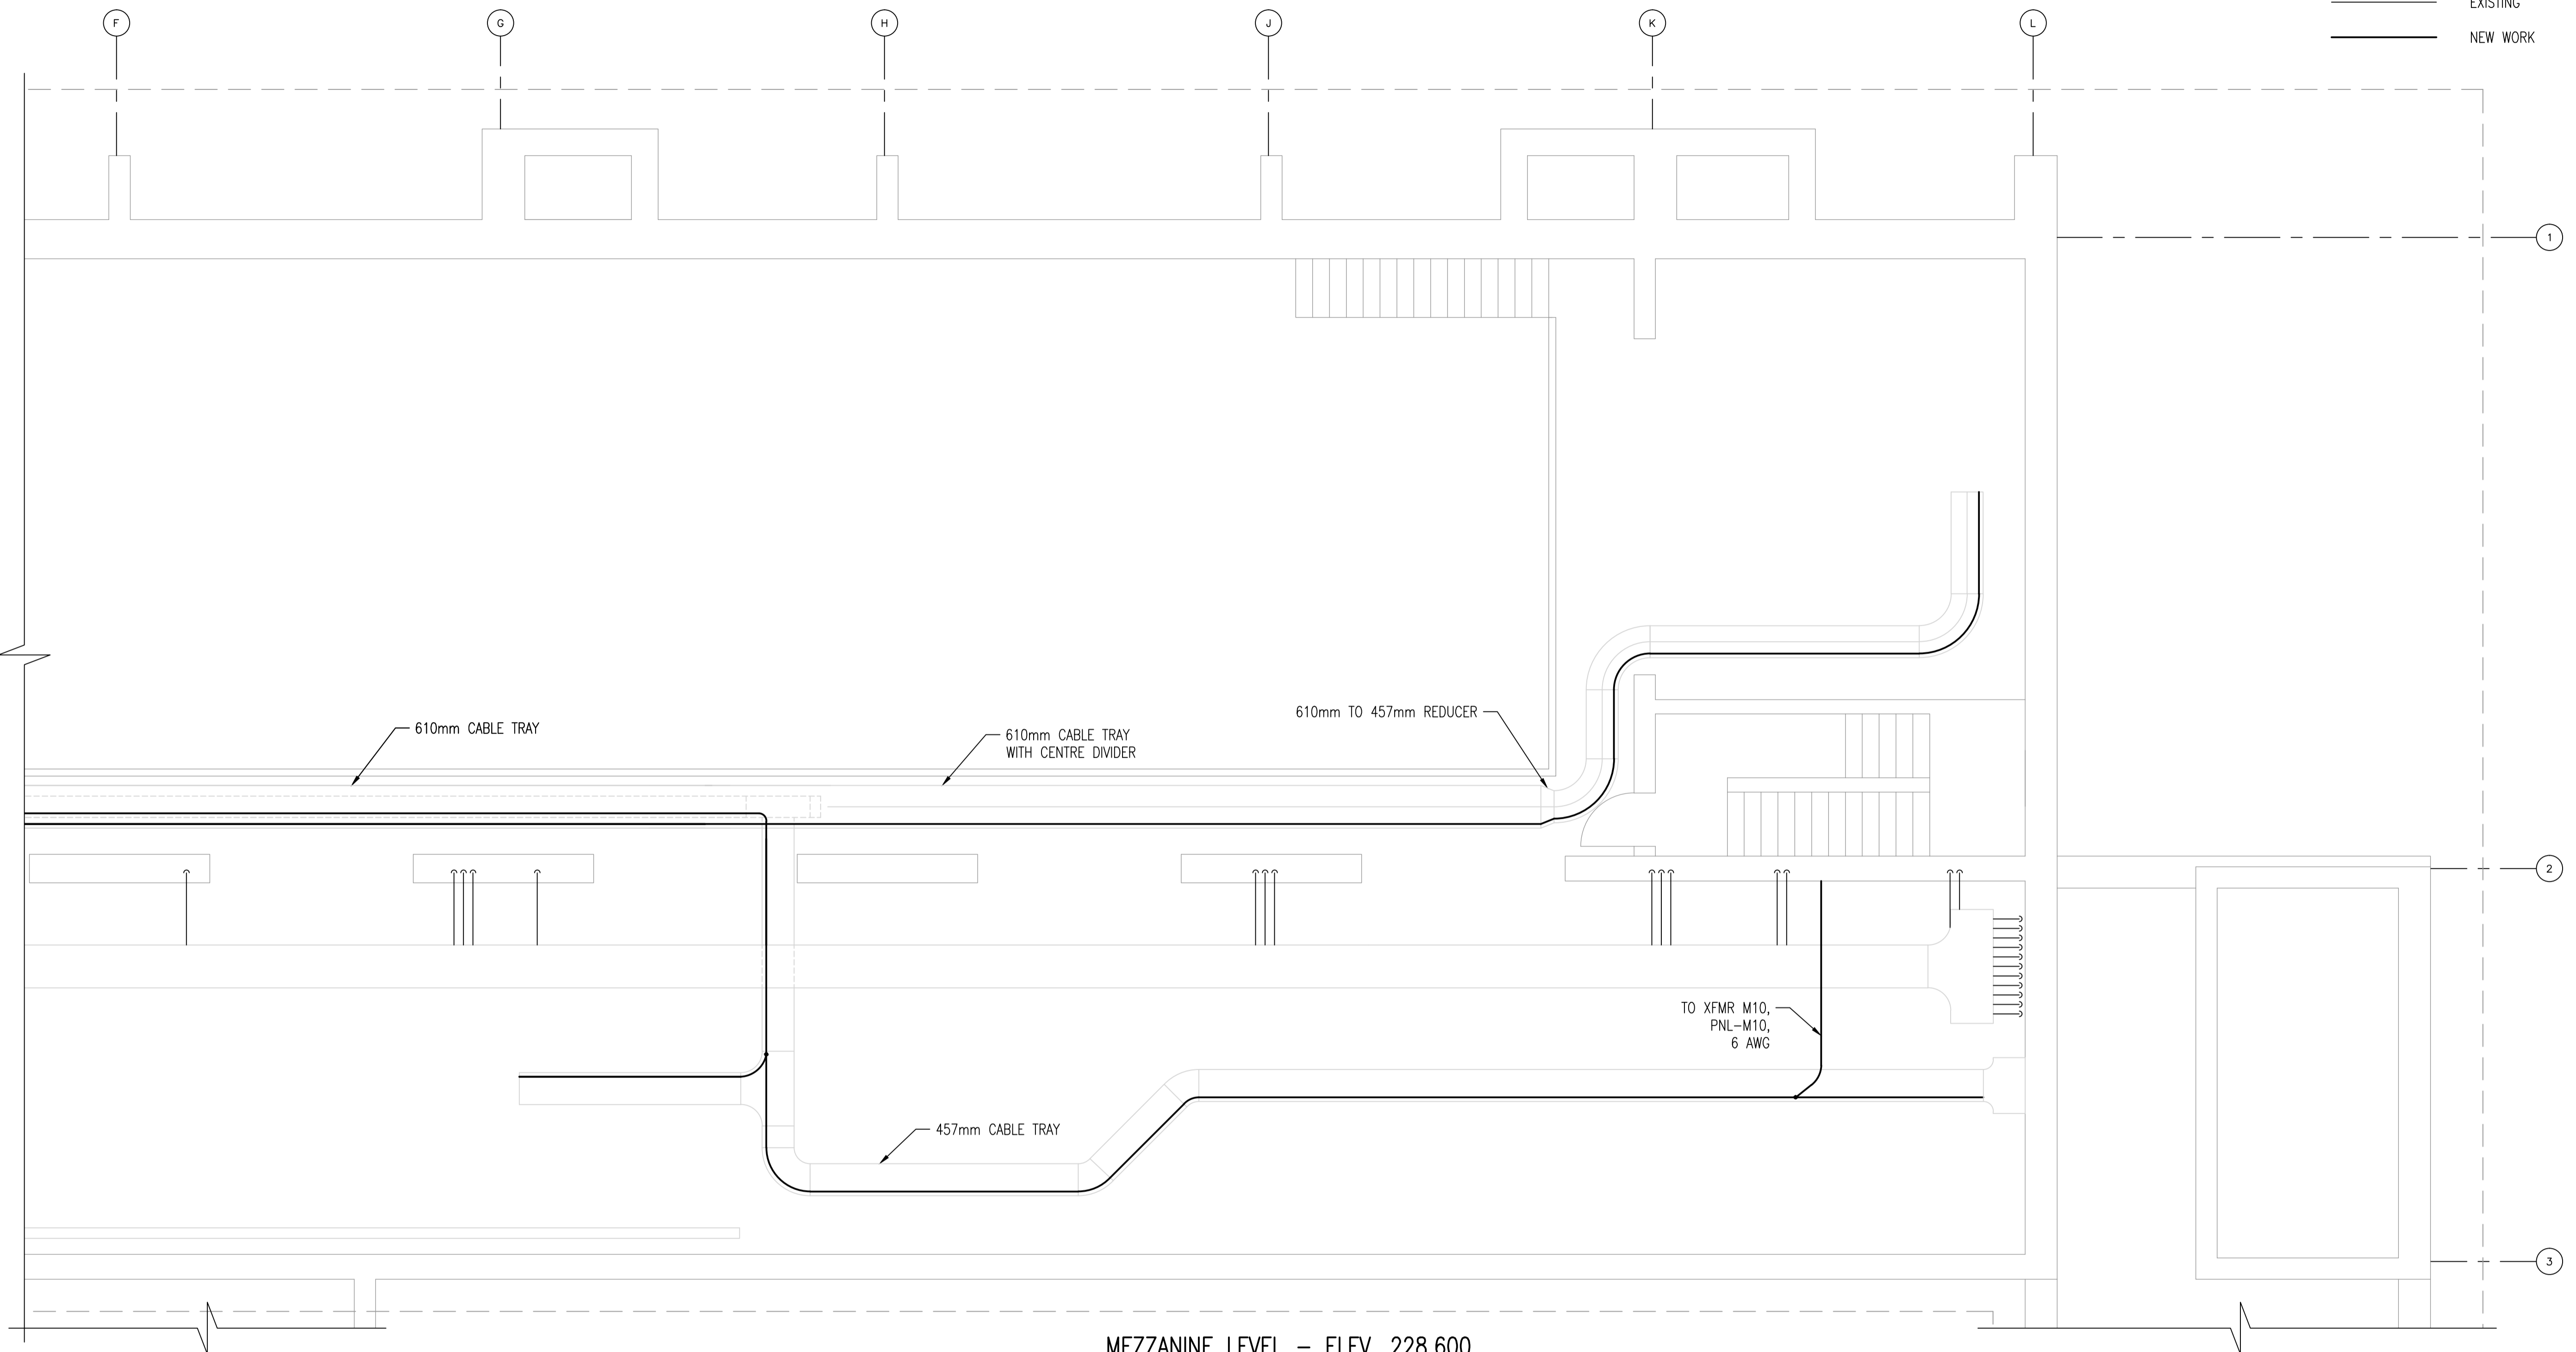

MEZZANINE LEVEL - ELEV. 228.600
SCALE: 1 : 50

 - NOTES:**
1. THIS DRAWING REPRESENTS THE MAJOR GROUNDING CONDUCTORS ONLY. BONDING CONDUCTORS ARE NOT NECESSARILY SHOWN.
 2. CONFIRM THAT THE EXISTING GROUND CONDUCTORS ARE IN GOOD CONDITION. INSPECT ALL MAJOR GROUNDING AND BONDING CONNECTIONS AND REPAIR AS REQUIRED.
 3. ALL CONDUCTORS ARE TO BE 2/0 AWG UNLESS OTHERWISE INDICATED.



NO.	REVISIONS	DATE	DESIGN	CHECK
00	ISSUED FOR TENDER, BID OPP: 490-2012	2012/07/23	BJC	CJR

SNC-LAVALIN INC. 148 Nature Park Way Winnipeg, MB, Canada R3P 0X7 204-786-8080	
DESIGNED BY: B. CLEVEN	CHECKED BY: C. REIMER
DRAWN BY: M.J. PERSSON	APPROVED BY: C. REIMER
SCALE: 1:50	RELEASED FOR CONSTRUCTION BY: DATE:
DATE: 2012/03/07	DATE:
CONSULTANT NO.: 508955-0000-47DD-0041	

ENGINEER'S SEAL

PRELIMINARY
NOT TO BE
USED FOR
CONSTRUCTION

THE CITY OF WINNIPEG
WATER AND WASTE DEPARTMENT

MACLEAN WATER PUMPING STATION

GROUNDING PLAN
MEZZANINE LEVEL

CITY DRAWING NUMBER	SHEET	REV.	SIZE
1-0630M-E0041	002	00	A1

1-0630M-E0067	GROUNDING INSTALLATION DETAILS
DRAWING NUMBER	REFERENCE DRAWINGS