


LEGEND:

- EXISTING
- NEW WORK
- FUTURE

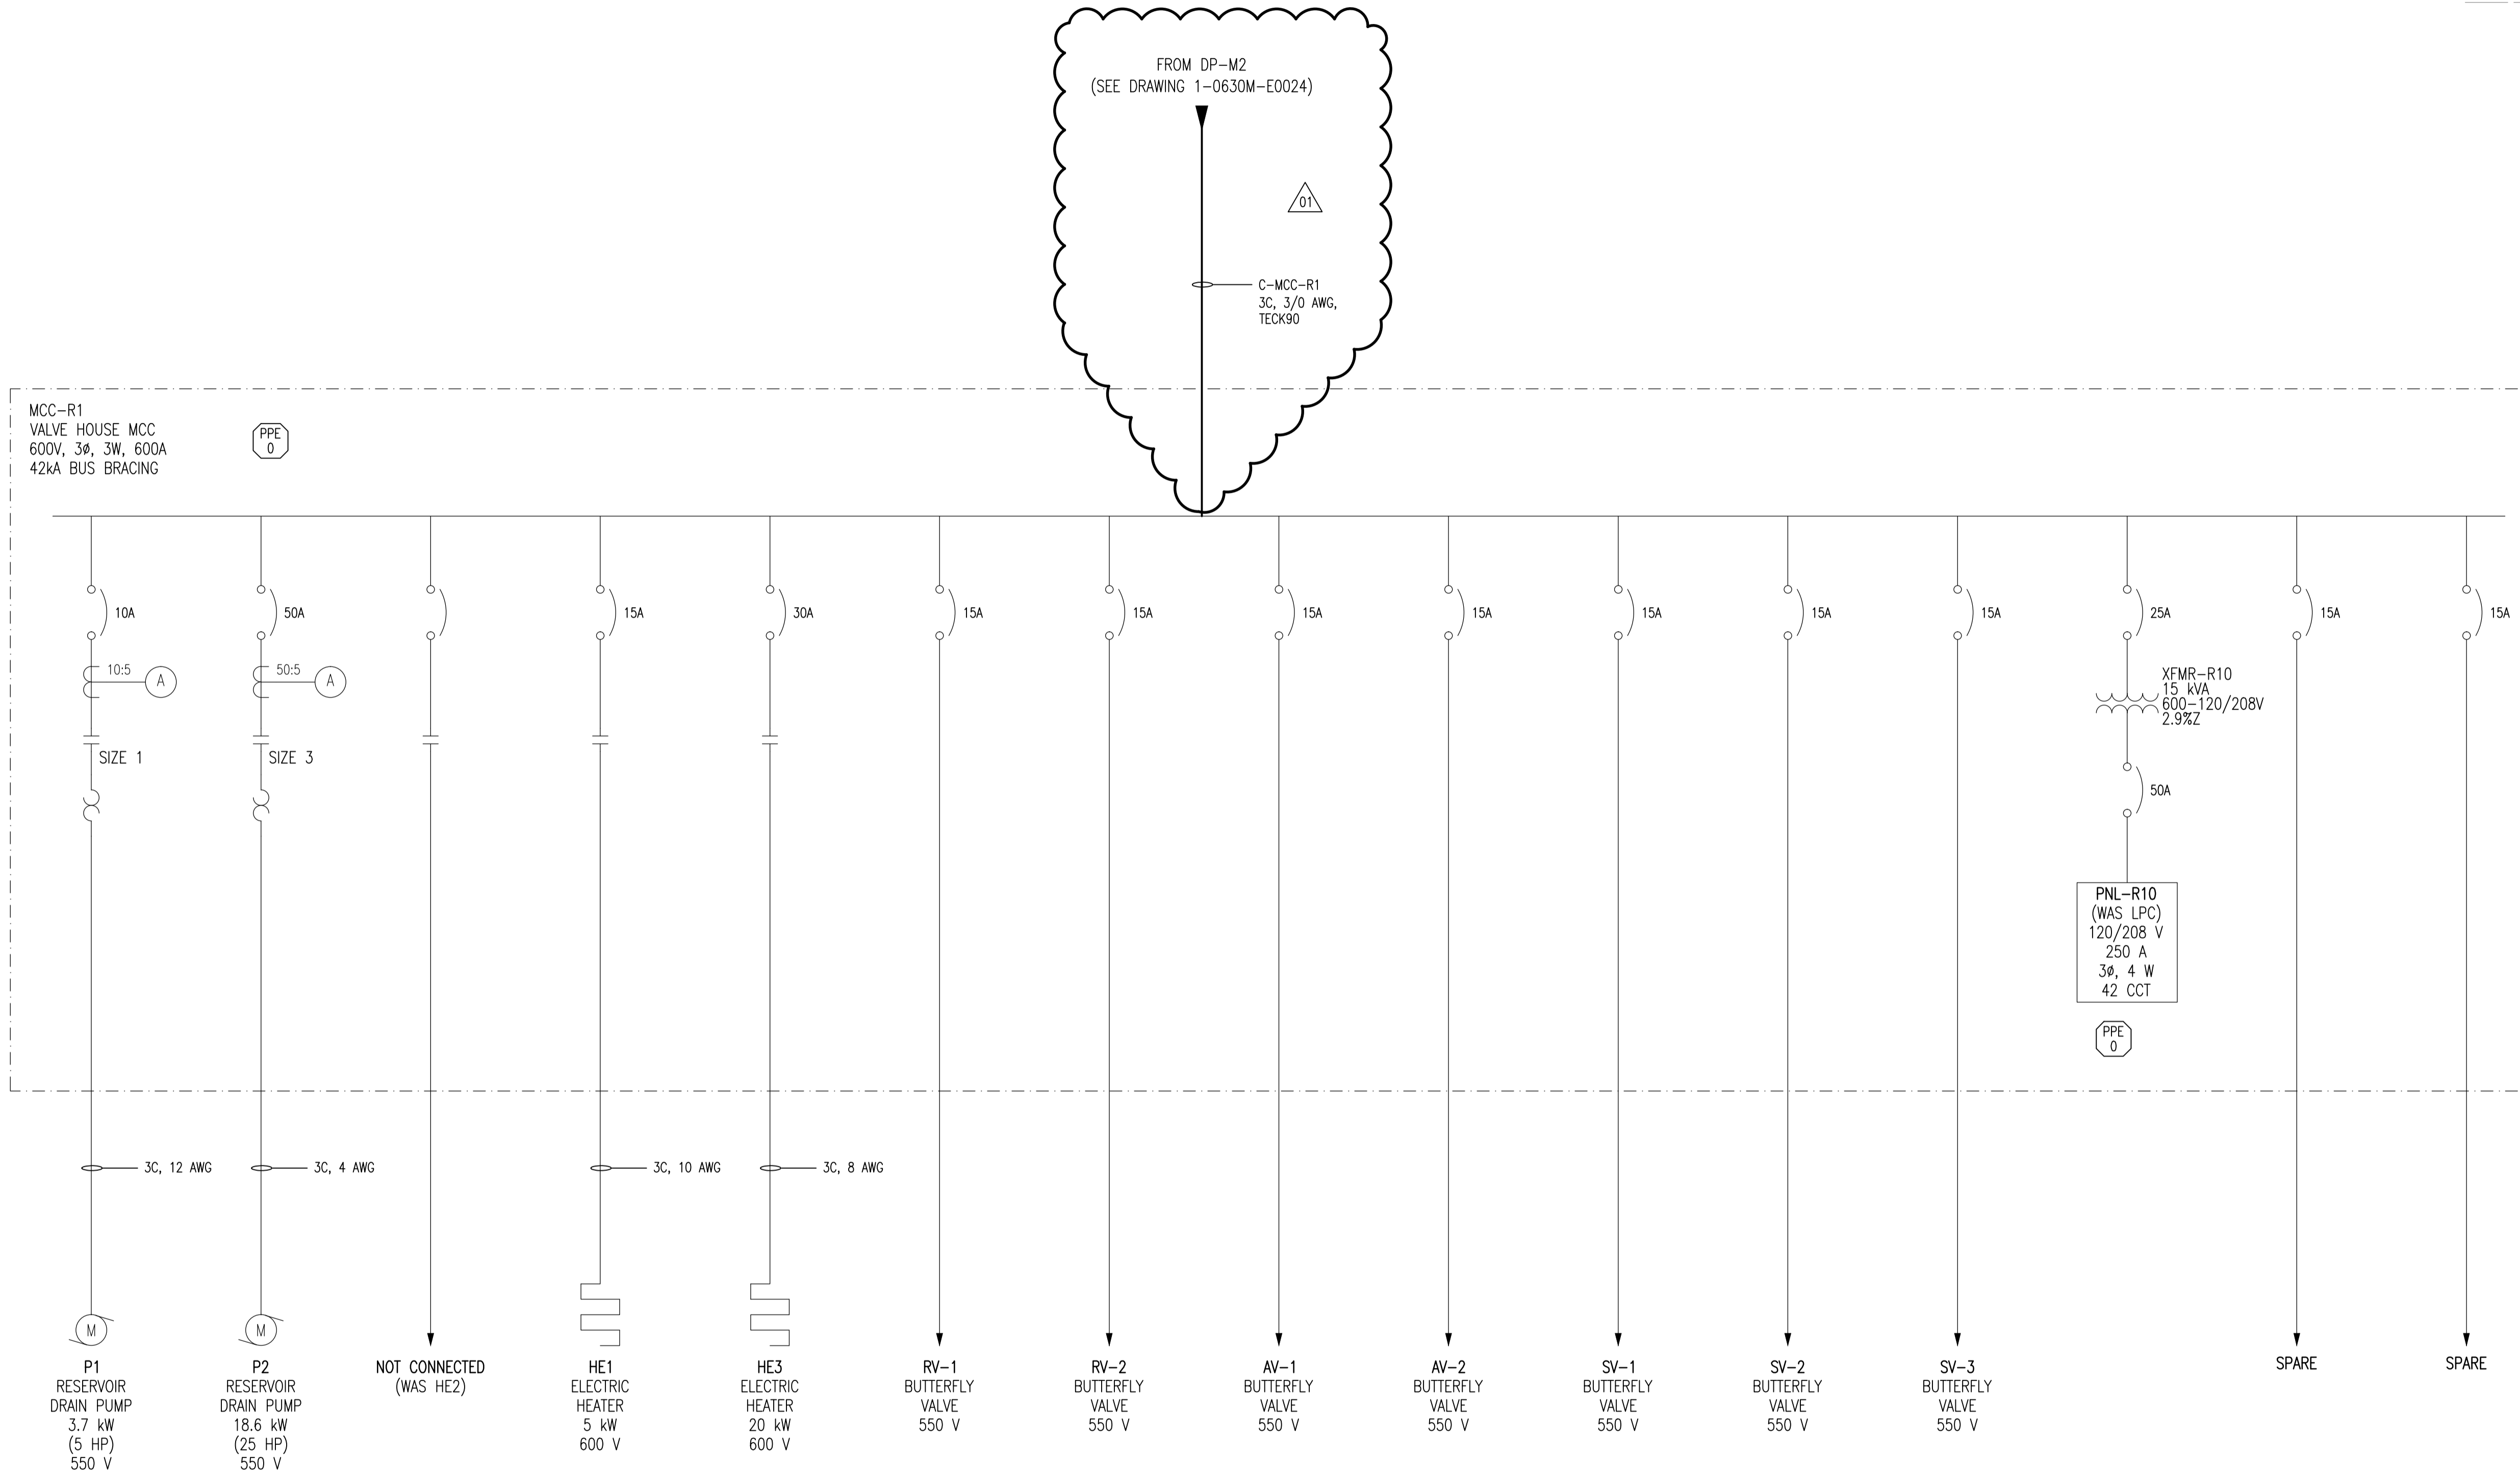

LAST SAVE: 2012/07/27 - 8:03am
 PATH: M:\508955\ENGL\7ELE\DD - General DWG\1-0630R-E0001-001-01.dwg

1-0630M-E0001	ELECTRICAL SINGLE LINE DIAGRAM LEGEND AND DETAILS
DRAWING NUMBER	REFERENCE DRAWINGS



NO.	REVISIONS	DATE	DESIGN	CHECK
01	ISSUED FOR TENDER, BID OPP. 490-2012	2012/07/23	BJC	CJR
00	ISSUED FOR CITY USE	2011/05/30	BC	CJR

SNC-LAVALIN INC.
 148 Nature Park Way
 Winnipeg, MB, Canada R3P 0X7
 204-786-8080

DESIGNED BY: EXISTING
 DRAWN BY: S. FUNK
 SCALE: NTS
 DATE: 2011/03/30

CHECKED BY: C. REIMER
 APPROVED BY: C. REIMER
 RELEASED FOR CONSTRUCTION BY:
 DATE:

CONSULTANT NO.: 508955-0000-47DD-0101

ENGINEER'S SEAL

PRELIMINARY
 NOT TO BE
 USED FOR
 CONSTRUCTION

THE CITY OF WINNIPEG
 WATER AND WASTE DEPARTMENT

MACLEAN WATER PUMPING STATION

ELECTRICAL SINGLE LINE DIAGRAM
 RESERVOIR VALVE HOUSE

CITY DRAWING NUMBER: 1-0630R-E0001

SHEET: 001	REV: 01	SIZE: A1
------------	---------	----------