
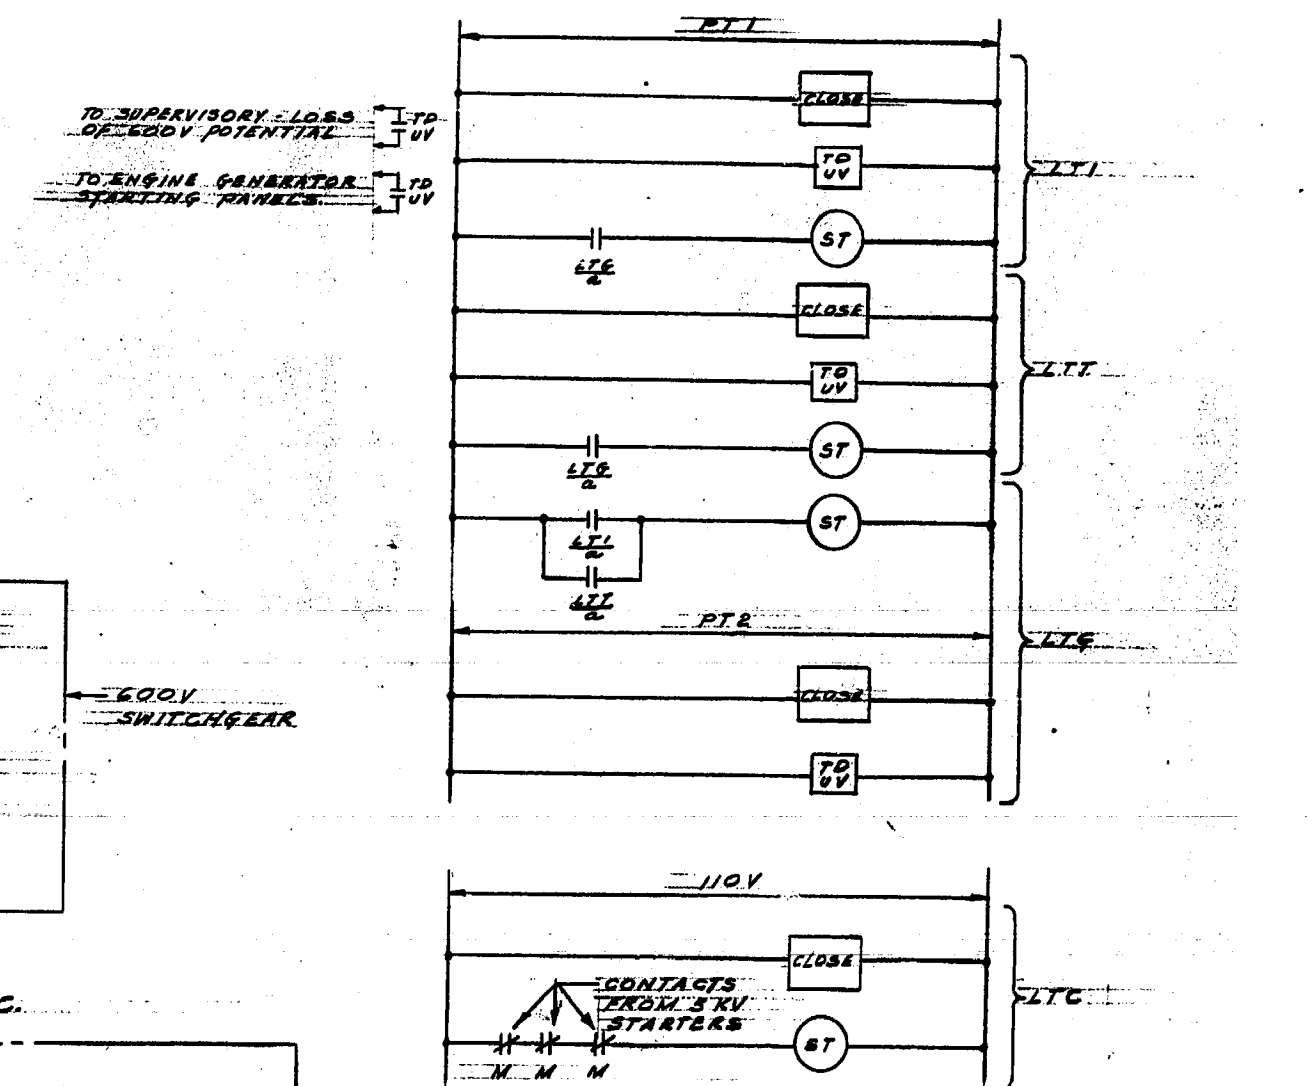
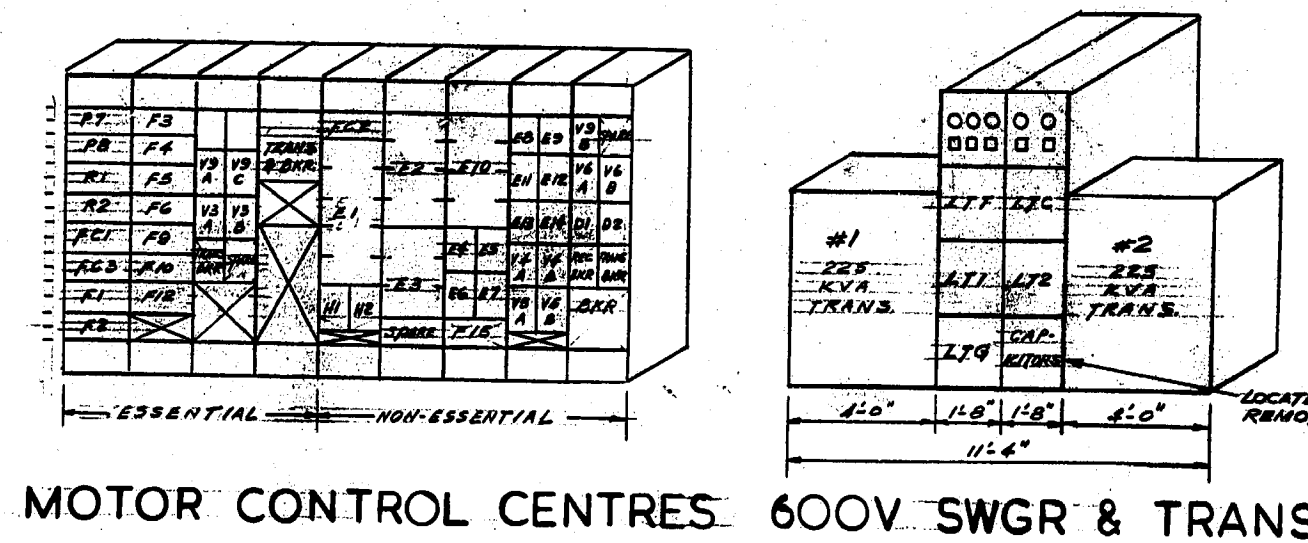
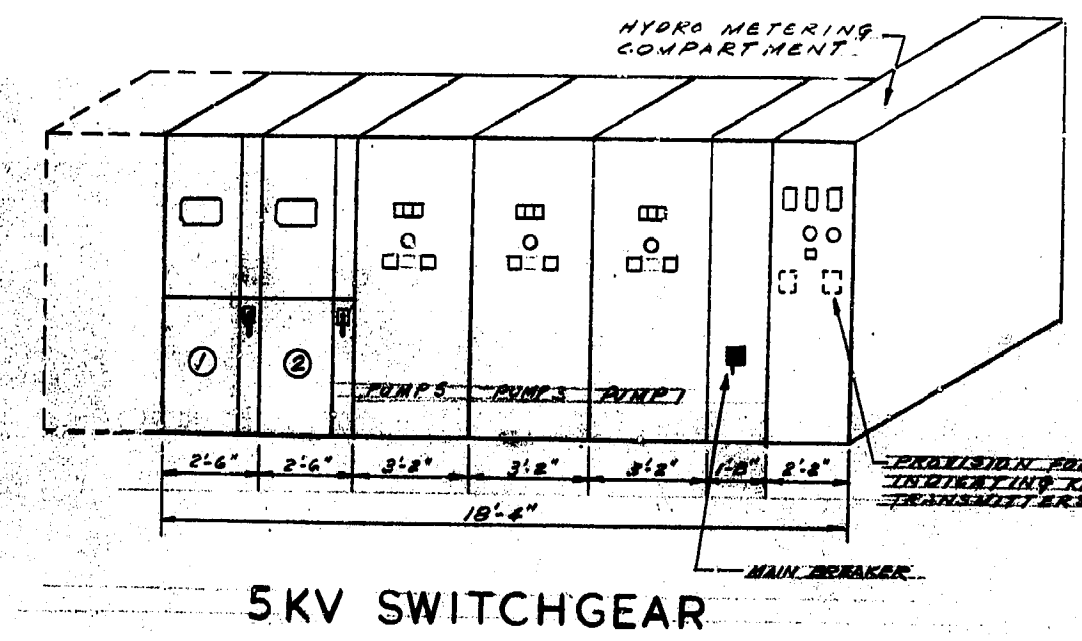


NOTES

- ← SUPPLIED UNDER ANOTHER SECTION OF THIS CONTRACT
- ← SUPPLIED UNDER A SEPARATE CONTRACT
- TOE END IDENTIFICATION OF RUN NUMBERS SEE CONDUIT & CABLE SCHEDULES ON DWG. No. 31
- FOR CONTROL DIAGRAMS SEE DWG. Nos. 29 & 31

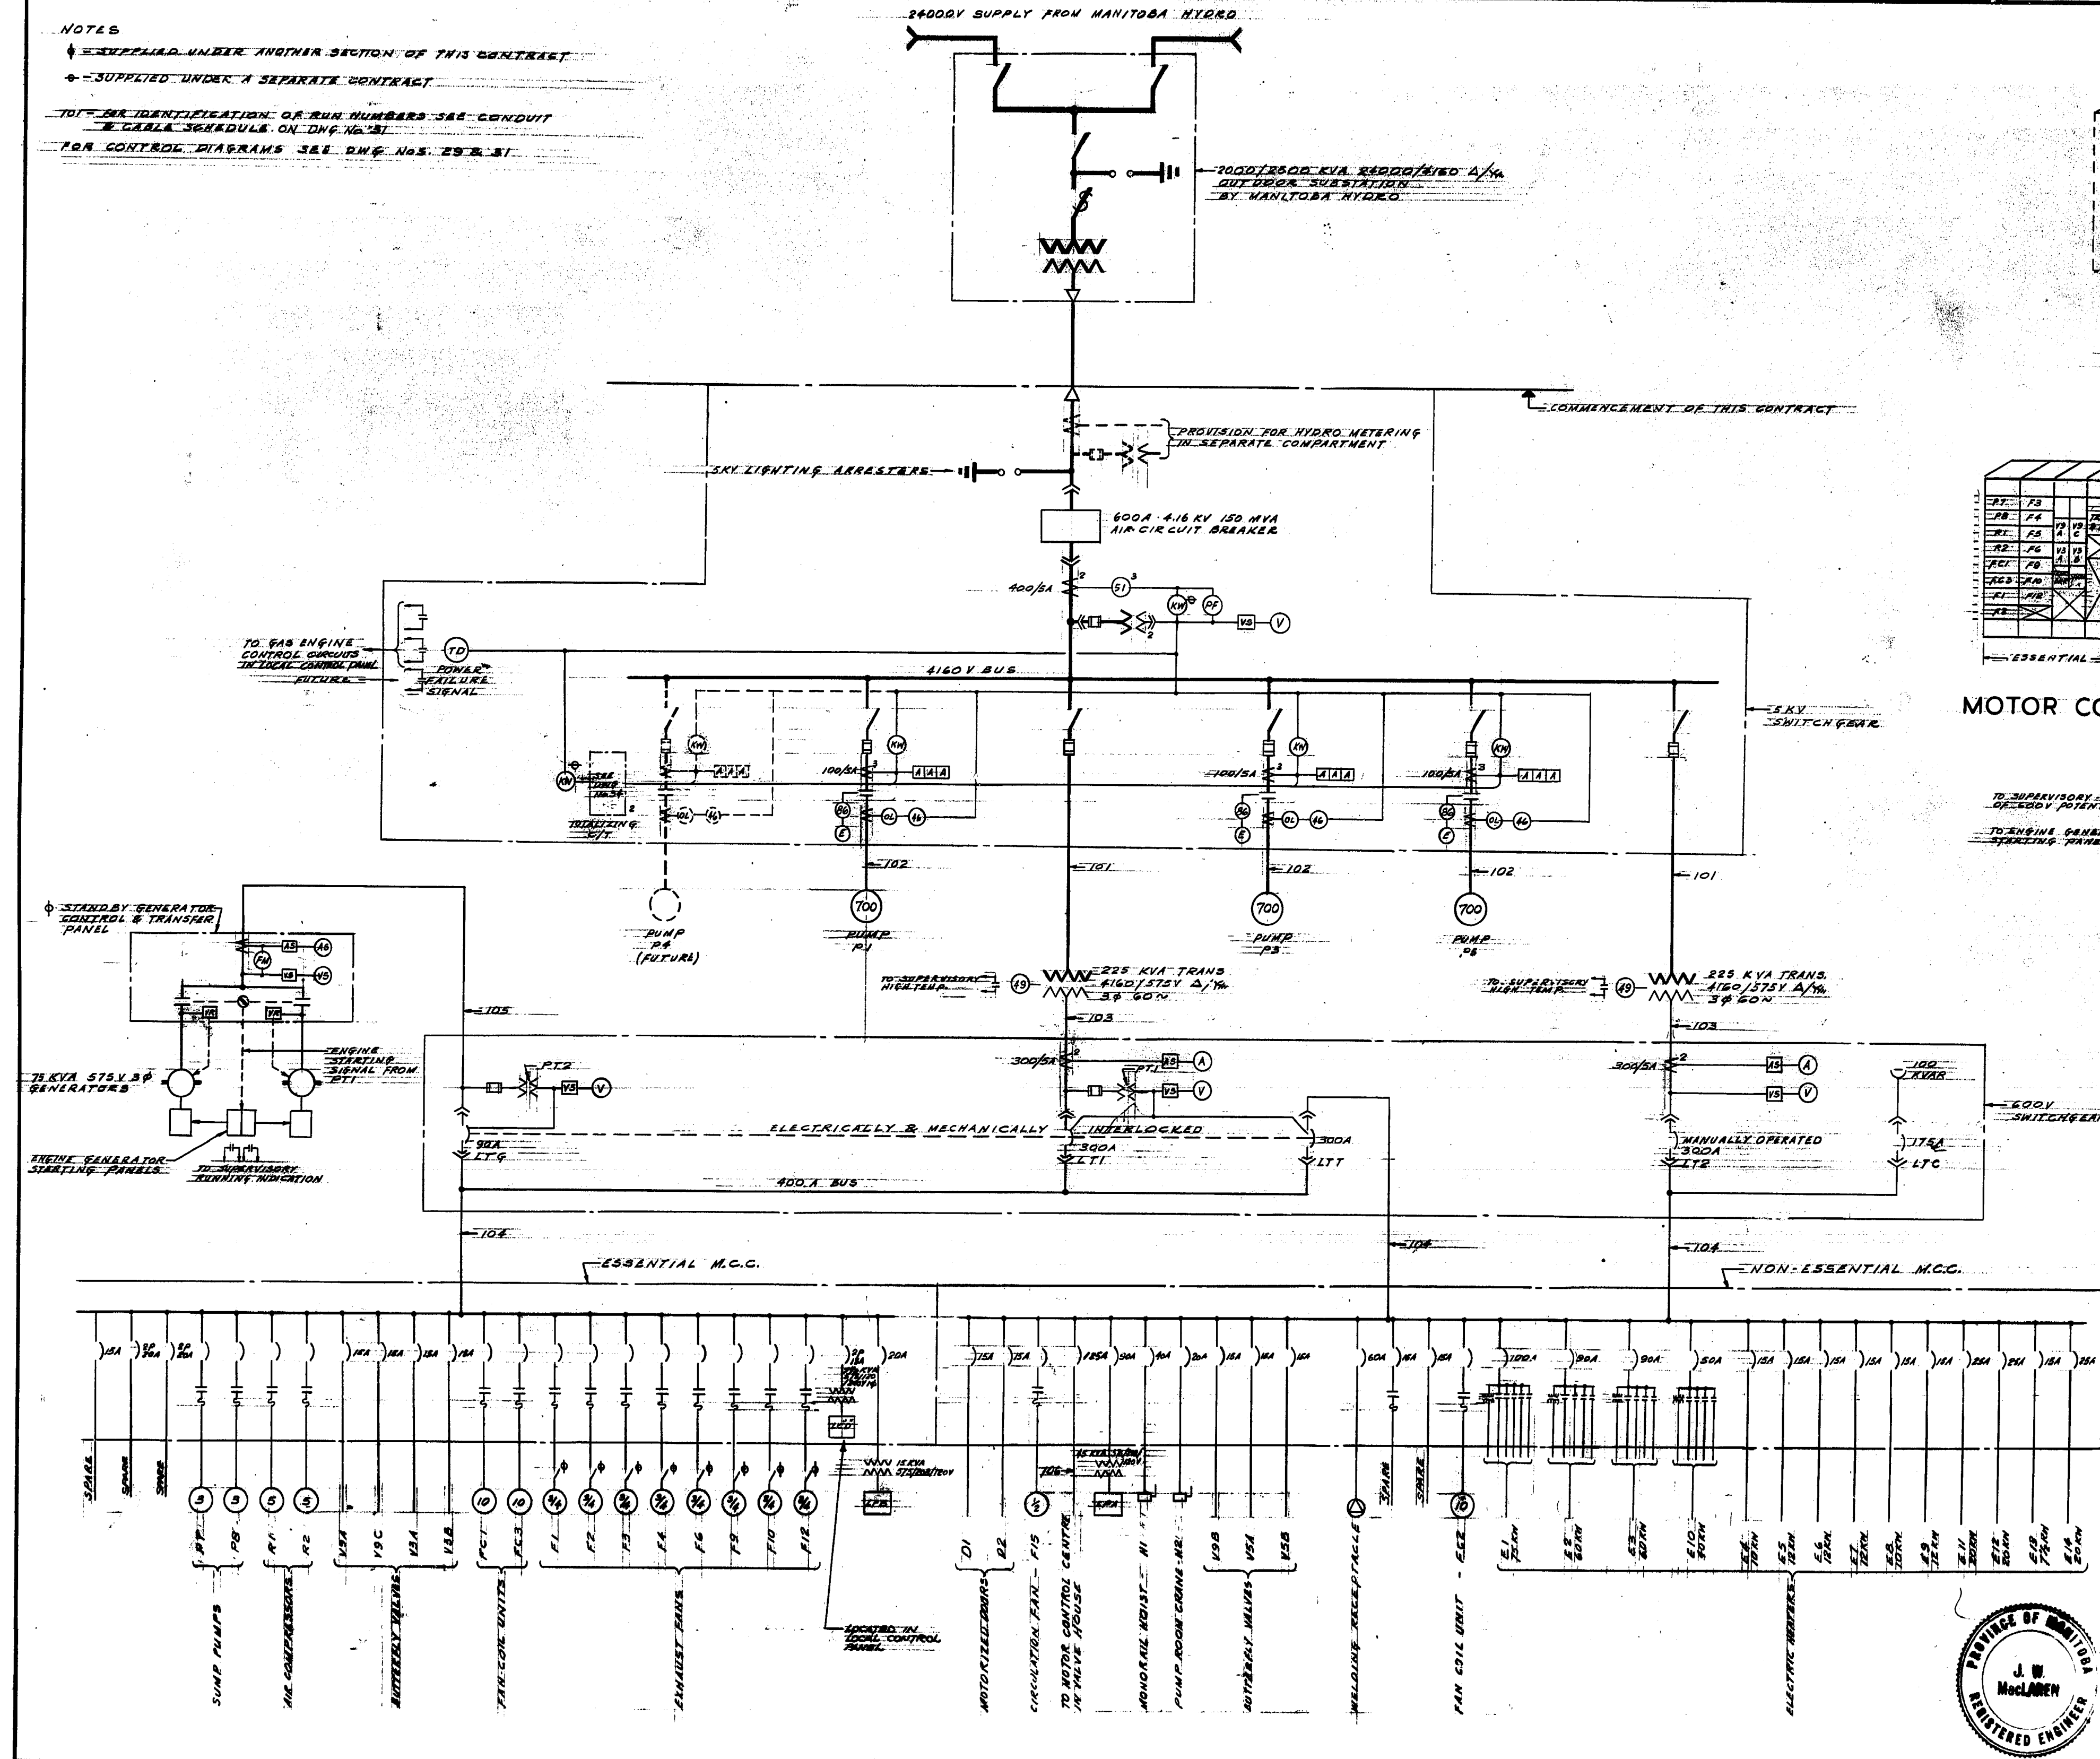

REVISED AS BUILT, JUNE - 1965

THE METROPOLITAN CORPORATION OF GREATER WINNIPEG
WATERWORKS AND WASTE DISPOSAL DIVISION

METRO EAST PUMPING STATION AND RESERVOIR

**CONTRACT A - PUMPING STATION
ELECTRICAL - SINGLE LINE
AND BLOCK DIAGRAMS**

APPROVED: J. W. MacLAREN, REGISTERED ENGINEER

DESIGN: JAMES F. McCLAREN ASSOCIATES, ENGINEERS

TEMPLETON ENGINEERING COMPANY, PROFESSIONAL ENGINEERS, WINNIPEG

DATE: JUNE 22, 1962

SCALE: NOT TO SCALE

DWG. No. 28

OP. 41

ME-35