
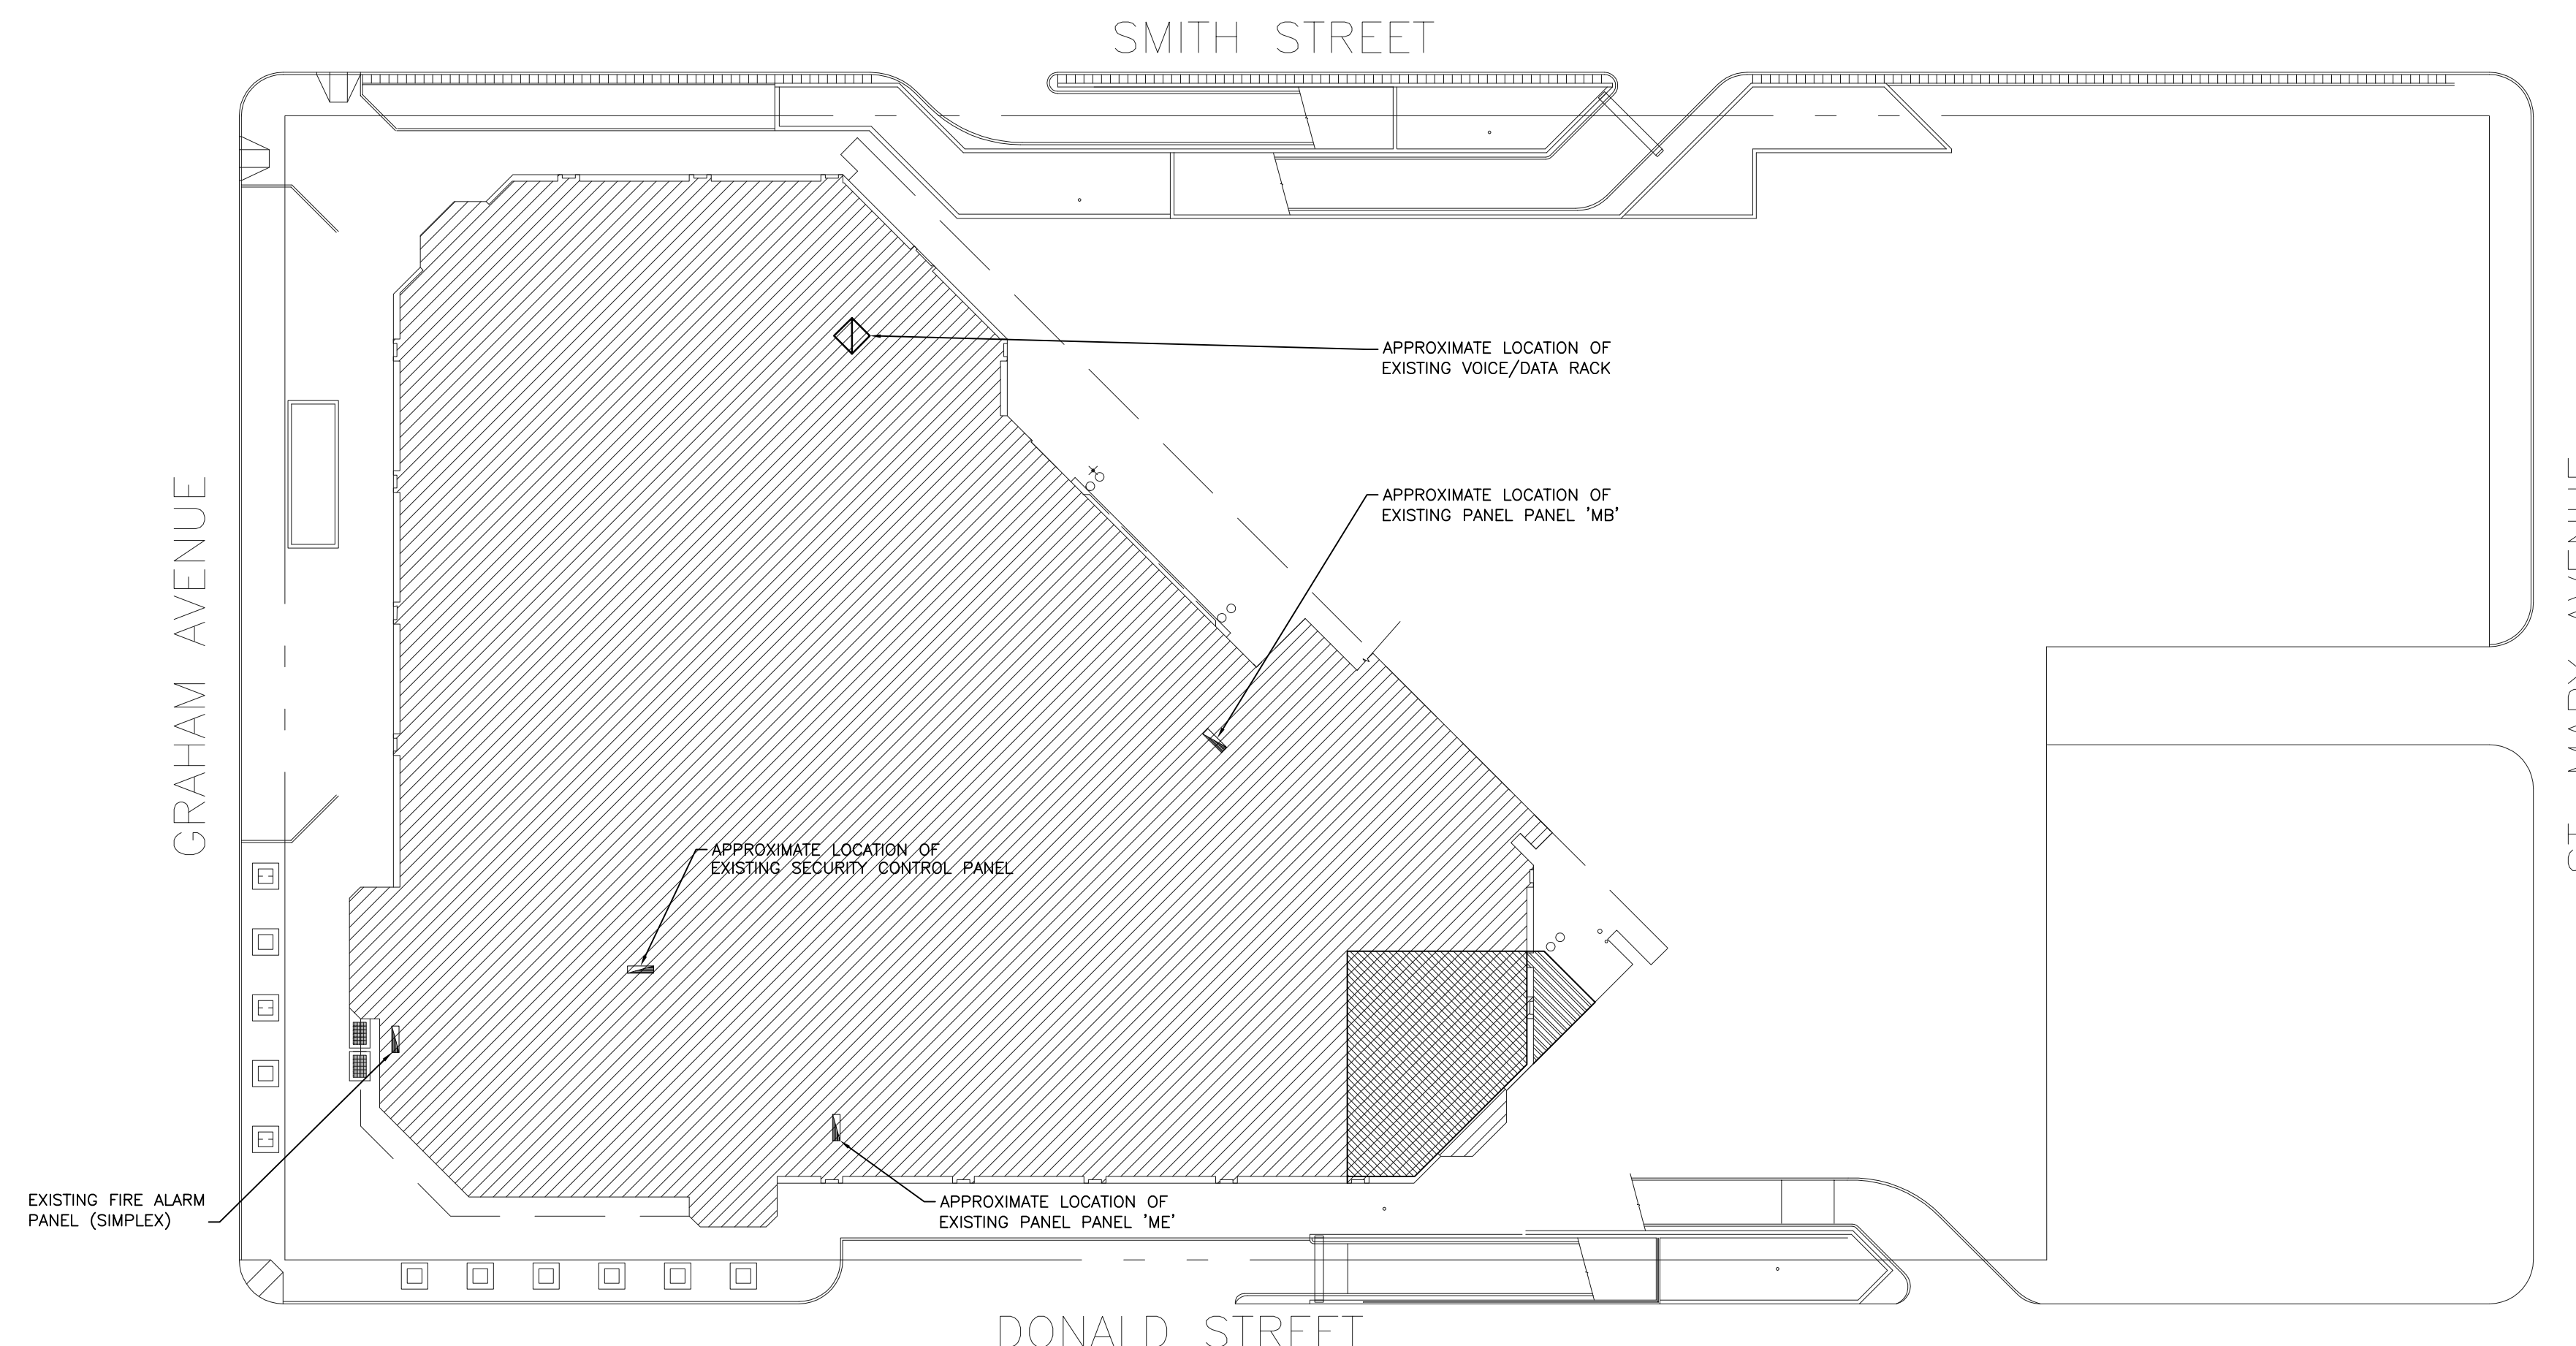


**DRAWING LIST**

- E1.0 - DRAWING LIST, SYMBOL LEGEND AND SITE PLAN - ELECTRICAL
- E2.0 - DEMOLITION PLAN - ELECTRICAL AND RENOVATION PLAN - LIGHTING
- E3.0 - RENOVATION PLAN - POWER AND SYSTEMS, SINGLE LINE AND PANEL SCHEDULE
- E4.0 - ELECTRICAL SPECIFICATION

FIRE DETECTION		RECEPTACLE AND POWER	
■	PULL STATION	⏏	DUPLEX RECEPTACLE
⊙	SMOKE DETECTOR	⏏	DUPLEX RECEPTACLE & VOICE DATA OUTLET FLOOR MOUNTED
■	HORN SPEAKER	⊗	JUNCTION BOX
↑	END OF LINE RESISTOR	⊠	MANUAL STARTER (OR TOGGLE SWITCH FOR MOTORS 1/6 HP OR SMALLER C/W BUILT IN OVER-LOAD PROTECTION)
SYSTEMS AND COMMUNICATION		⊗	MOTOR AND DISCONNECT
□	CCTV CAMERA OUTLET (LOCAL)	▭	SURFACE MOUNTED PANEL
⏏	MOTION DETECTOR	EMERGENCY AND EXIT LIGHTING	
⊗	CEILING MOUNTED SPEAKER (PAGING SYSTEM)	EXIT	EXIT LIGHT
⊠	KEY PAD	LIGHTING	
⏏	DOOR ALARM CONTACT	FLUO	FLUORESCENT FIXTURE, A1-PANEL AND CIRCUIT, a-CONTROL
ML	MAGNETIC LOCK	EMER	LIGHT FIXTURE CONNECTED TO EMERGENCY POWER OR NIGHT LIGHT CIRCUIT (TYPICAL FOR ALL LIGHT FIXTURES)
ABBREVIATIONS		○	DOWN LIGHT
F	FLUSH FLOOR MOUNTED	* PLEASE NOTE *	
WP	WEATHER PROOF	ALL EQUIPMENT SHOWN "FADED BACK" IS EXISTING TO REMAIN UNLESS OTHERWISE NOTED.	
R	EXISTING TO BE RELOCATED	ALL EQUIPMENT SHOWN "DASHED" IS EXISTING TO BE DEMOLISHED.	

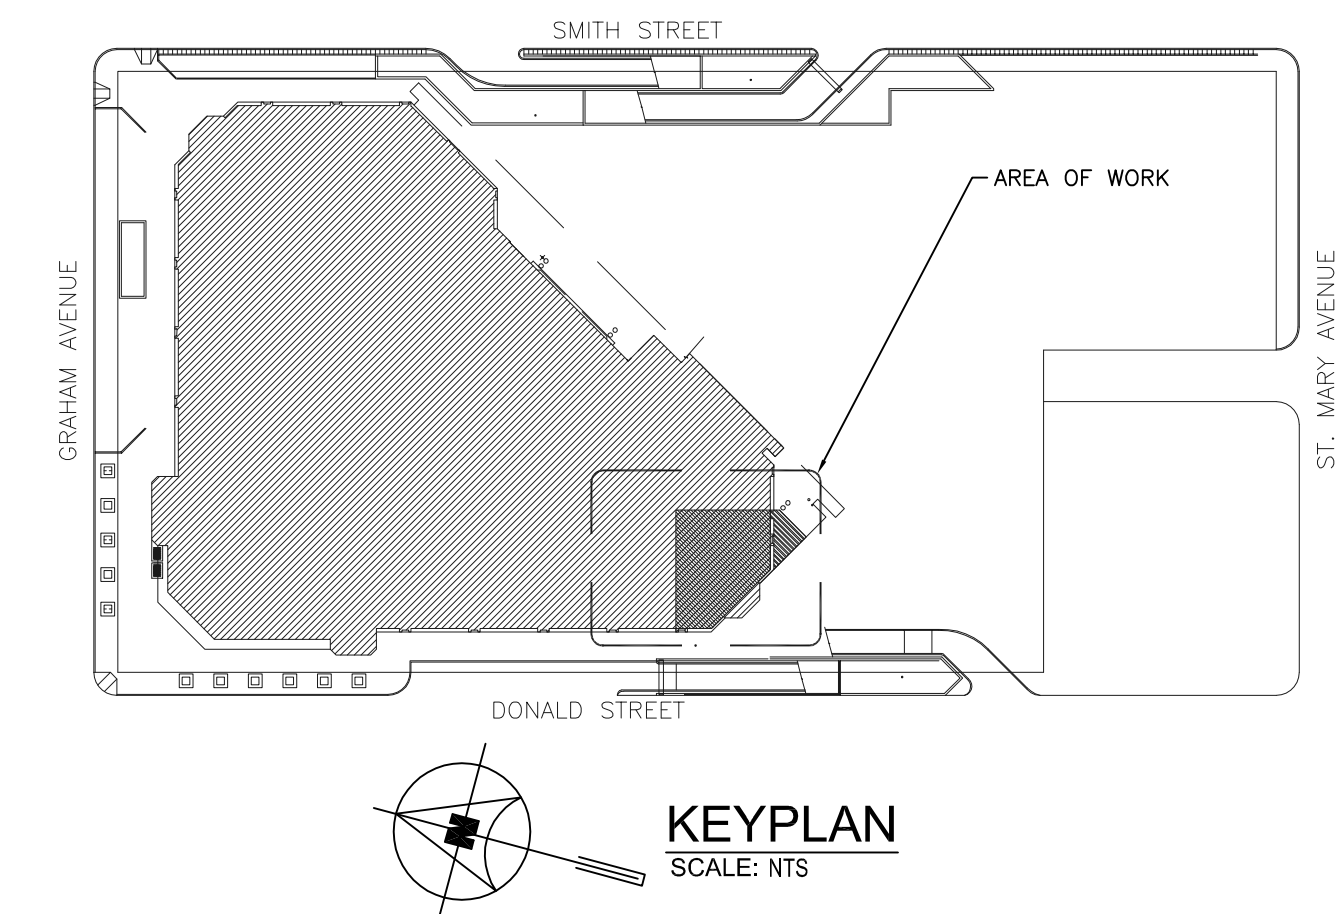

**1 SITE PLAN - ELECTRICAL**  
E1.0 SCALE: 1/32"=1'-0"

2.	ISSUED FOR TENDER	TG	12.07.04
1.	ISSUED FOR 99% REVIEW	TG	12.06.25
NO.	REVISIONS	BY	YR/MNDY

The contractor shall check all dimensions and other data from the job and report any discrepancies to the architects before proceeding.  
This drawing and the information on it, is proprietary and confidential. Reproduction of any sort is prohibited without the written approval of **MMP Architects Inc.**

**PROJECT TITLE**  
Southwest Entrance Development -  
Millenium Library  
251 Donald Street, Winnipeg, MB

**DRAWING TITLE**  
Drawing List, Symbol Legend and  
Site Plan - Electrical

**SMS ENGINEERING**  
SMS Engineering Ltd. Consulting Engineers  
770 Brandon Street Winnipeg MB Canada R3B 0K6  
Telephone 204.775.0291 Fax 204.772.2153  
12-175-01  
sms@smseng.com

**MMP ARCHITECTS**  
300 - 214 McDermot Avenue, Winnipeg Manitoba R3B 0S3  
Tel (204) 956-0530 Fax (204) 943-5704 www.mmparchitects.com

**APCGM**  
Certificate of Authorization  
SMS Engineering Ltd.  
No. 166 Expiry: April 30, 2013



APPROVED	CHECKED	DRAWN BY
CJH	TG	JB
SCALE	DATE	FILE NO.
1/32"=1'-0"	June 2012	12-175-01
DRAWING NUMBER	REVISION NUMBER	
<b>E1.0</b>	<b>2</b>	
CAD FILE:	DRAWER NO:	