
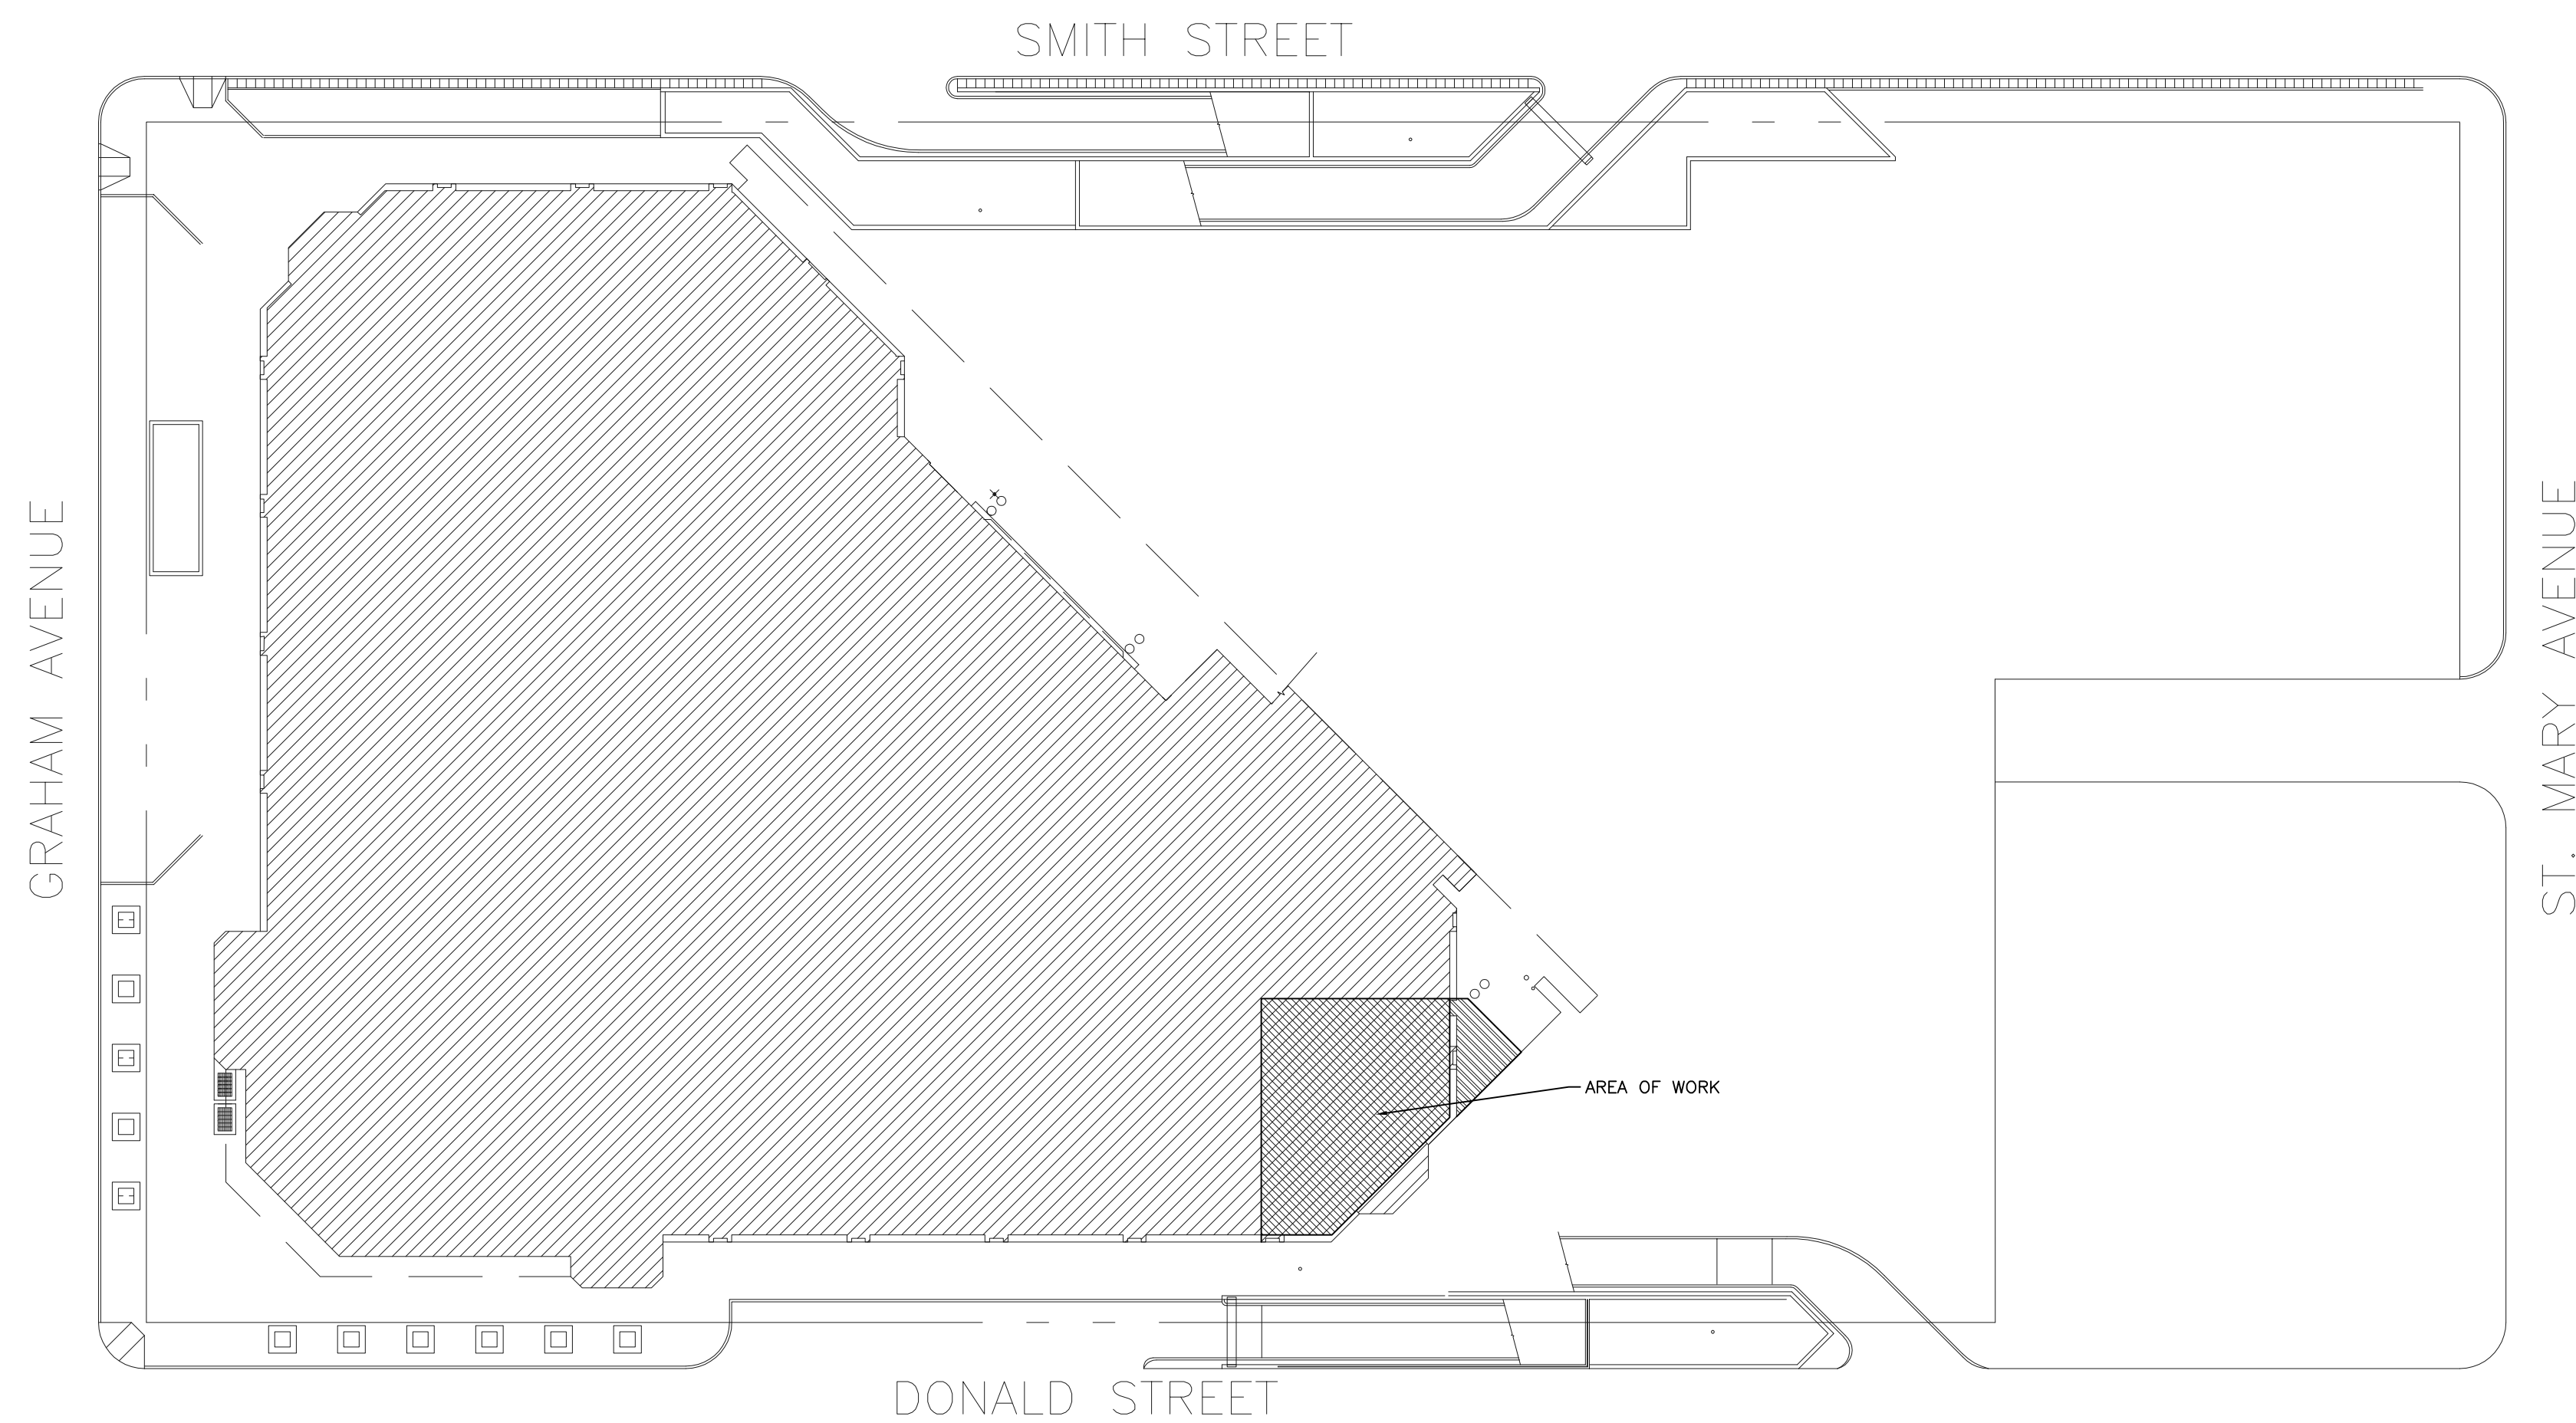


DRAWING LIST

- M1.0 - DRAWING LIST, SYMBOL LEGEND AND SITE PLAN - MECHANICAL
- M2.0 - PARTIAL MAIN FLOOR PLAN - HVAC DEMOLITION AND RENOVATION
- M3.0 - MECHANICAL SPECIFICATION

HVAC LEGEND

⊙	THERMOSTAT												
⊙ E ⊙ R	EXISTING, RELOCATED, THERMOSTAT												
##	EQUIPMENT DESIGNATION												
<table border="0"> <tr> <td>A</td> <td>GRILLE/DIFFUSER TYPE</td> <td rowspan="4">} GRILLE OR DIFFUSER DESIGNATION</td> </tr> <tr> <td>NECK</td> <td>NECK SIZE</td> </tr> <tr> <td>YZX</td> <td>QUANTITY OR NUMBER OF</td> </tr> <tr> <td>FLOW</td> <td>FLOW RATE (CFM OR L/S)</td> </tr> <tr> <td>SIZE/THROW</td> <td>FACE SIZE OR THROW</td> <td></td> </tr> </table>	A	GRILLE/DIFFUSER TYPE	} GRILLE OR DIFFUSER DESIGNATION	NECK	NECK SIZE	YZX	QUANTITY OR NUMBER OF	FLOW	FLOW RATE (CFM OR L/S)	SIZE/THROW	FACE SIZE OR THROW		
A	GRILLE/DIFFUSER TYPE	} GRILLE OR DIFFUSER DESIGNATION											
NECK	NECK SIZE												
YZX	QUANTITY OR NUMBER OF												
FLOW	FLOW RATE (CFM OR L/S)												
SIZE/THROW	FACE SIZE OR THROW												
<table border="0"> <tr> <td>TYPE</td> <td rowspan="3">RADIATION UNIT DESIGNATION</td> </tr> <tr> <td>SIZE</td> </tr> <tr> <td>OUTPUT</td> </tr> </table>	TYPE	RADIATION UNIT DESIGNATION	SIZE	OUTPUT									
TYPE	RADIATION UNIT DESIGNATION												
SIZE													
OUTPUT													

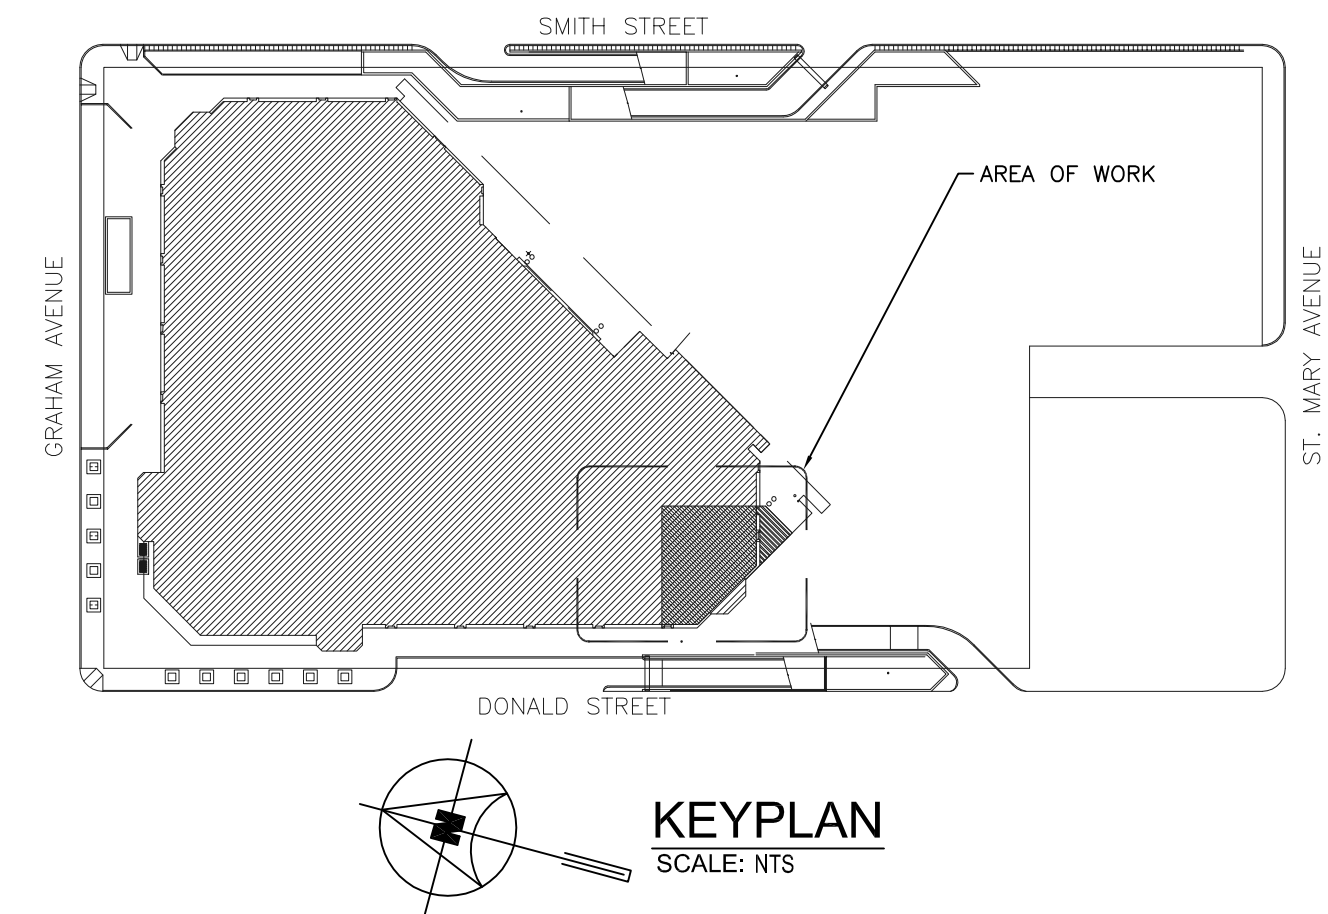

1 SITE PLAN - MECHANICAL
M1.0 SCALE: 1/32"=1'-0"

2.	ISSUED FOR TENDER	12.07.04
1.	ISSUED FOR 99% REVIEW	TG 12.06.25
NO.	REVISIONS	BY YR/ND/Y

The contractor shall check all dimensions and other data from the job and report any discrepancies to the architects before proceeding.
This drawing and the information on it, is proprietary and confidential. Reproduction of any sort is prohibited without the written approval of *MMP Architects Inc.*

PROJECT TITLE
Southwest Entrance Development - Millenium Library
251 Donald Street, Winnipeg, MB

DRAWING TITLE
Drawing List, Symbol Legend and Site Plan - Mechanical

SMS ENGINEERING

SMS Engineering Ltd. Consulting Engineers
770 Barendse Street Winnipeg MB Canada R3B 0K6
Telephone 204.775.0291 Fax 204.772.2153
sms@smseng.com

12-175-01

MMP ARCHITECTS

300 - 214 McDermot Avenue, Winnipeg Manitoba R3B 0S3
Tel (204) 956-0530 Fax (204) 943-5704 www.mmparchitects.com



APPROVED	CHECKED	DRAWN BY
CF	CF	AS
SCALE	DATE	FILE NO.
1/32"=1'-0"	June 2012	12-175-01
DRAWING NUMBER	REVISION NUMBER	
M1.0	2	
CAD FILE:	DRAWER NO:	