



1 DEMOLITION PLAN - HVAC
M2.0 SCALE: 1/8"=1'-0"

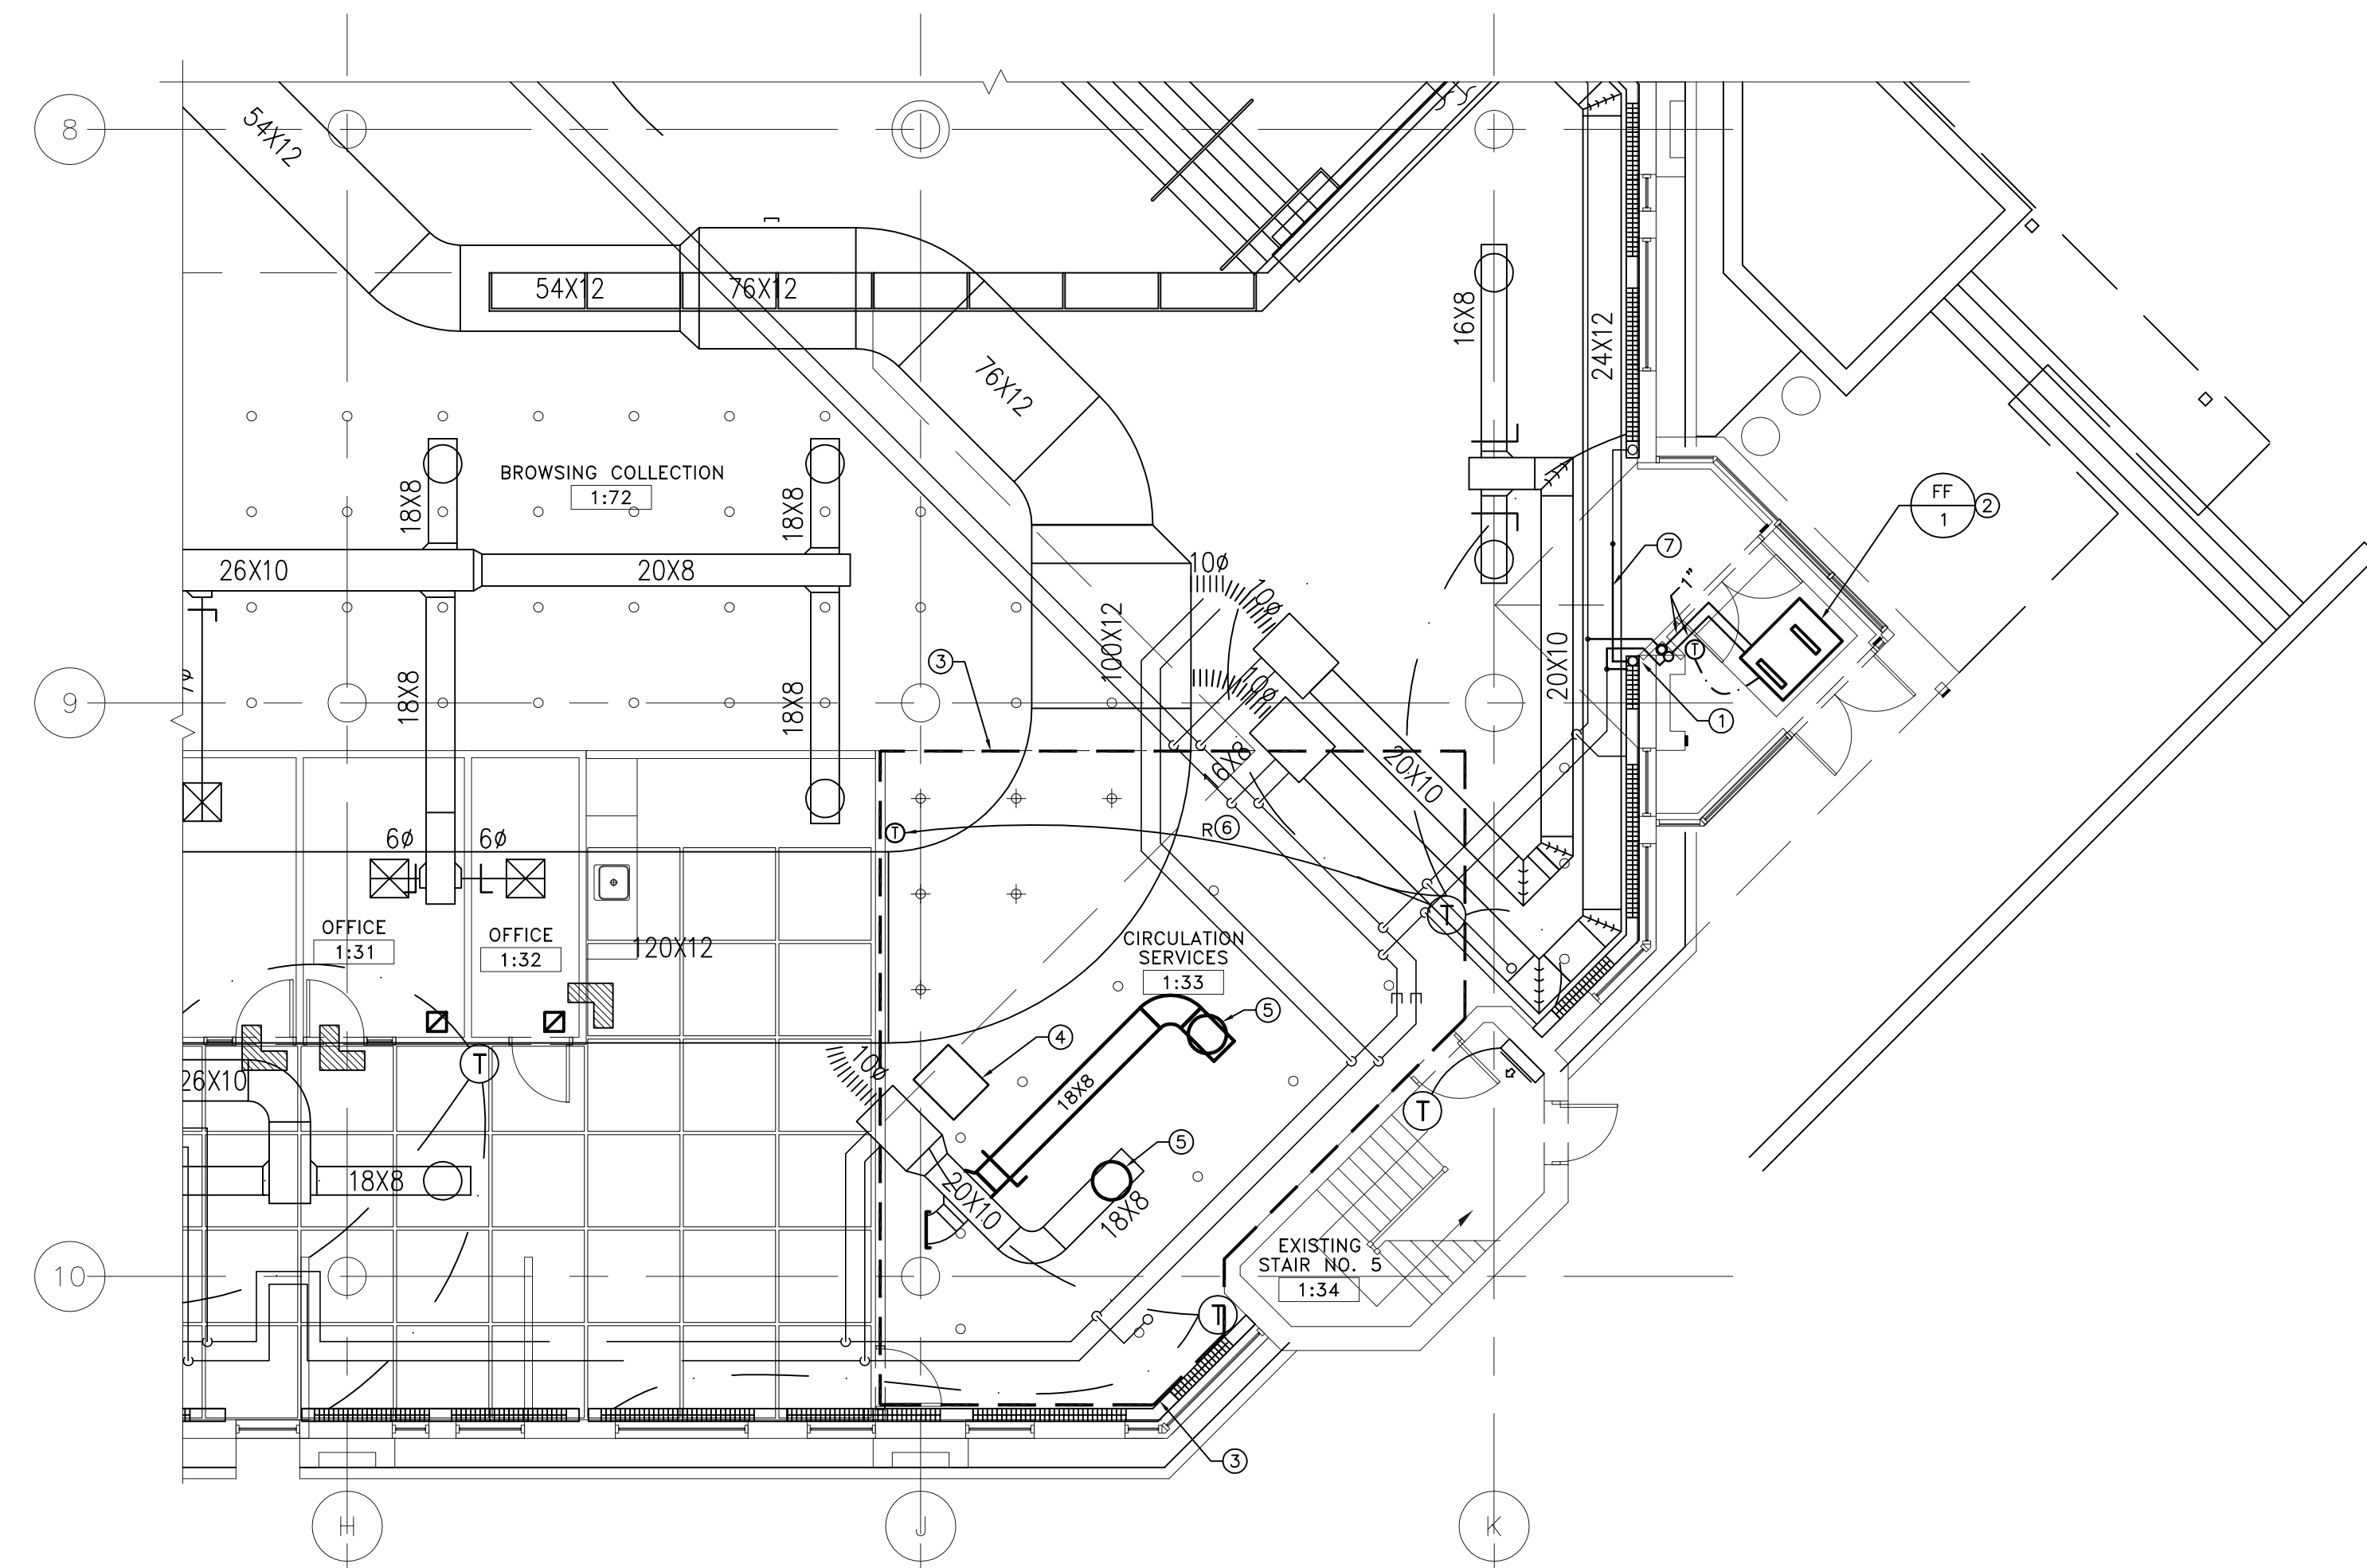

2 RENOVATION PLAN - HVAC
M2.0 SCALE: 1/8"=1'-0"

DEMOLITION NOTES ##

1. DEMOLISH DUCTWORK AND DIFFUSER.
2. CUT BACK RADIANT PANEL, AND STRIP FINS.

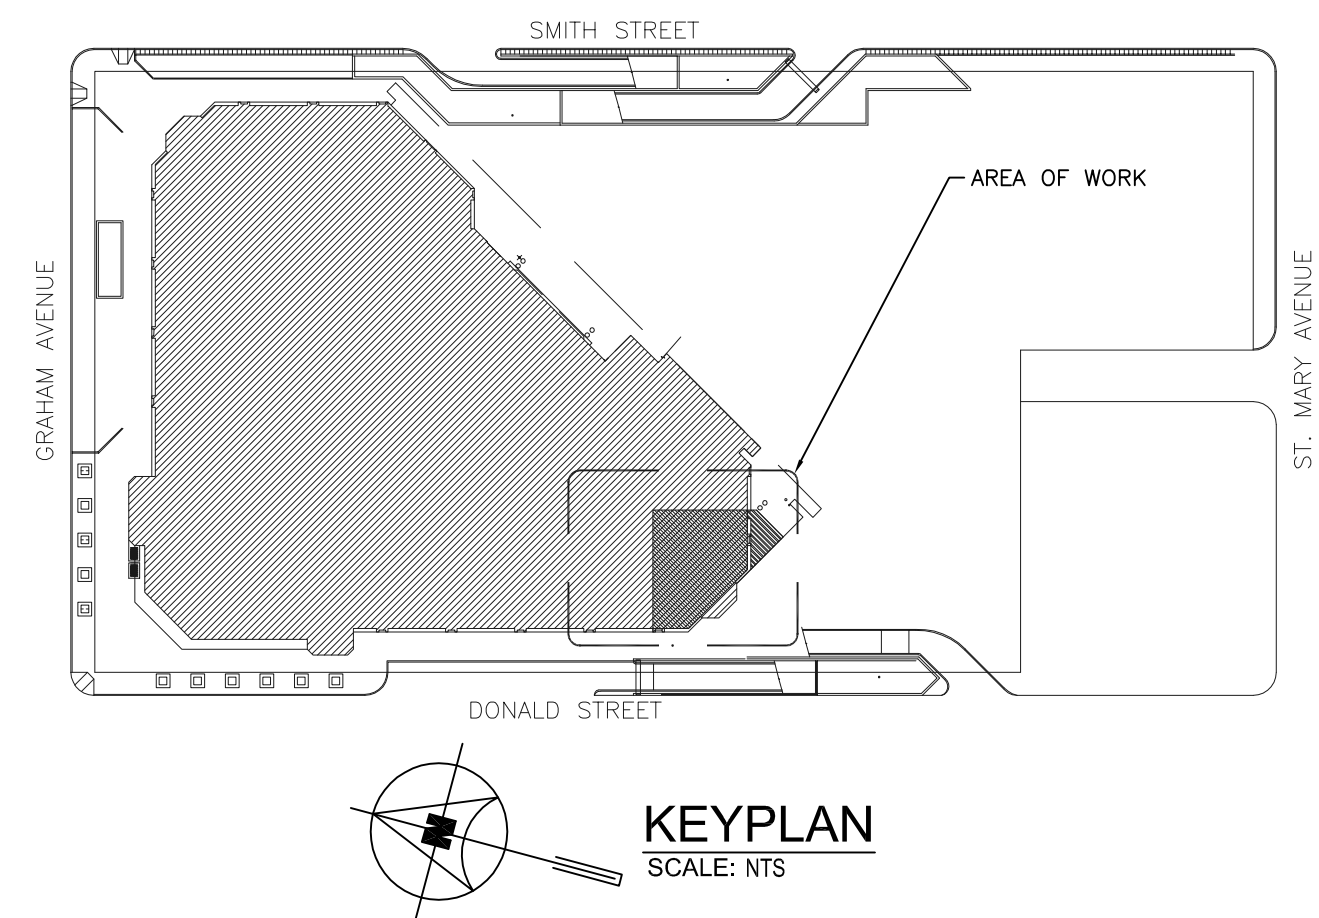

KEY NOTES ①

1. PROVIDE A NEW COVER FOR RADIANT PANEL AND RE-PIPE.
2. NEW CEILING FORCE FLOW.
3. REVISE SPRINKLER LAYOUT FOR NEW WALL AND CEILING IN THIS AREA. SPRINKLER TO BE CONCEALED TYPE.
4. PROVIDE AN ACCESS DOOR FOR EXISTING VAV BOX.
5. PROVIDE NEW RCD DIFFUSER FOR CEILING.
6. RELOCATE THERMOSTAT TO NEW WALL.
7. RC PIPE TO EXISTING RADIATOR.

NO.	REVISIONS	BY	DATE
2.	ISSUED FOR TENDER		12.07.04
1.	ISSUED FOR 99% REVIEW		12.06.25

The contractor shall check all dimensions and other data from the job and report any discrepancies to the architects before proceeding. This drawing and the information on it, is proprietary and confidential. Reproduction of any sort is prohibited without the written approval of MMP Architects Inc.

PROJECT TITLE
**Southwest Entrance Development -
 Millenium Library**
 251 Donald Street, Winnipeg, MB

DRAWING TITLE
**Partial Main Floor Plan - HVAC -
 Demolition & Renovation**

SMS ENGINEERING

SMS Engineering Ltd. Consulting Engineers
 770 Brandon Street Winnipeg MB Canada R3B 0K6
 Telephone 204.775.0291 Fax 204.772.2153
 sms@smseng.com

12-175-01

MMP ARCHITECTS

300 - 214 McDermot Avenue, Winnipeg Manitoba R3B 0S3
 Tel (204) 956-0530 Fax (204) 943-5704 www.mmparchitects.com



APPROVED	CHECKED	DRAWN BY
CF	CF	IE
SCALE	DATE	FILE NO.
1/8"=1'-0"	June 2012	12-175-01
DRAWING NUMBER	REVISION NUMBER	
M2.0	2	
CAD FILE:	DRAWER NO:	