


1 MAIN FLOOR RCP
A1.2 1:50

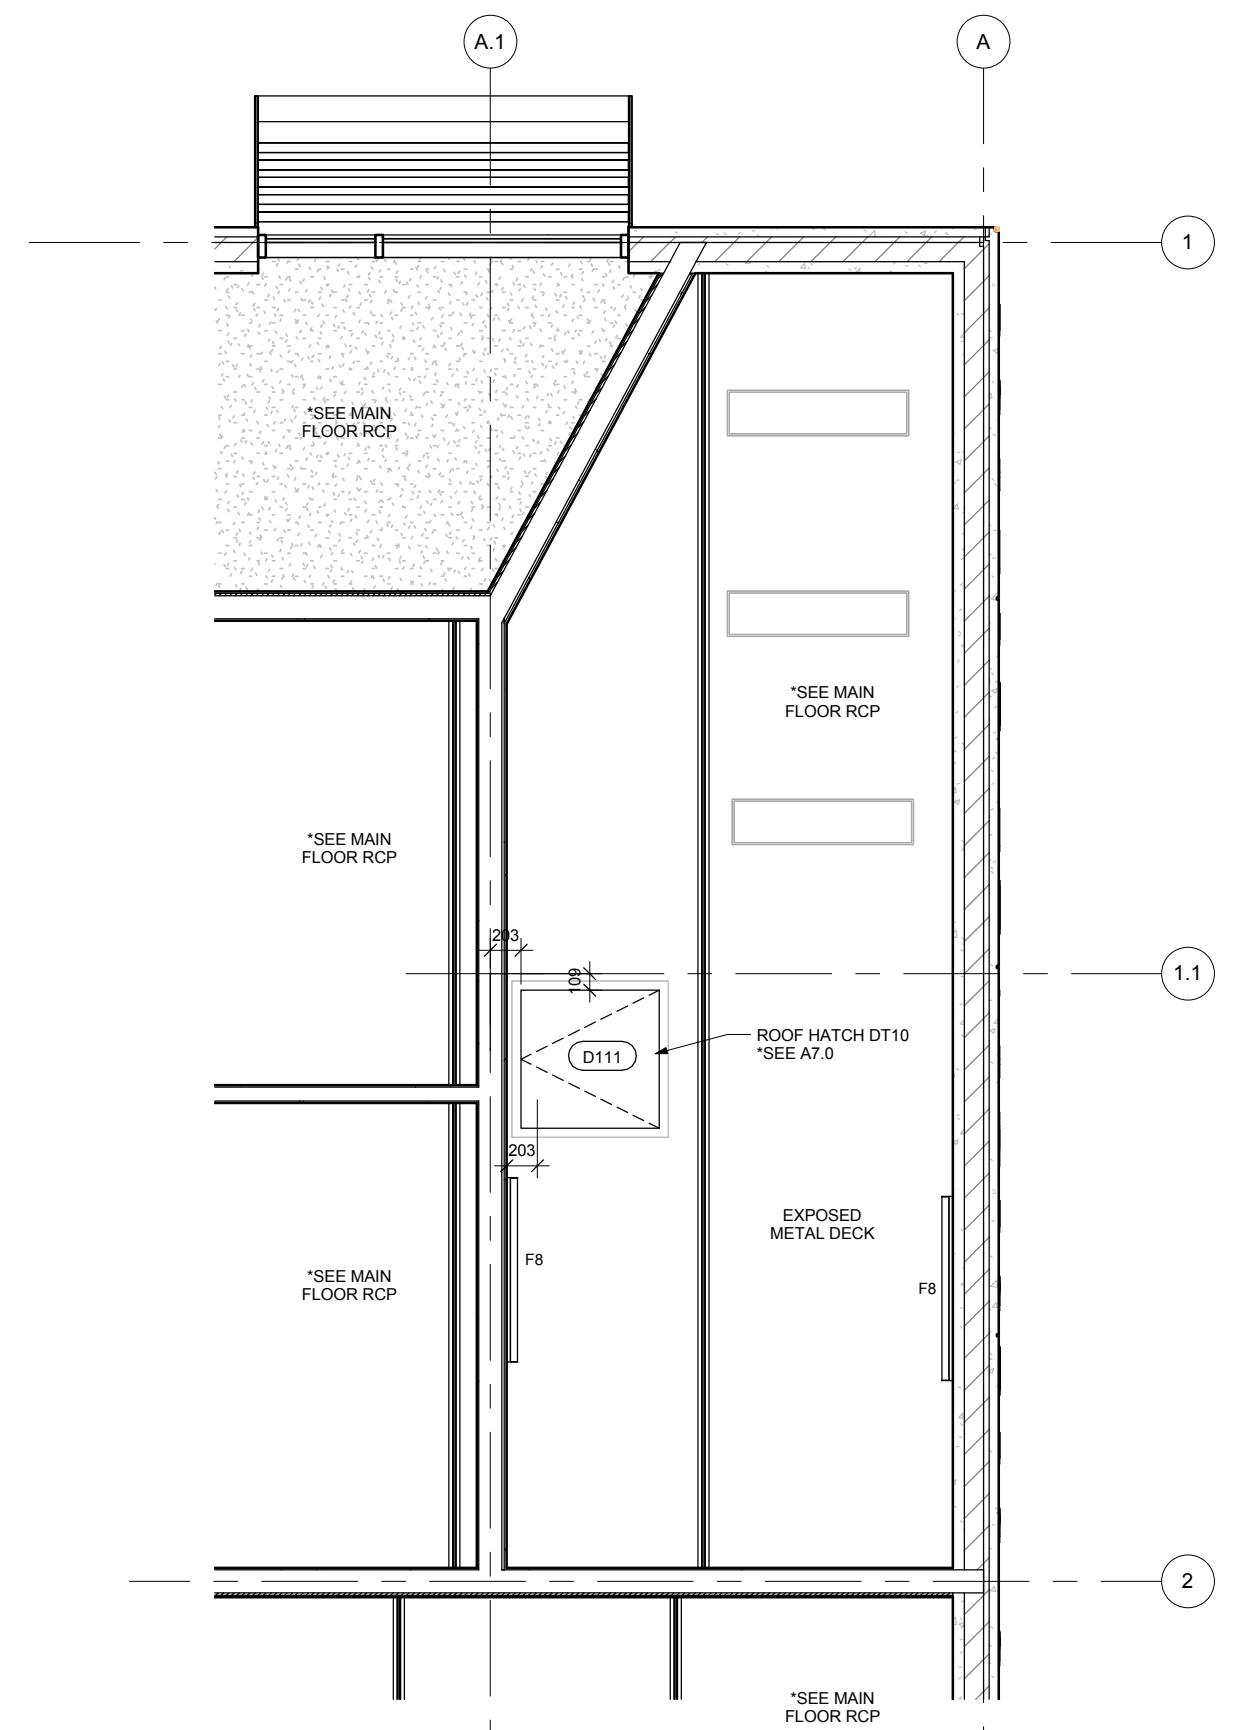


2 ELEVATED MAINTENANCE CATWALK RCP
1:50

- NOTES
- ALL EXPOSED STRUCTURE (METAL DECK, JOIST, BEAMS) TO BE PAINTED (SEE SPECIFICATION FOR COLOUR)
 - ALL EXPOSED ELECTRICAL SERVICE AND MECHANICAL DUCTWORK TO BE PAINTED (SEE SPECIFICATION FOR COLOUR)
 - SEE ROOM A7.0 ROOM FINISH SCHEDULE
 - SEE ELECTRICAL E2.2 FOR CRAWLSPACE LIGHTING
 - SEE ELECTRICAL E4.1 FOR LUMINAIRE SCHEDULE

LIGHTING FIXTURE SCHEDULE

TYPE	COUNT	REMARKS
ELEVATED MAINTENANCE CATWALK		
F8	2	FLUORESCENT - MOUNTED ON WALL
EXTERIOR	3	BUILDING LIGHTING ON OUTRIGGERS
HARVEST STORAGE	2	FLUORESCENT
JANITOR	2	FLUORESCENT
MECHANICAL	3	FLUORESCENT
MULTI-PURPOSE ROOM 1	1	
EXIT	4	CEILING FAN
F1	12	WALL MOUNTED ABOVE DOOR
F6	4	GYMNASIUM JAM-JAR
MULTI-PURPOSE ROOM 2	1	
EXIT	2	WALL MOUNTED ABOVE DOOR
F6	18	JAM-JAR
SEVERITY	3	JAM-JAR (WALL MOUNT)
F3	4	FLUORESCENT
STORAGE	2	FLUORESCENT
F5	2	FLUORESCENT
UTR MEN	3	
F8	3	
UTR WOMEN	3	
F8	3	
VESTIBULE	5	JAM-JAR (WALL MOUNT)
F2	5	JAM-JAR (WALL MOUNT)
Grand total:	74	

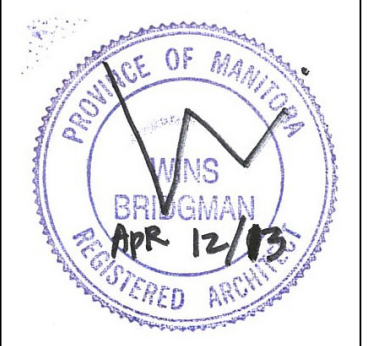

Project:
MAYFAIR RECREATION CENTRE
40 MAYFAIR PLACE
Project Number: 2011-112
Bid Opportunity Number: 556-2012
Drawing Title:
REFLECTED CEILING PLAN

#	Issue/Revision	Date
1	60% REVIEW	AUG 16 2012
2	90% REISSUE REVIEW	NOV 28 2012
3	99% REVIEW	MAR 6 2013
4	ISSUED FOR TENDER	APR 12 2013

Sheet No: A1.2

This drawing is property of the Architect and cannot be reproduced or used without the consent of the Architect. The contractor is responsible for checking and verifying all levels and dimensions and shall report all discrepancies to the Architect and obtain clarification prior to commencing work.