
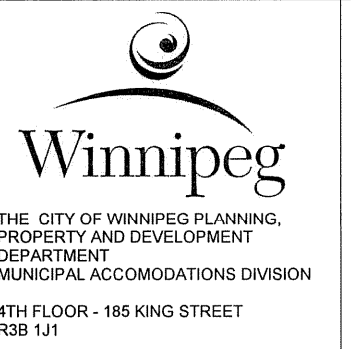
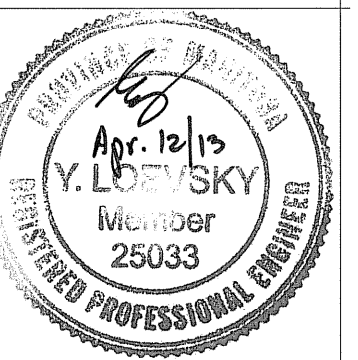


DRAWING NOTES:

1 LIGHT SWITCH LOCATED NEAR ACCESS HATCH IN MECHANICAL ROOM 110.

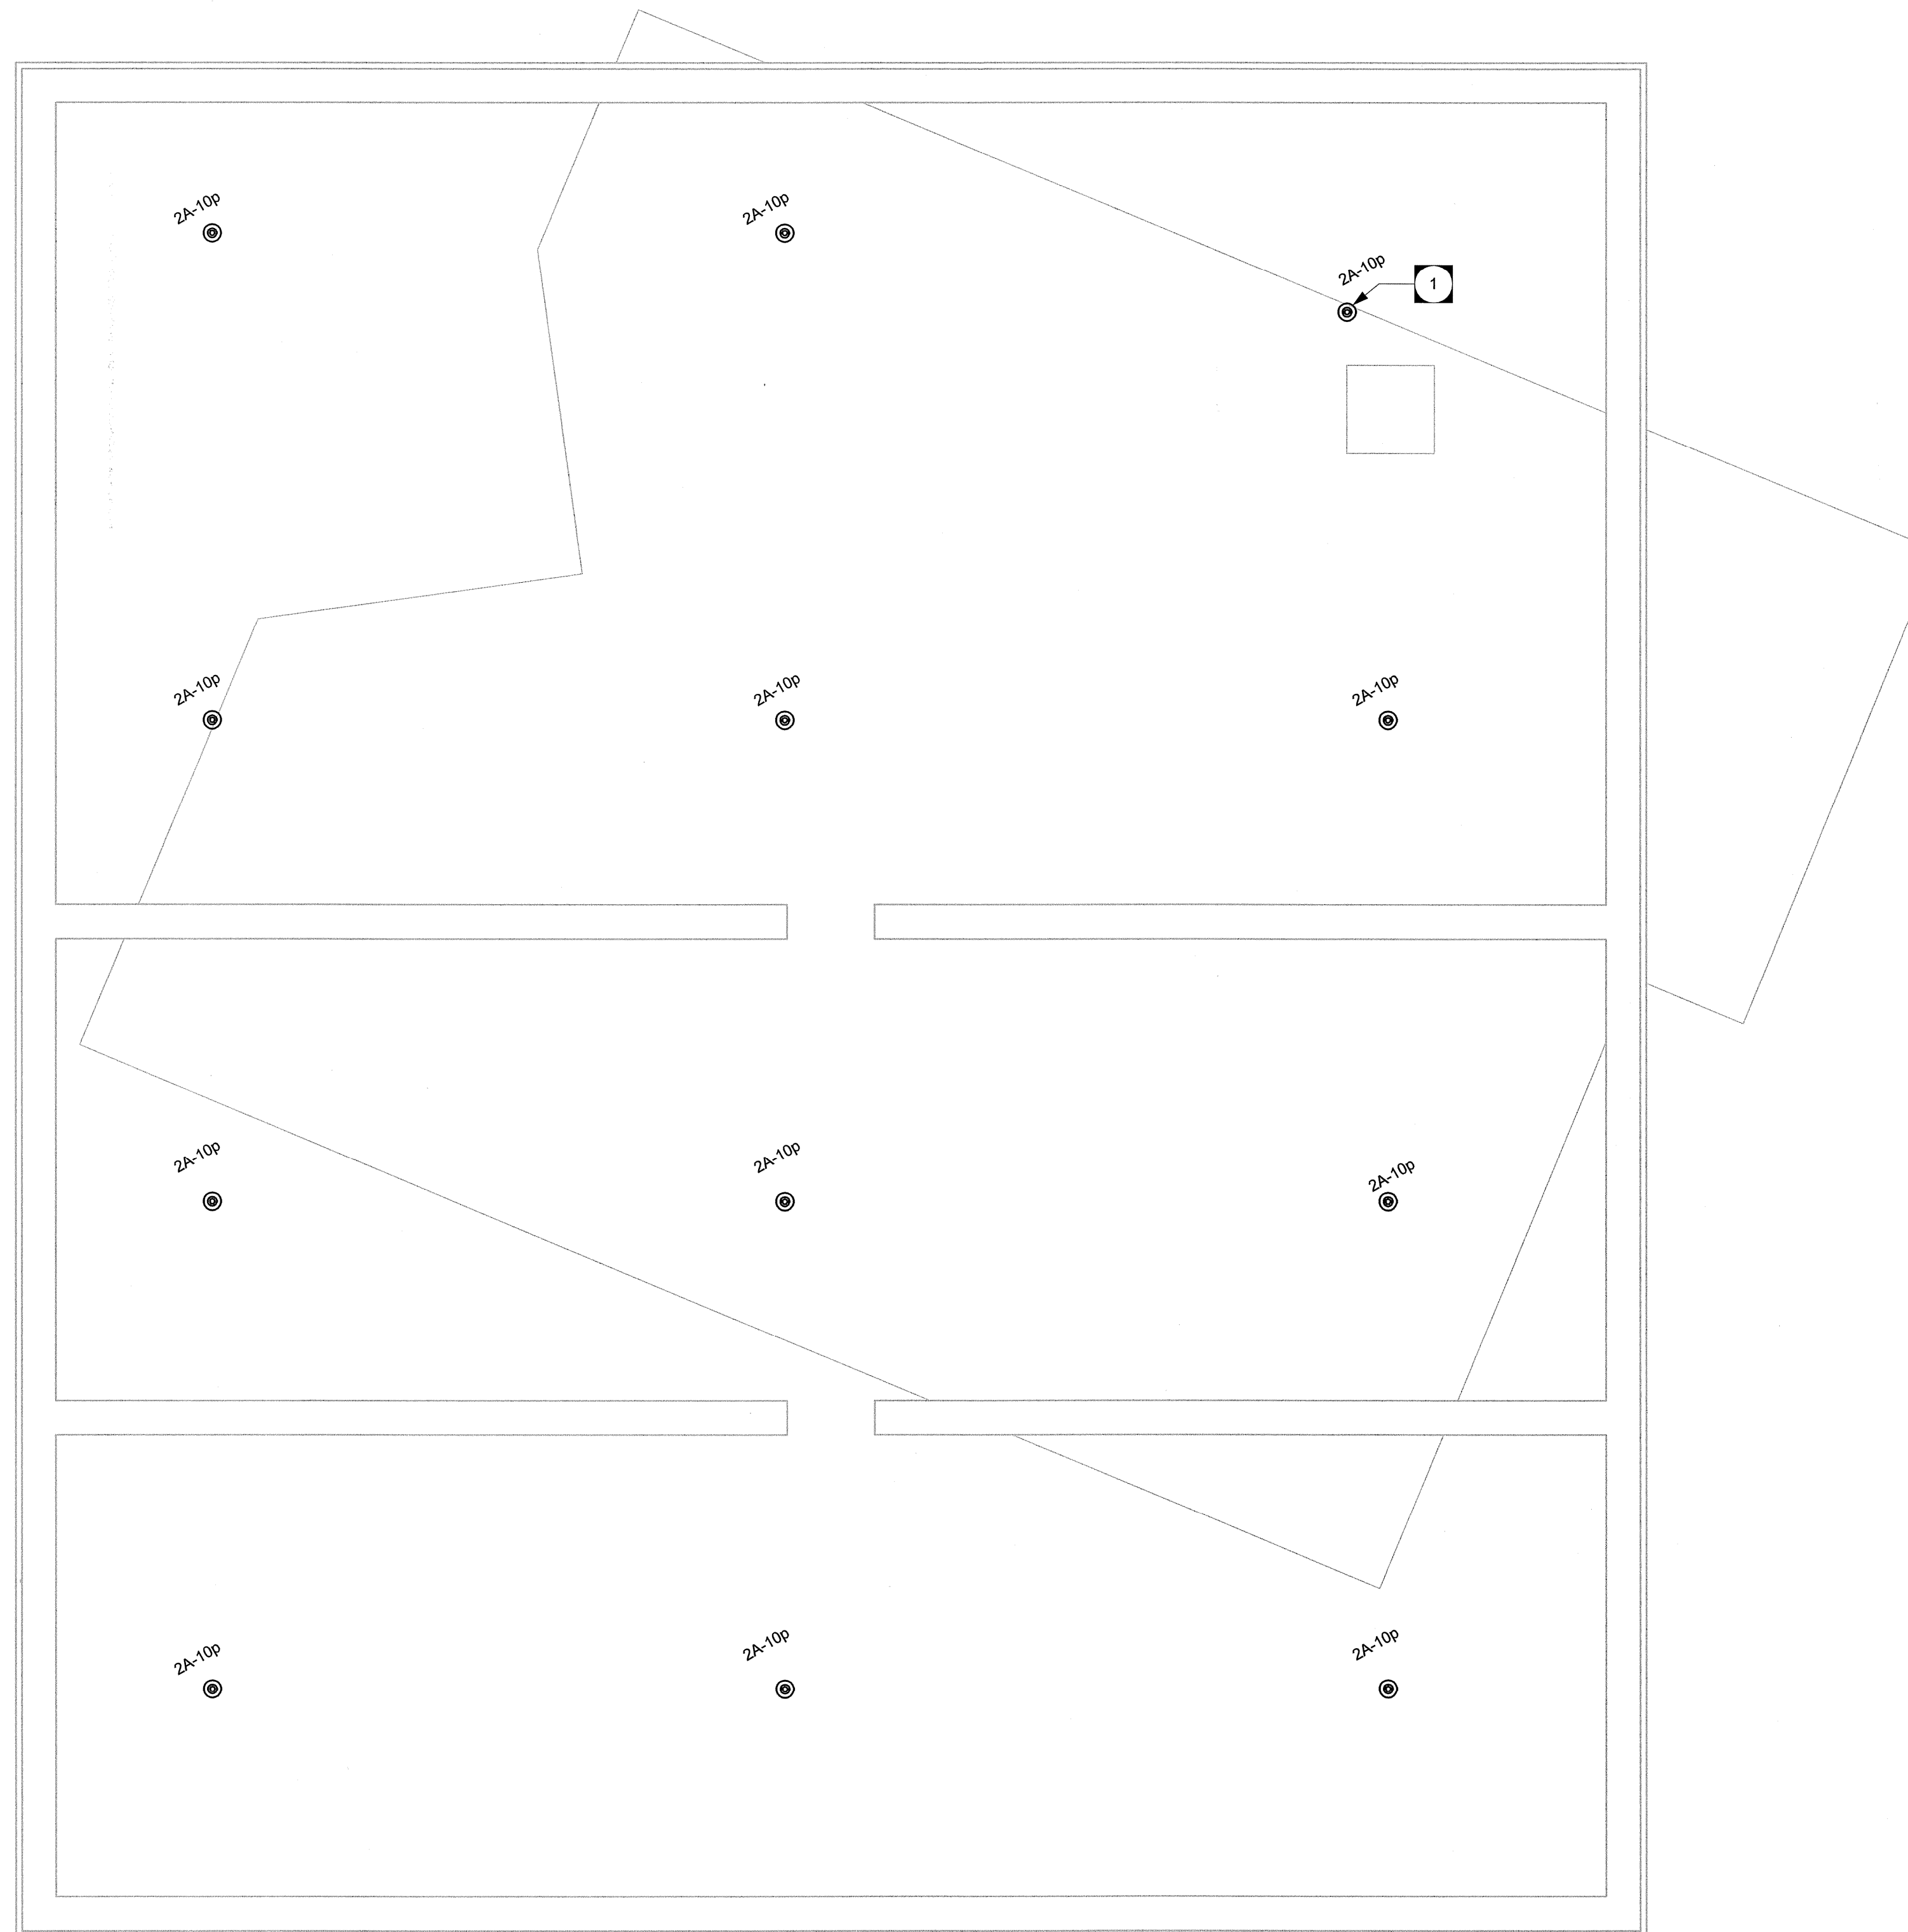

Project:
Mayfair Recreation Centre

Winnipeg, MB

Project Number: 12131
 Bid Opportunity Number: 556-2012

Drawing Title:
 ELECTRICAL LIGHTING LAYOUT-CRAWLSPACE

#	Issue/Revision	Date
1	60% REVIEW	2012-08-16
2	60% REVISION REVIEW	2012-11-26
3	70% REVIEW	2013-03-06
4	ISSUED FOR TENDER	2013-04-12