



D SIZE 22" x 34" (569mm x 864mm)

PLOT: 12/07/27 10:08:15 AM


AECOM REVIEW DRFT CHK
AECOM FILE NAME: 60221826-02-A-301-ROX.dwg Saved By: ccooperkl

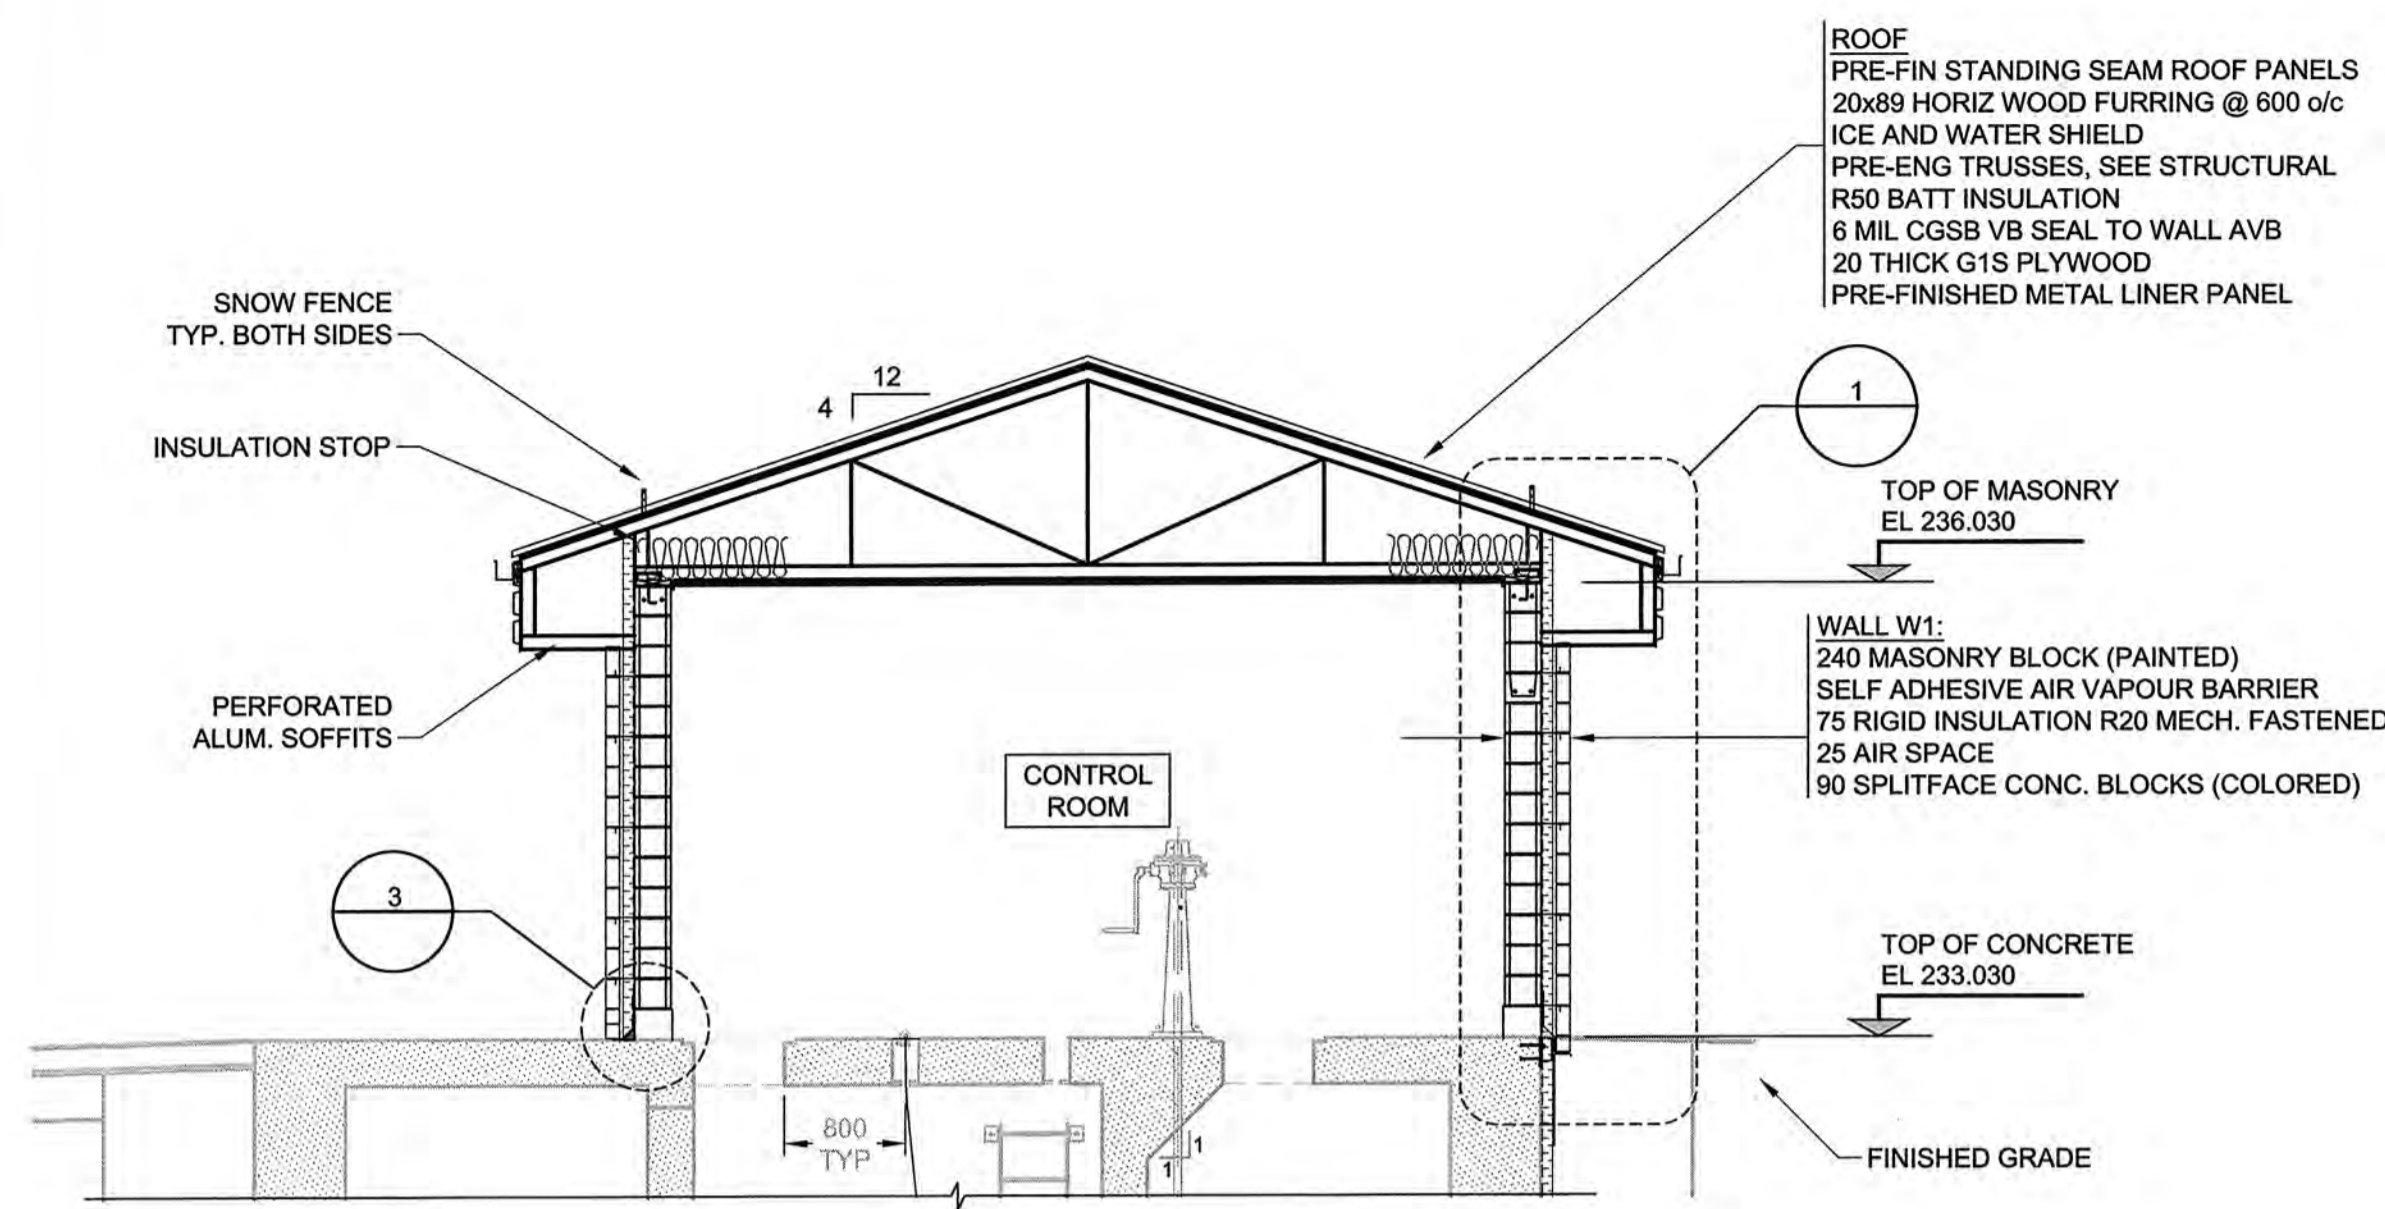


B SECTION
LD-5848 Scale 1:50

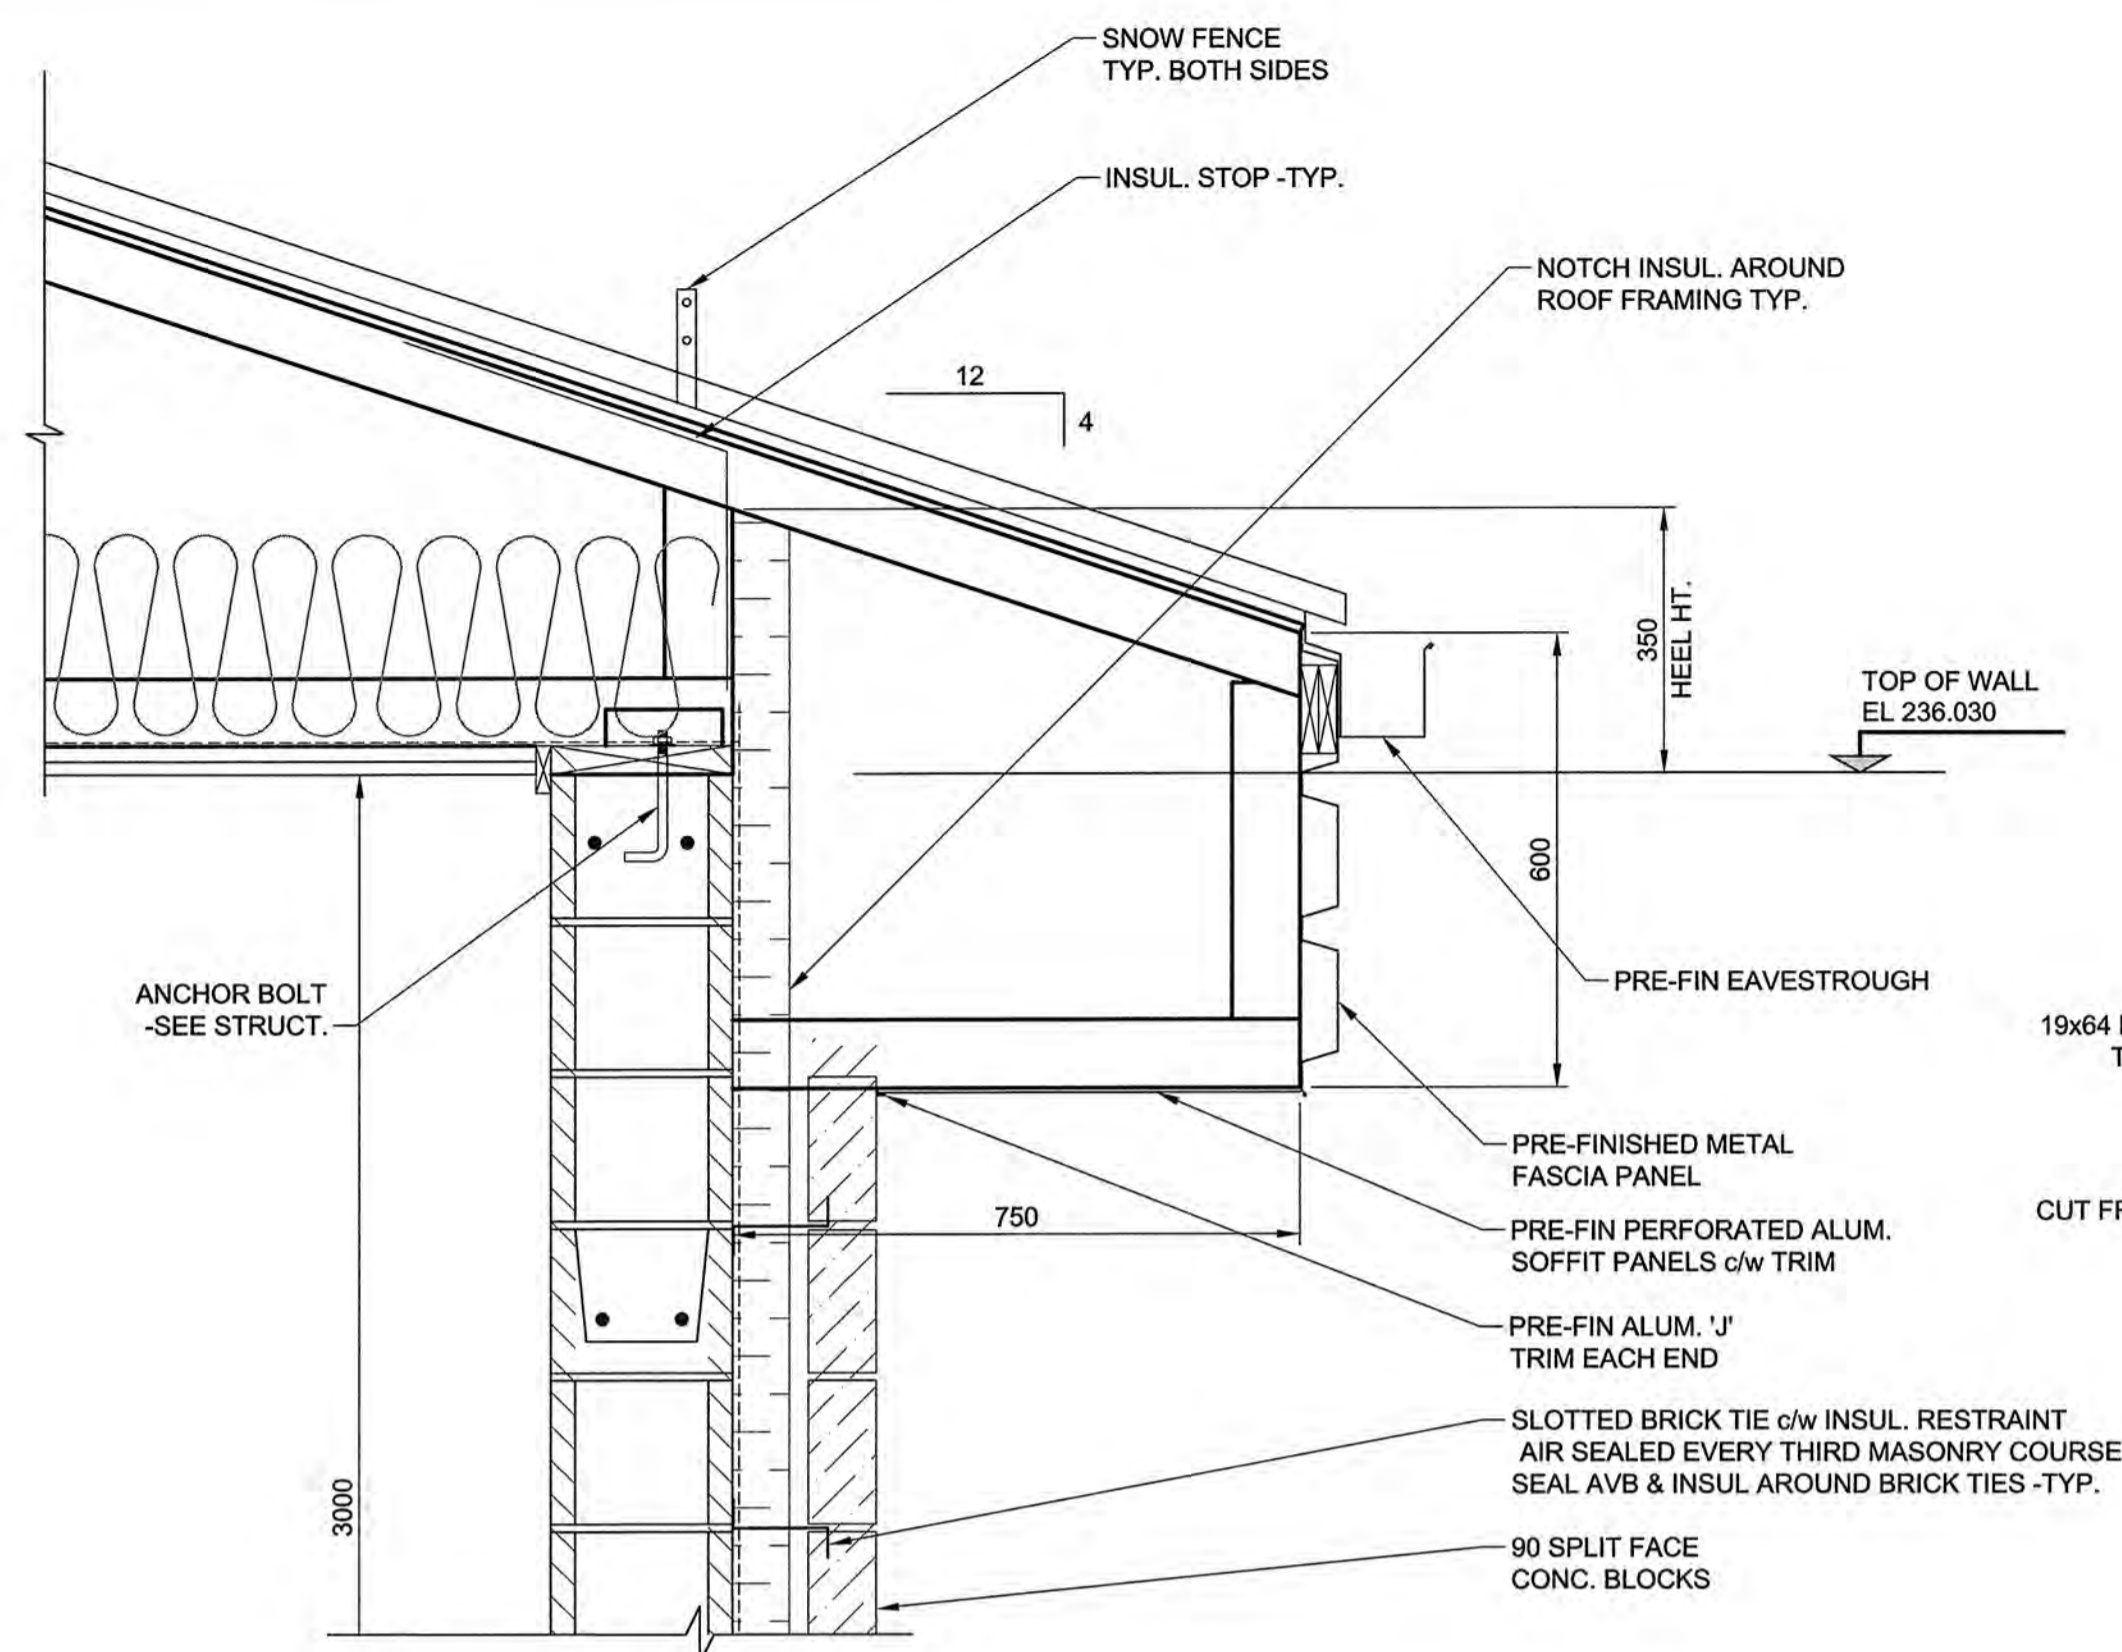


1 DETAIL
Scale 1:10

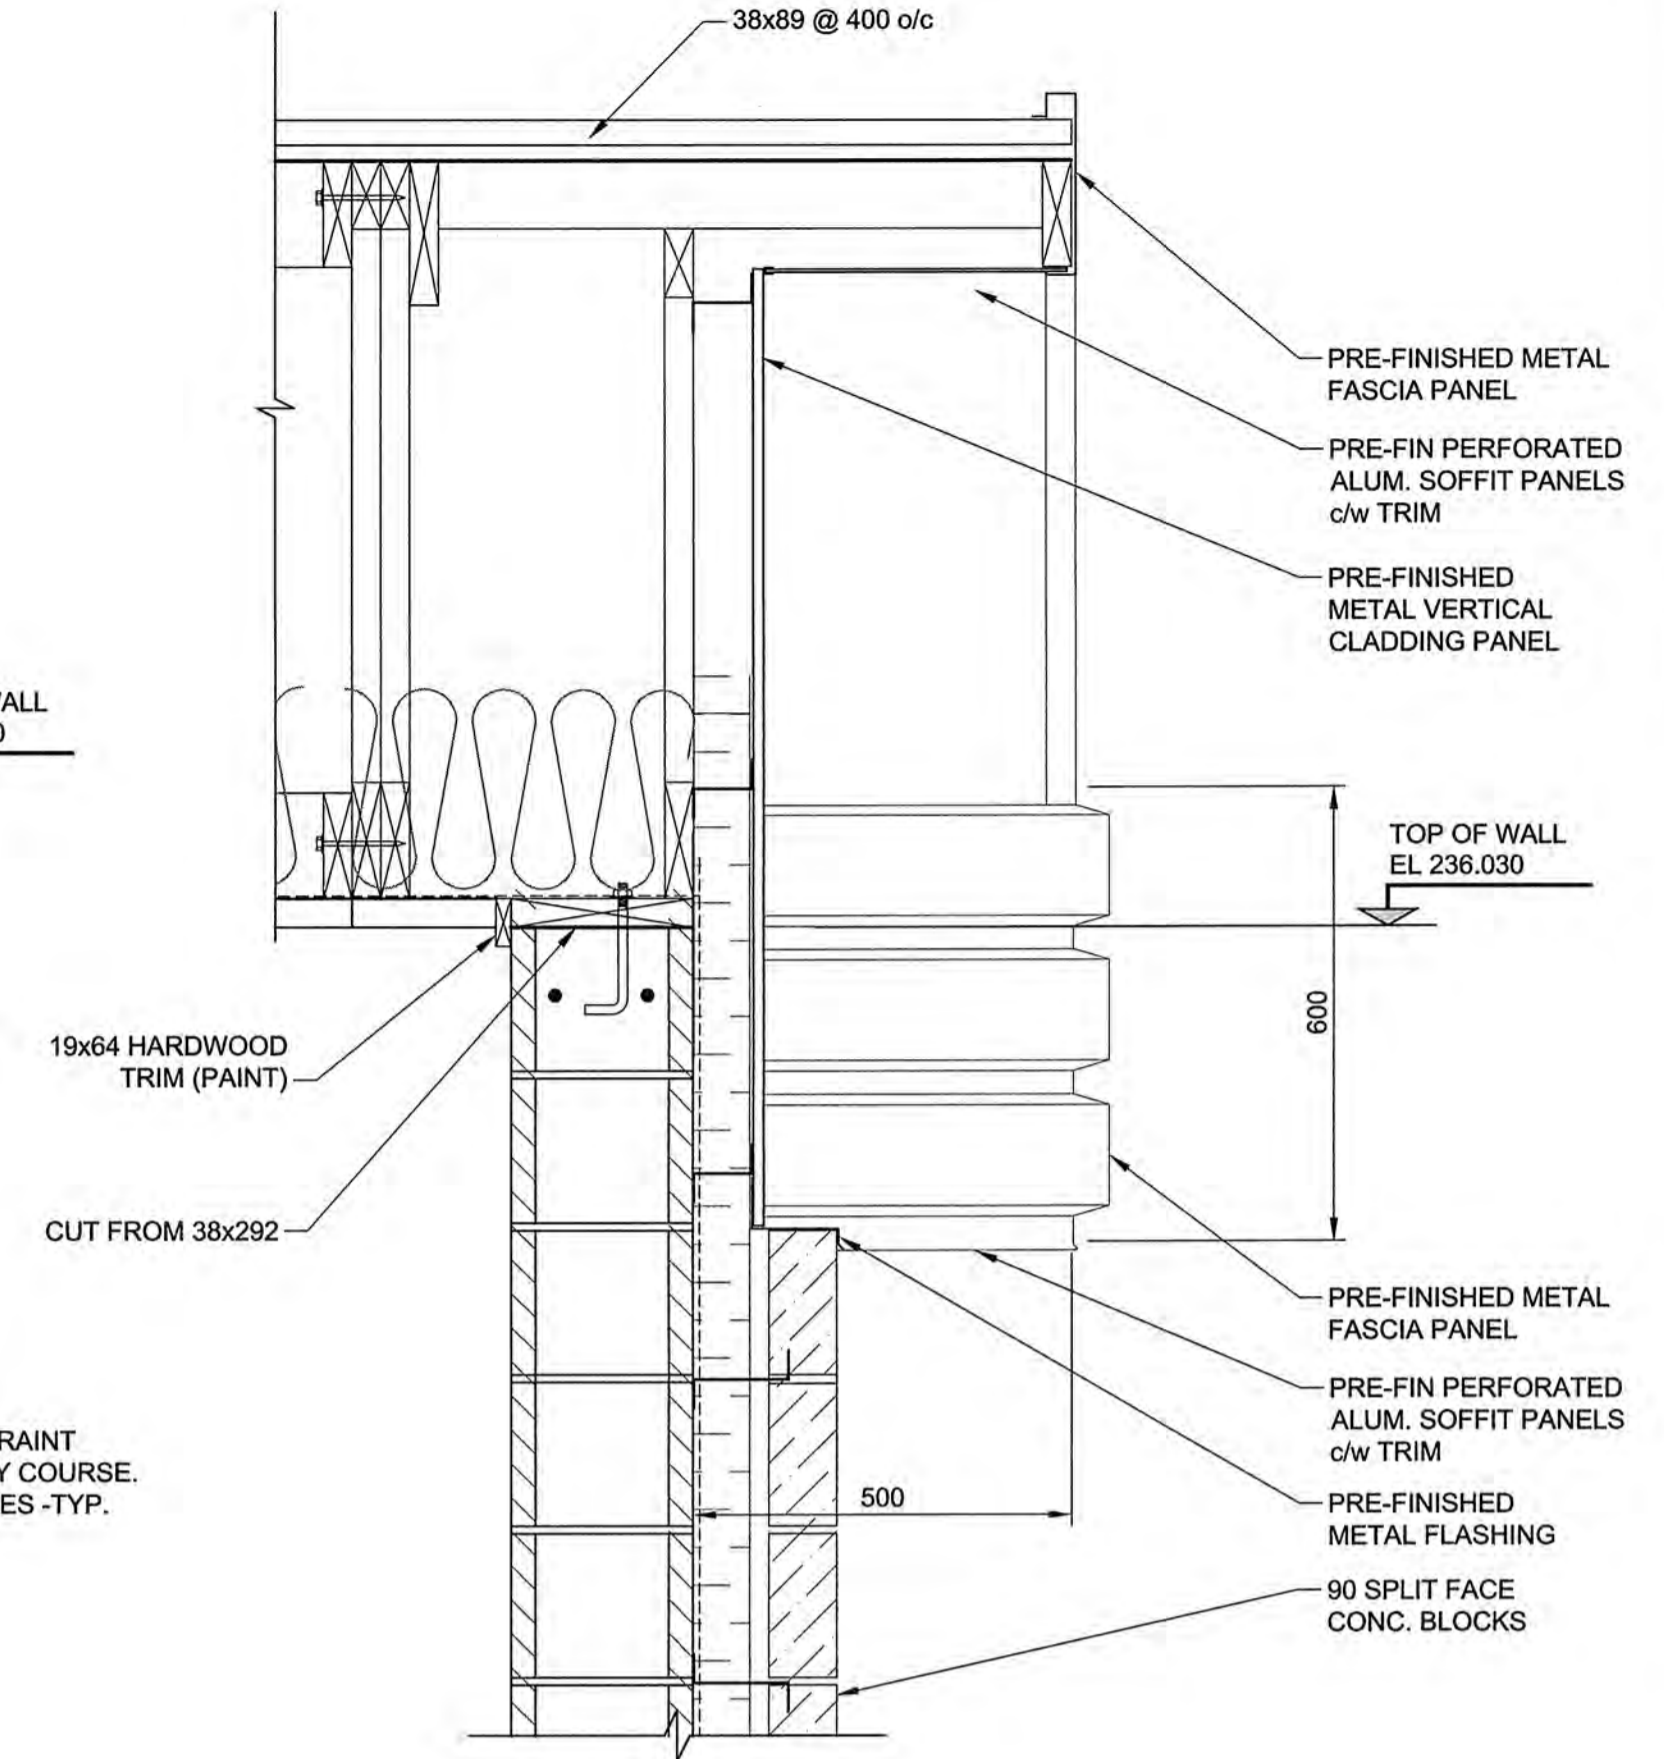

2 DETAIL
Scale 1:10

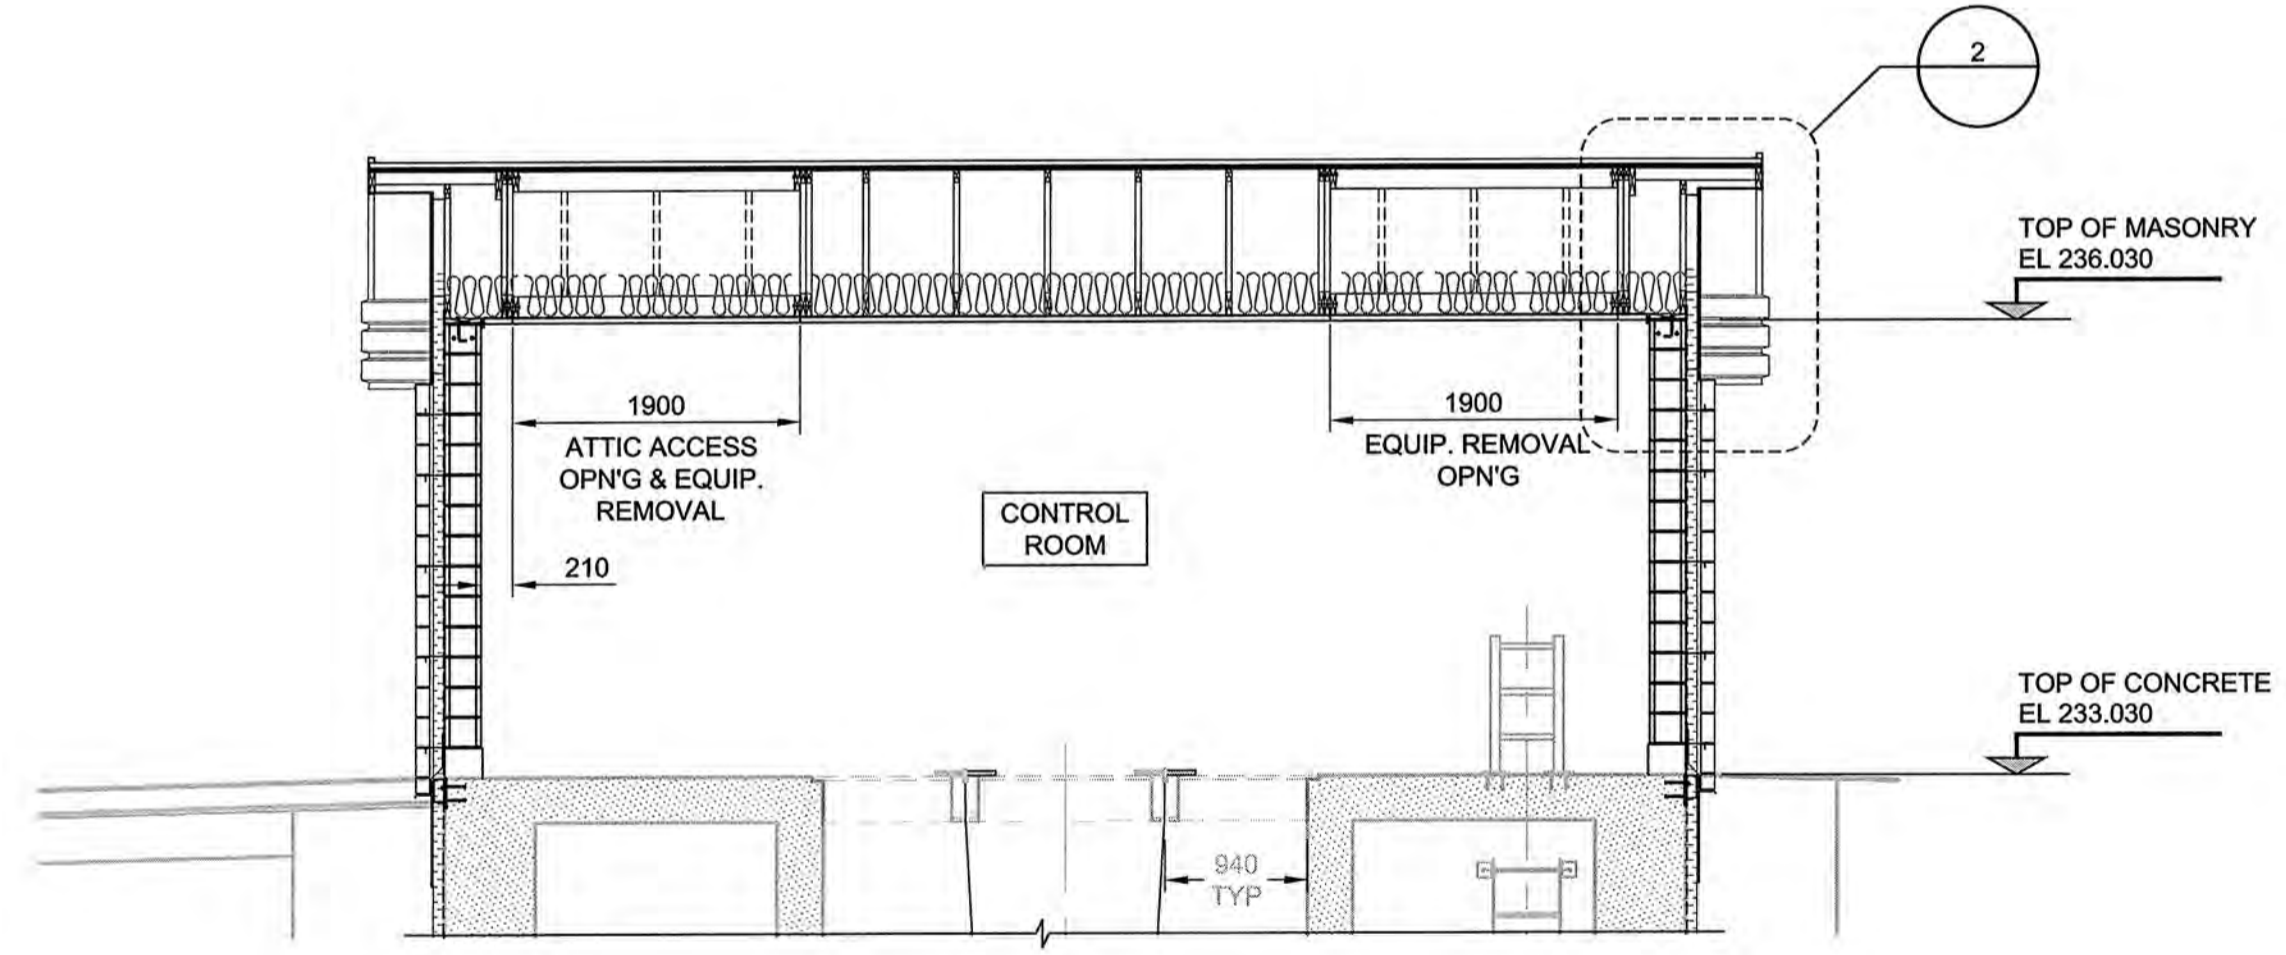

C SECTION
LD-5848 Scale 1:50

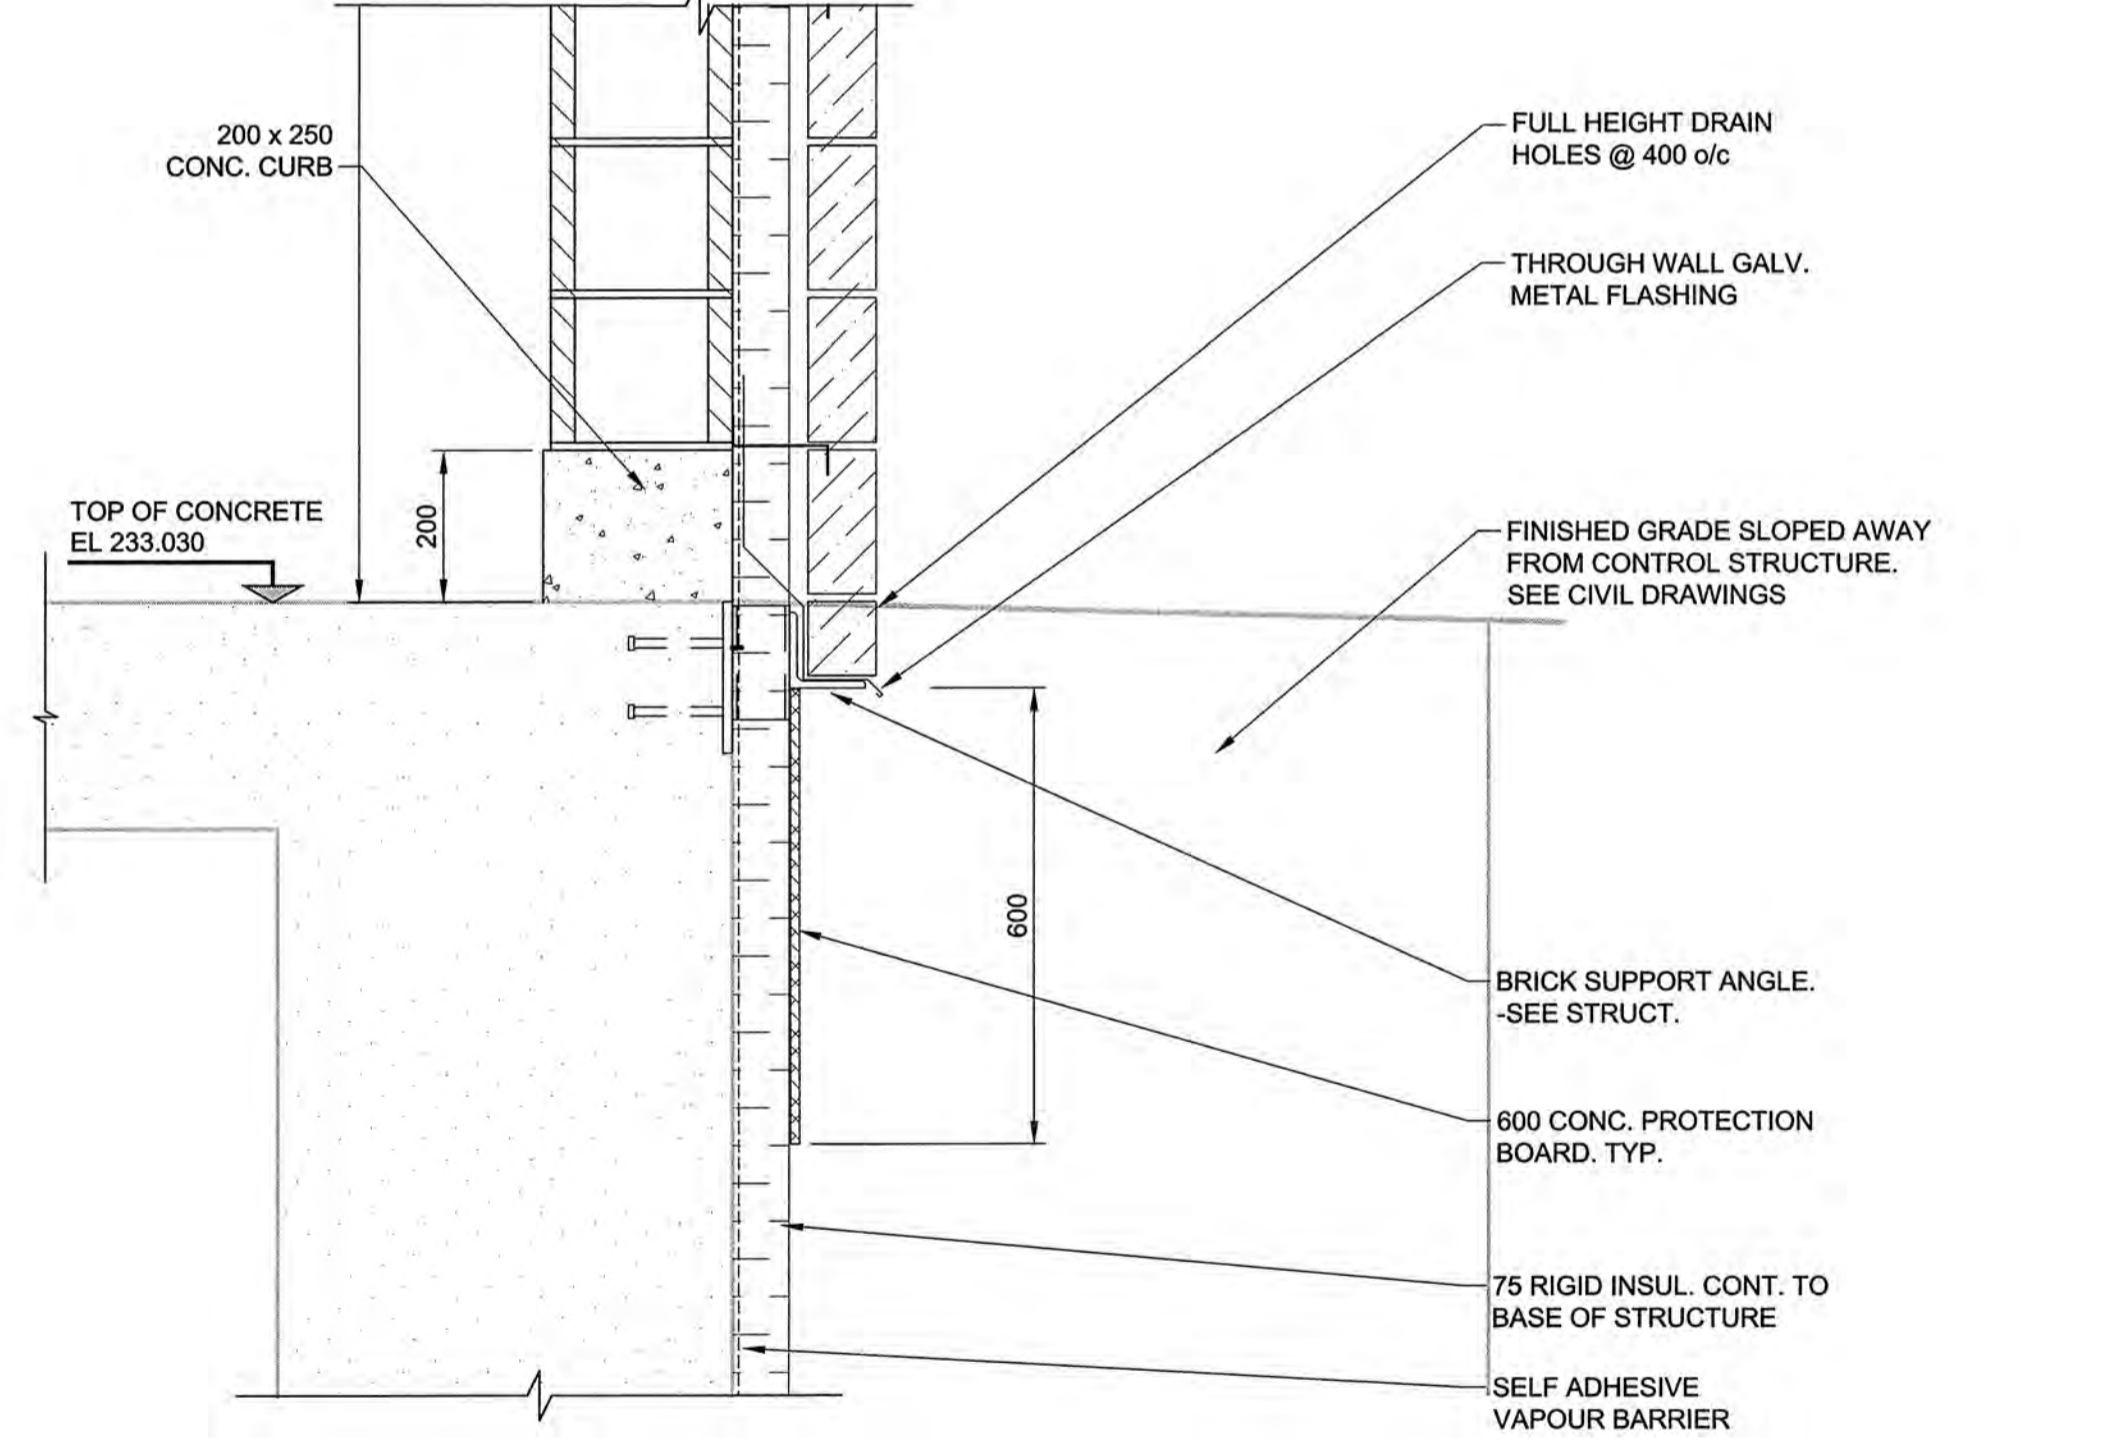

3 DETAIL
Scale 1:10

BID OPPORTUNITY NO. 587-2012

APECM
Certificate of Authorization
AECOM Canada Ltd.
No. 4671 Date: July 21, 2012

METRIC
WHOLE NUMBERS INDICATE MILLIMETRES
DECIMALIZED NUMBERS INDICATE METRES

DESIGNED BY	GGP	CHECKED BY	KK
DRAWN BY	DEP	APPROVED BY	<i>Byanalehben</i>
HOR. SCALE	AS SHOWN	RELEASED FOR CONSTRUCTION	
VERT. SCALE	N/A		
DATE	12/07/30	DATE	
NO.	ISSUED FOR CONSTRUCTION	12/07/27	DEP/KLC
NO.	REVISIONS	YYMMDD	BY

AECOM

PROFESSIONAL'S SEAL
PROVINCE OF MANITOBA
REGISTERED PROFESSIONAL ENGINEER
BISWANGER
2012/07/27

CONSULTANT DRAWING NO.
60221826-02-A-301-ROX.dwg

THE CITY OF WINNIPEG
WATER & WASTE DEPARTMENT

CONSTRUCTION OF FLOOD CONTROL STRUCTURE AT PEMBINA HIGHWAY & BEAUJOLAIS COULEE

ARCHITECTURAL
FLOOD CONTROL STRUCTURE
BUILDING AND WALL SECTIONS

SHEET 11 OF 19
CITY DRAWING NUMBER
LD-5850

REV 0