



**CRAWLSPACE & BASEMENT FLOOR PLAN - DEMOLITION - MECHANICAL**  
SCALE: 3/32"=1'-0"

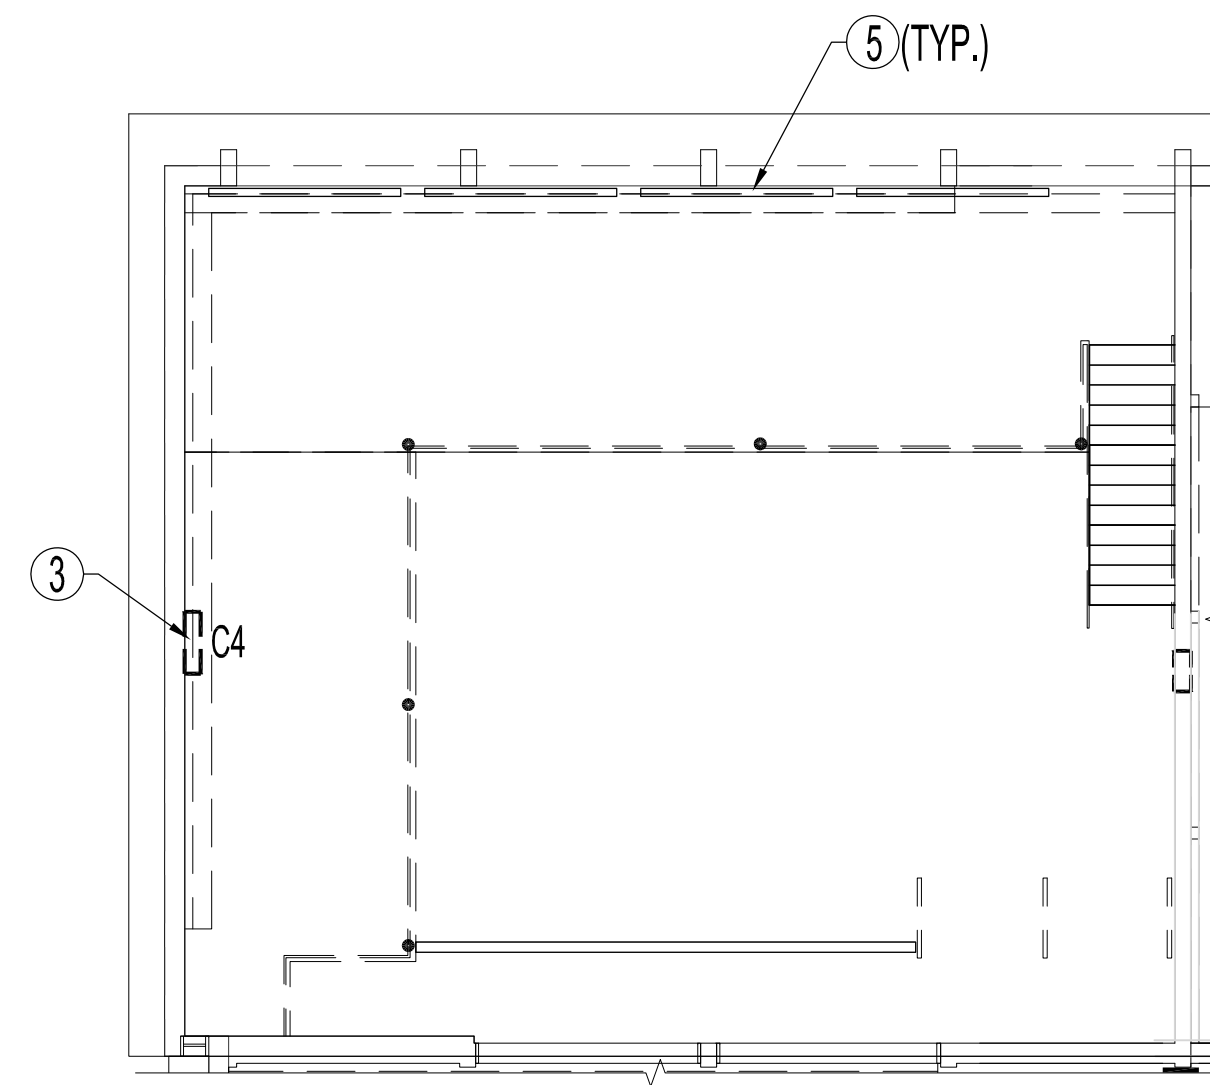

**MEZZANINE FLOOR PLAN - DEMOLITION - MECHANICAL**  
SCALE: 1/8"=1'-0"

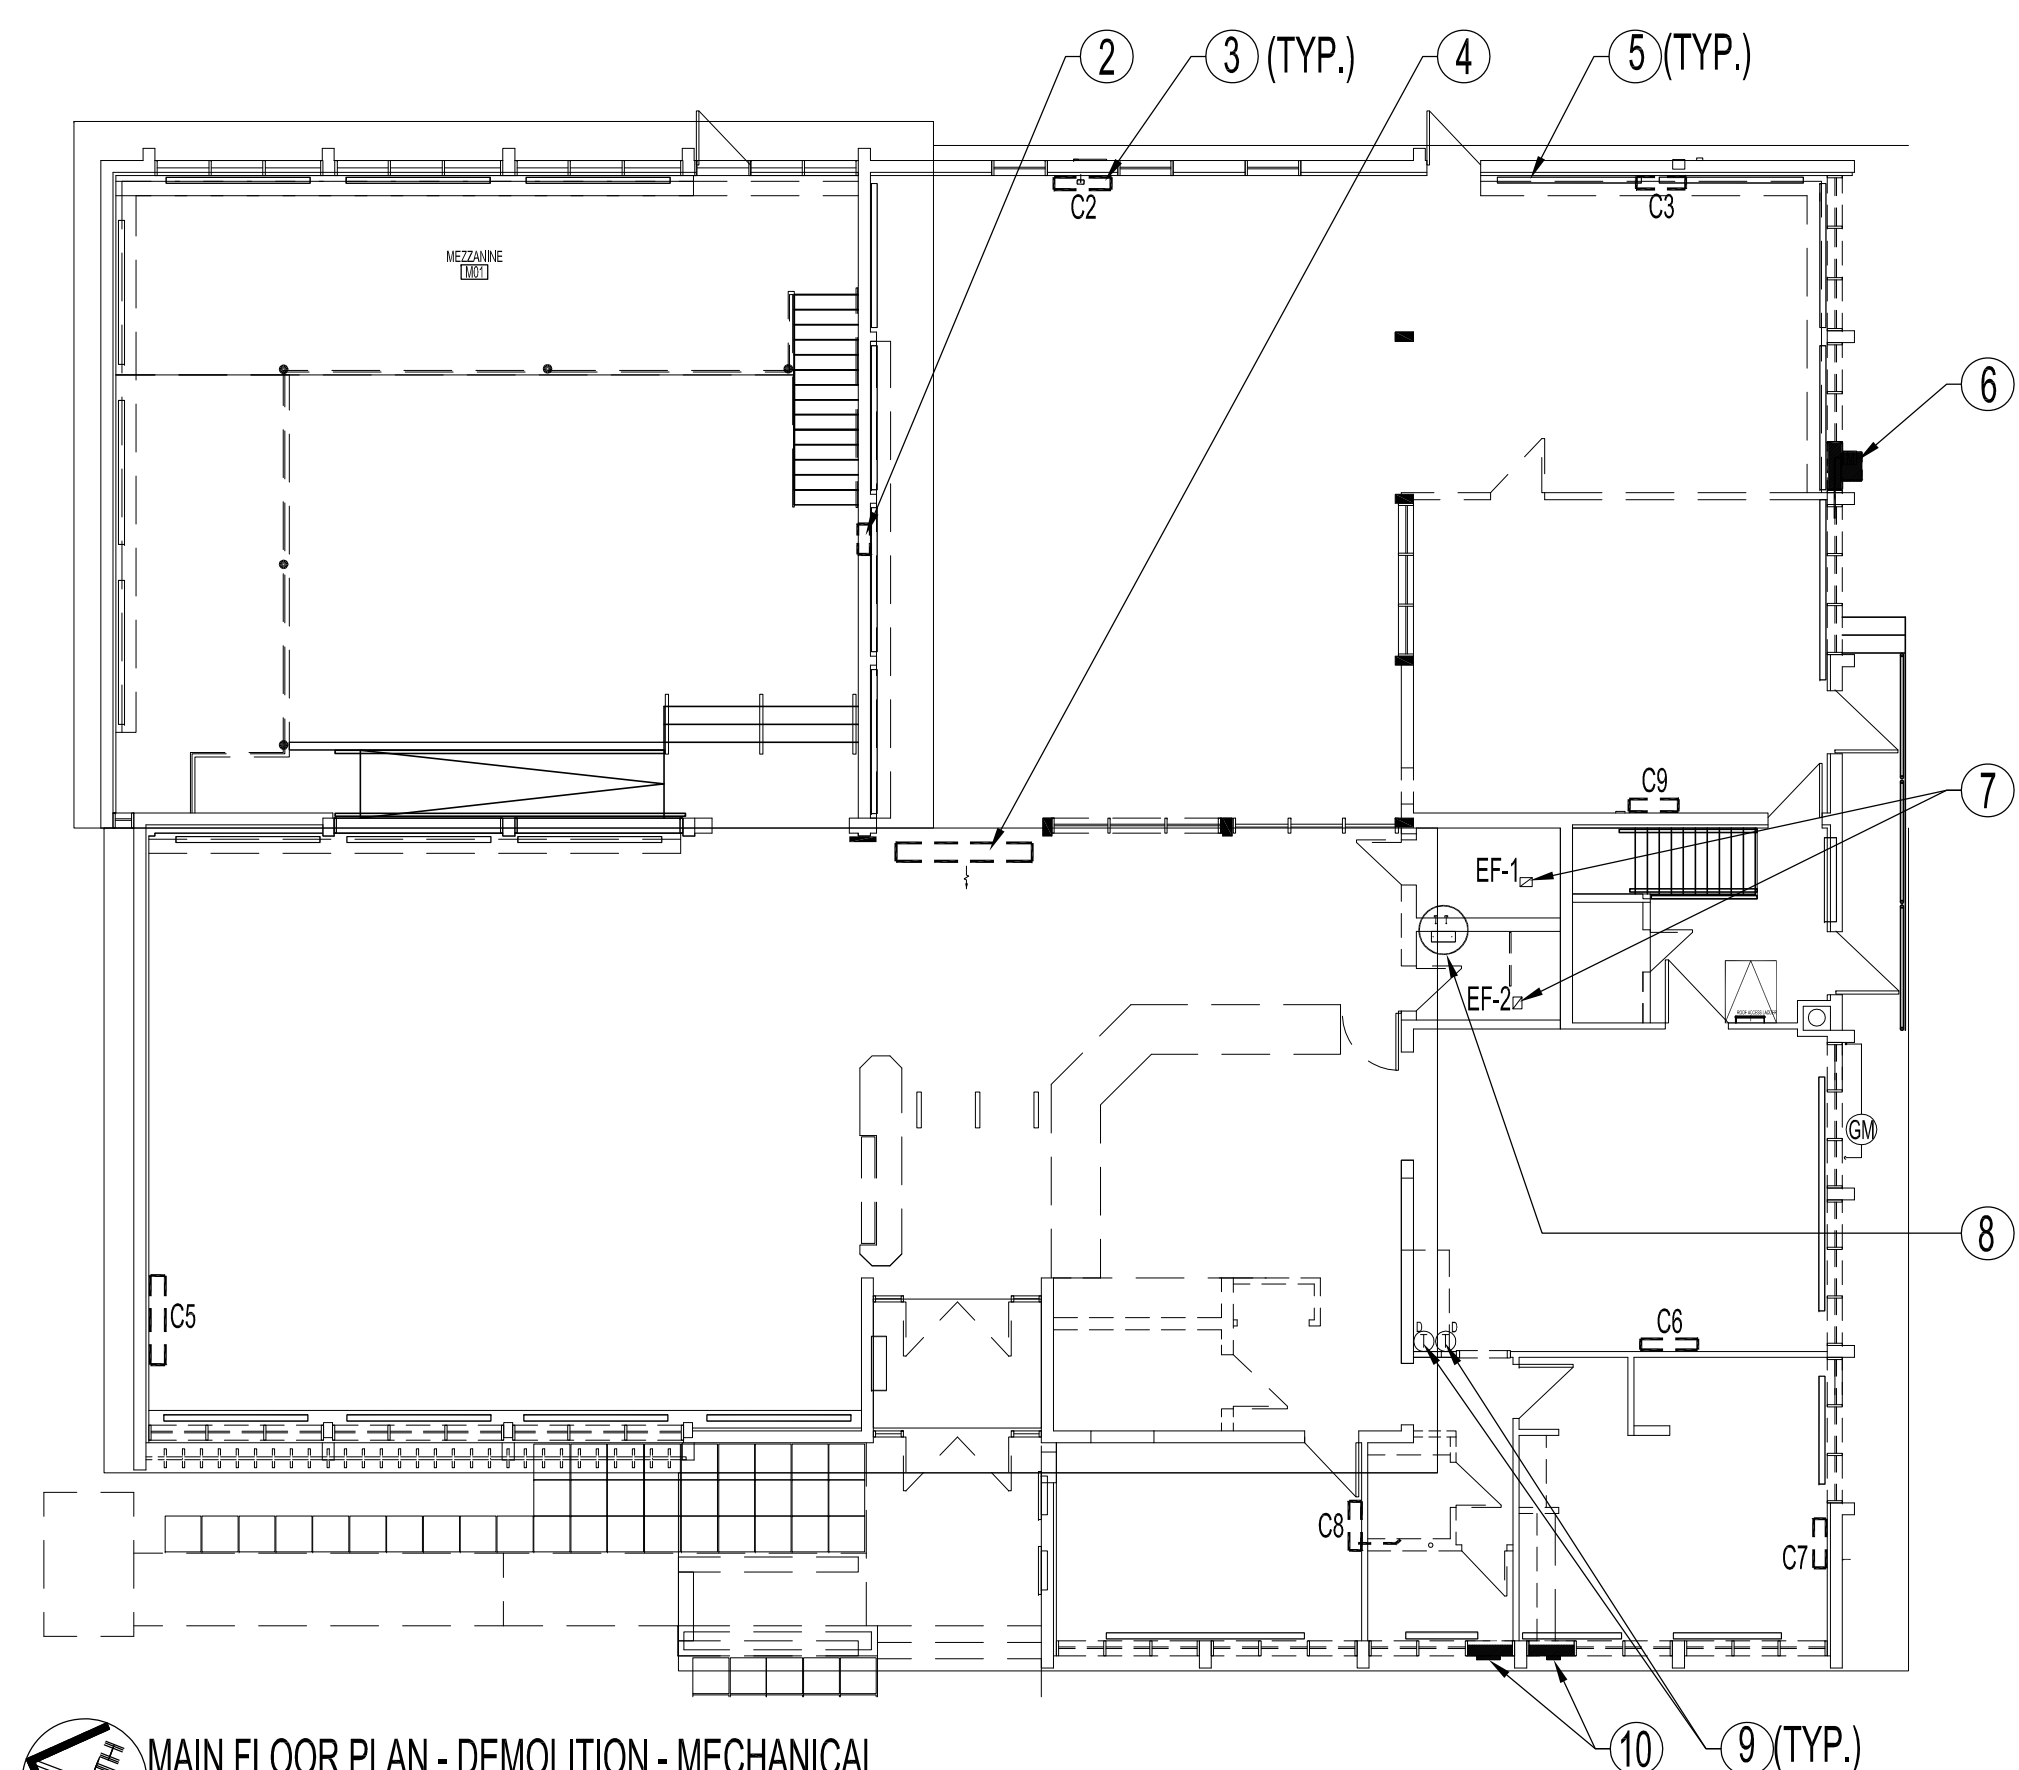

**MAIN FLOOR PLAN - DEMOLITION - MECHANICAL**  
SCALE: 3/32"=1'-0"

**DEMOLITION NOTES - MECHANICAL**

— EXISTING  
- - - TO BE DEMOLISHED.

- ① REMOVE & DISCARD RADIANT HOT WATER SUPPLY & RETURN LATERAL BRANCH PIPING & RISERS FROM BASEMENT TO MAIN FLOOR MEN'S & PREVIOUS WOMEN'S WASHROOM RADIATOR HEAT FIN TUBES. CAP AT BASEMENT MAIN SUPPLY & RETURN LINES.  
**NOTE:** FLUSH CUTTING LINES WITHIN FLOORS & WALLS IS NOT ACCEPTABLE.
- ② REMOVE & DISCARD IN-WALL DUCTWORK, GRILLE & HOUSING. RE-USE EXISTING WALL OPENING FOR NEW RETURN GRILLE AND DUCTWORK.
- ③ DECOMMISSION, REMOVE, DISCARD & REPLACE (8) WALL MOUNTED EVAPORATORS, REFRIGERATION & CONDENSATE DRAIN LINES. CONTRACTOR TO REMOVE, RETAIN & RE-INSTALL EXISTING EXTERIOR PROTECTIVE EXTERIOR SHROUDS TO ACCESS REFRIGERANT, ELECTRICAL & CONDENSATE DRAIN LINES FROM EXTERIOR SIDE.
- ④ REMOVE, DISCARD & REPLACE (3) INTERIOR SIDE WALL GRILLES & DUCT WORK TO EXISTING ROOF TOP MAKE-UP AIR UNIT.
- ⑤ EXISTING RADIATOR FIN TUBES. SEE MECHANICAL SYMBOL SCHEDULE.
- ⑥ DISCONNECT, REMOVE & DISCARD IN-WALL RELIEF AIR DAMPER ASSEMBLY INCLUDING WIRING & SUPPORTS TO ROOF TOP MAKE-UP AIR UNIT.
- ⑦ REMOVE & DISCARD MEN'S & WOMEN'S WASHROOM CEILING EXHAUST FANS (EF-1 & EF-2) AND ALL ABOVE CEILING CONNECTED DUCTWORK.
- ⑧ DE-COMMISSION, REMOVE & DISCARD EXISTING RADIANT HEAT FIN-TUBE & ASSOCIATED SUPPLY & RETURN PIPING. ALSO SEE CRAWLSPACE & BASEMENT MECHANICAL DEMOLITION NOTES.
- ⑨ DISCONNECT, REMOVE & DISCARD (2) AIR CONDITIONING EVAPORATOR DIGITAL THERMOSTATS. REMOVE WIRING BACK TO SOURCES.
- ⑩ REMOVE & DISCARD STAFF LOUNGE & WASHROOM SIDE WALL EXHAUST FANS (EF-3 & EF-4) AND CONNECTED DUCTWORK.

**NOTES:**

ALSO SEE ARCHITECTURAL, ROOF & ELECTRICAL DWGS & NOTES.

No.	REVISION/DESCRIPTION	BY	DATE
SEAL			

DRAWN	RCP	CHECKED	DTA	DESIGNED	DTA	APPROVED
DATE	2012.08.17	USER	APPROVAL			

**THE CITY OF WINNIPEG**  
PLANNING, PROPERTY AND  
DEVELOPMENT DEPARTMENT  
MUNICIPAL ACCOMMODATIONS DIVISION  
3-65 GARRY STREET, R3C 4K4

**PROJECT**  
FORT GARRY LIBRARY  
INTERIOR & EXTERIOR REFURBISHING

1360 PEMBINA HWY

**SHEET TITLE**  
CRAWLSPACE, BASEMENT, MAIN & MEZZANINE FLOOR PLAN  
DEMOLITION  
MECHANICAL

SCALE	PROJECT No:	SHEET No:
AS SHOWN	2011-096	M3