






D SIZE 22" x 34" (559mm x 864mm)

PLOT: 9/20/2012 3:37:34 PM

AECOM FILE NAME: 60163046-01-C-101-ROX.dwg Saved By: demoudeau

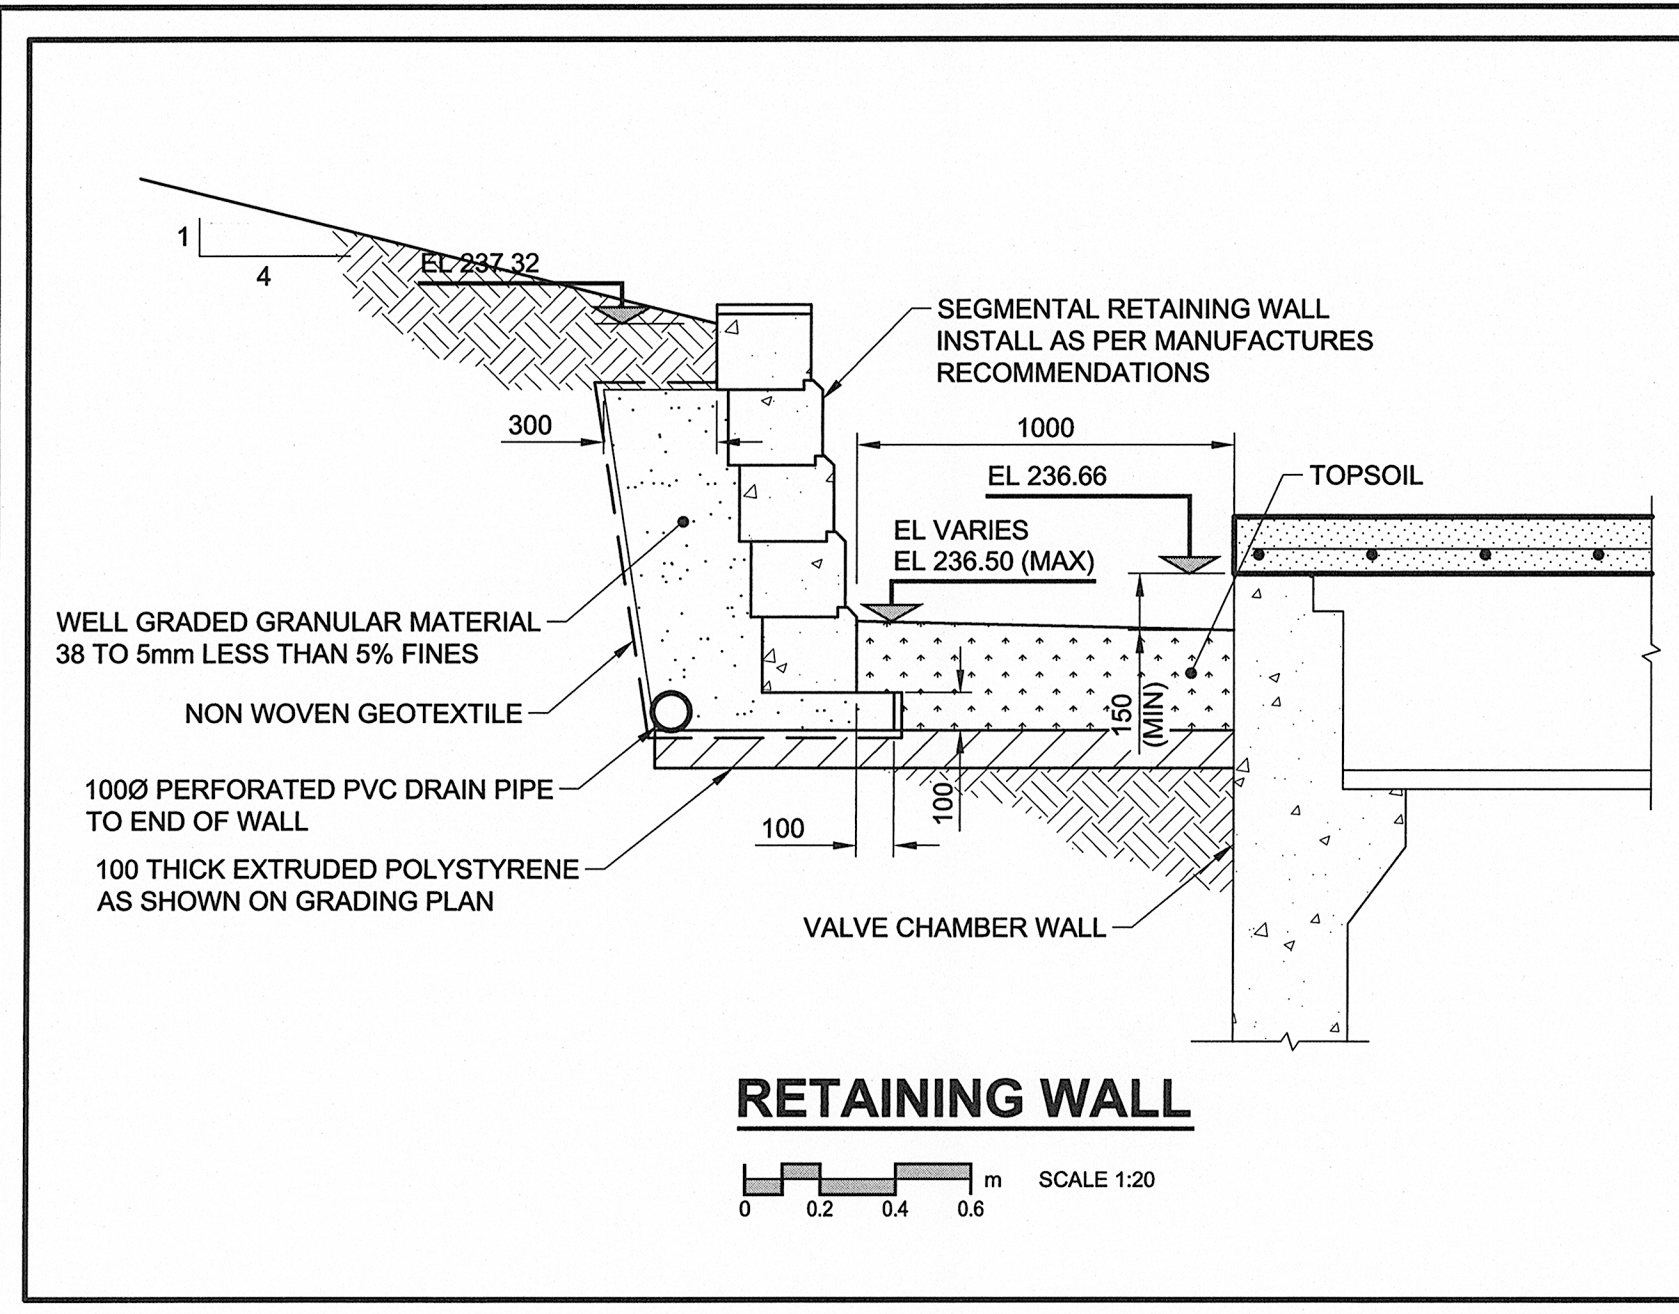

NOTE:
- LOCATE EXISTING BURIED SCADA CABLE & EXISTING ELECTRICAL CABLE PRIOR TO EXCAVATION AT CHAMBER FV-Y304A & AT THE EAST CHLORINE CONTACT CHAMBER

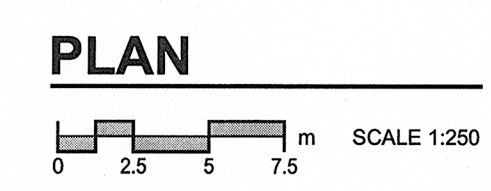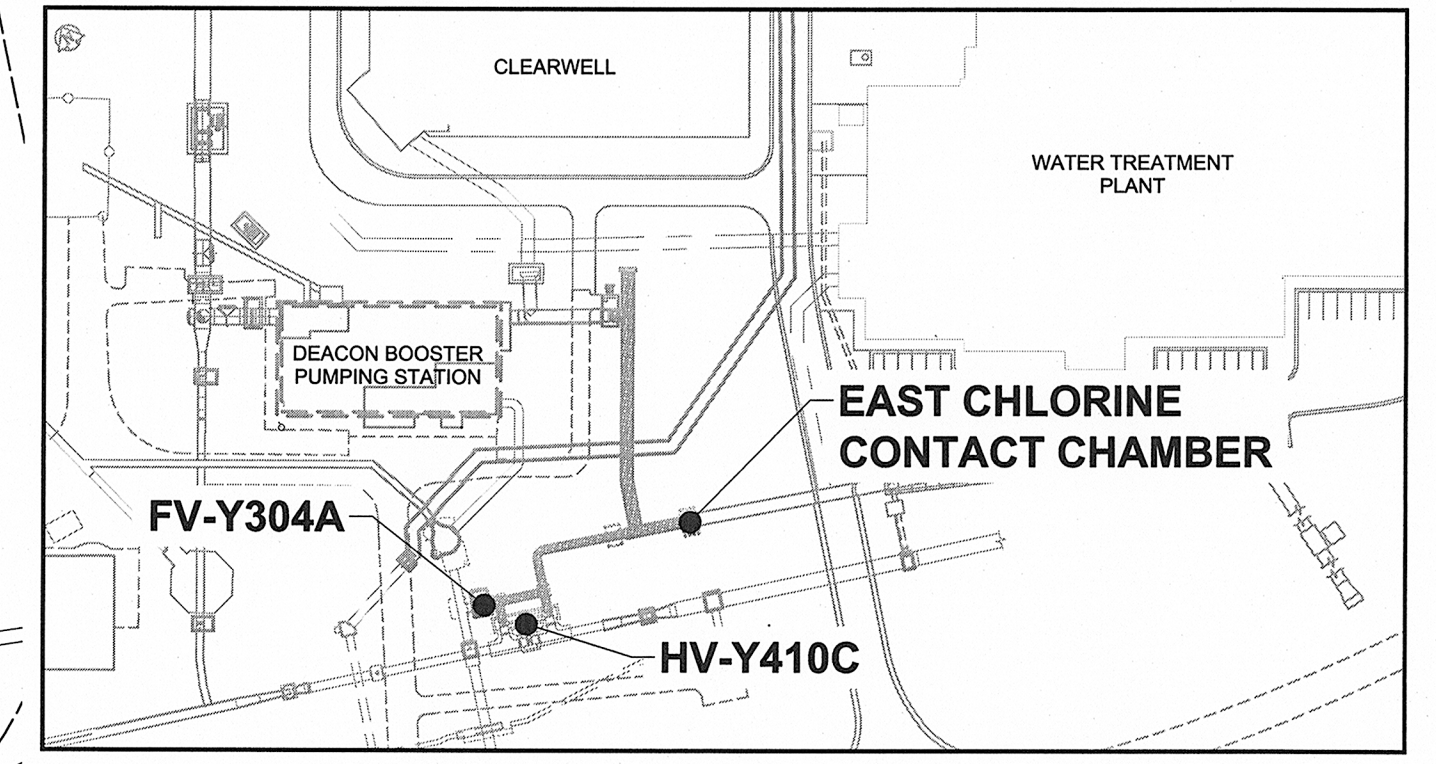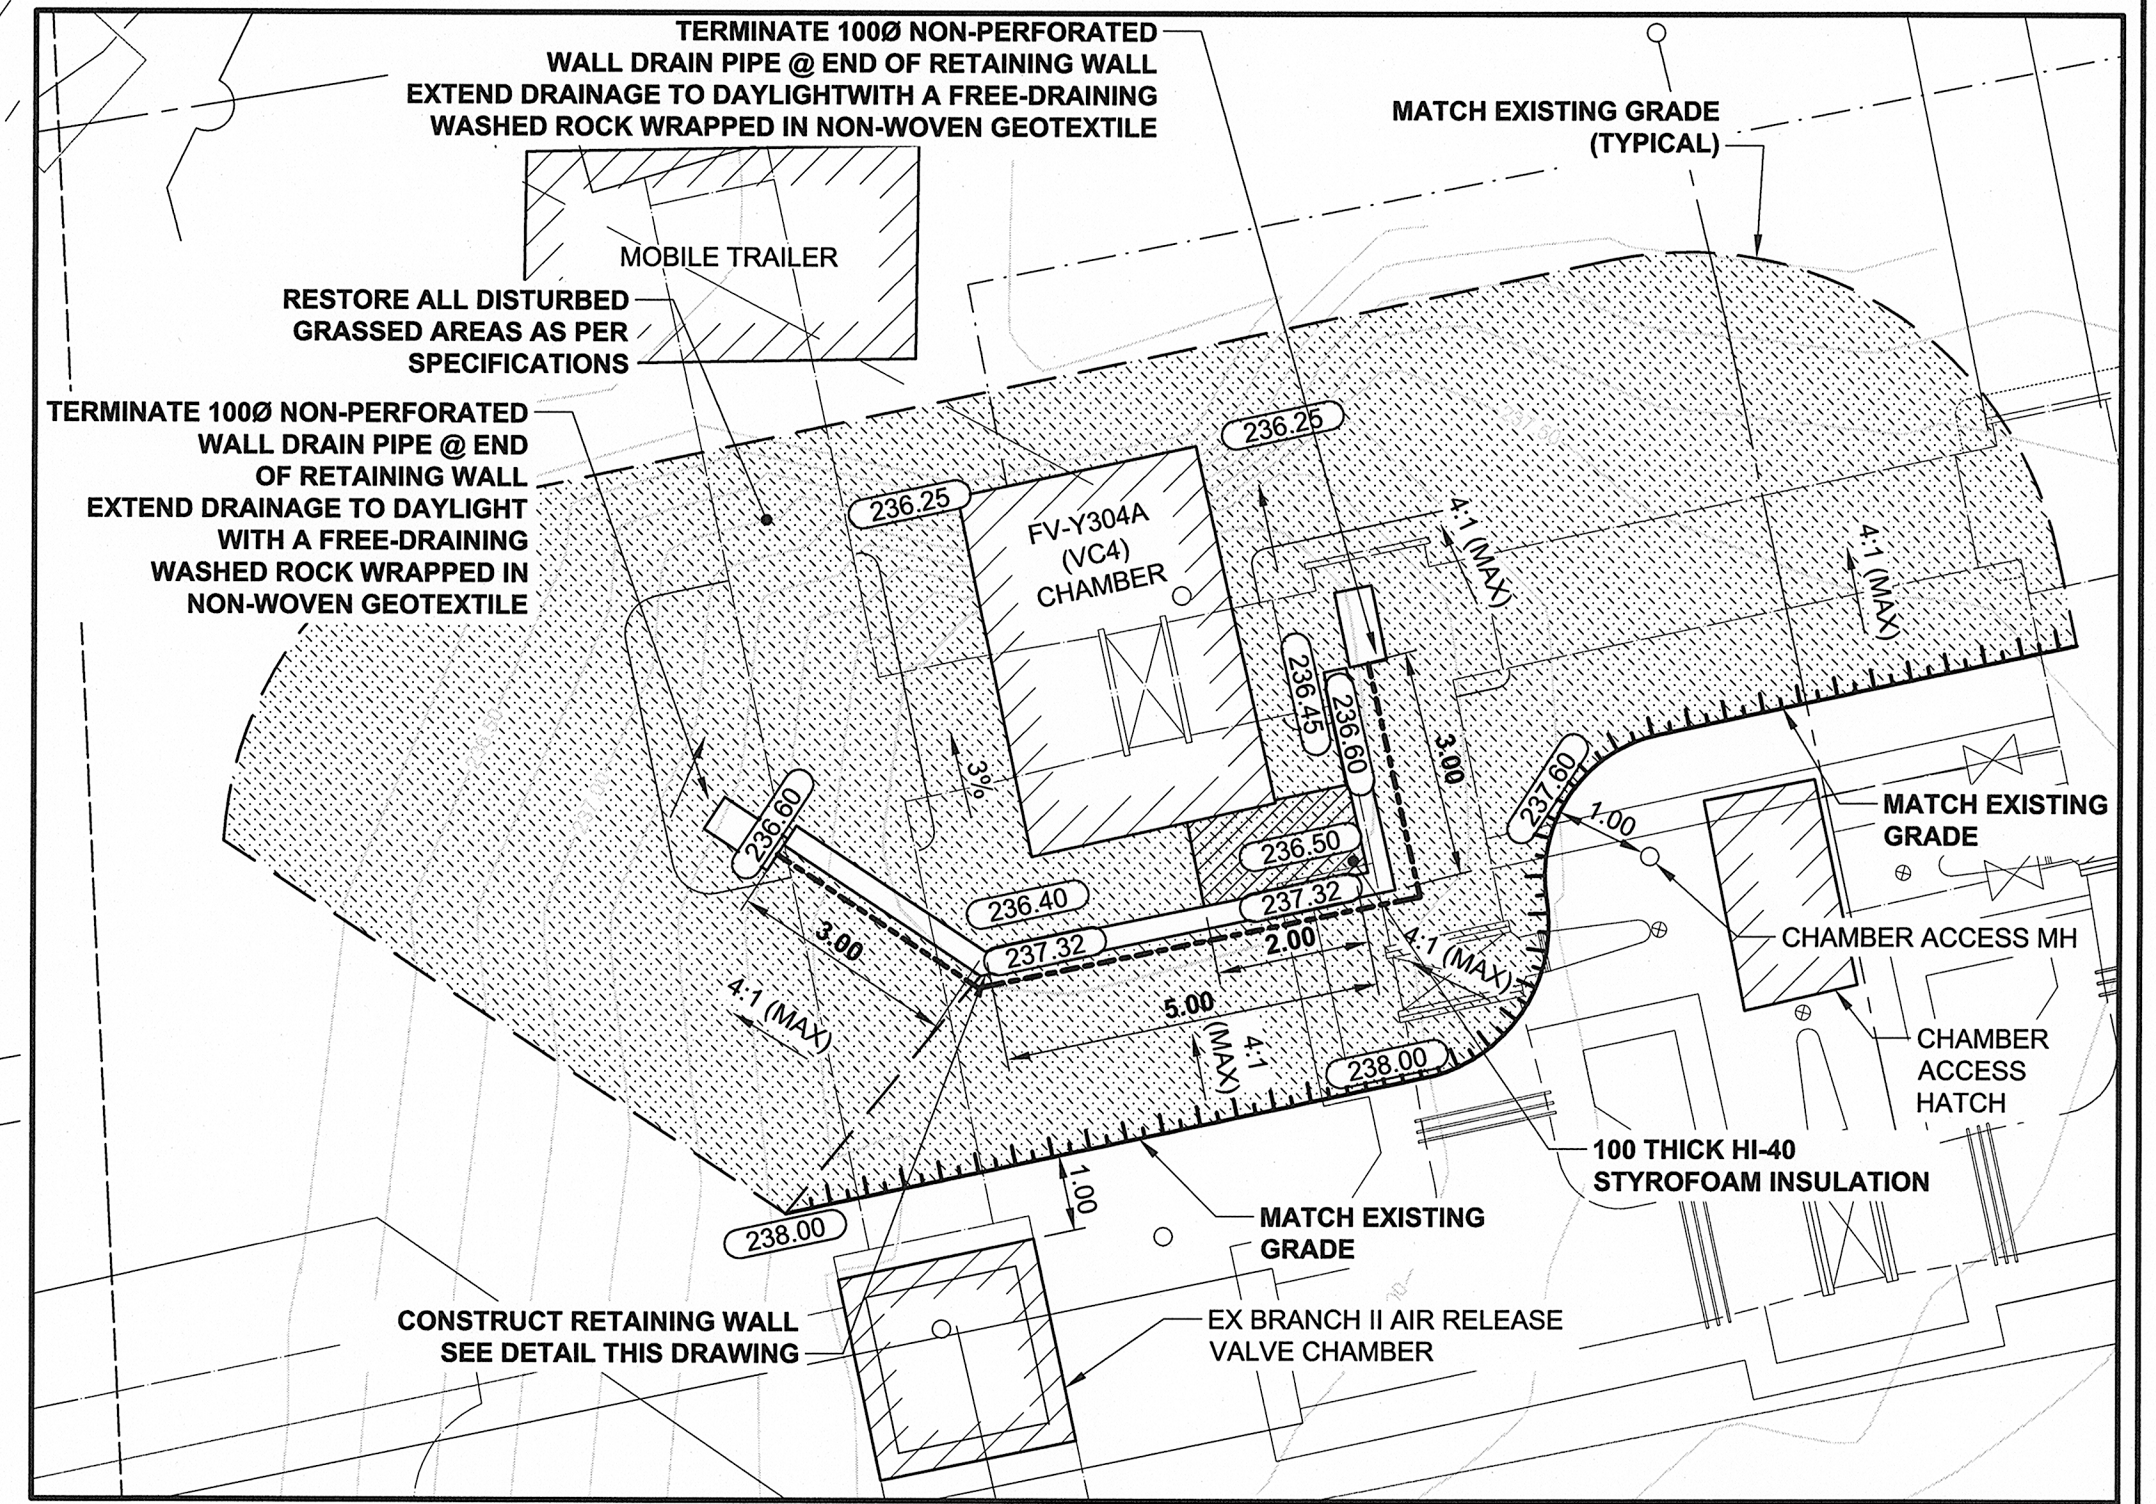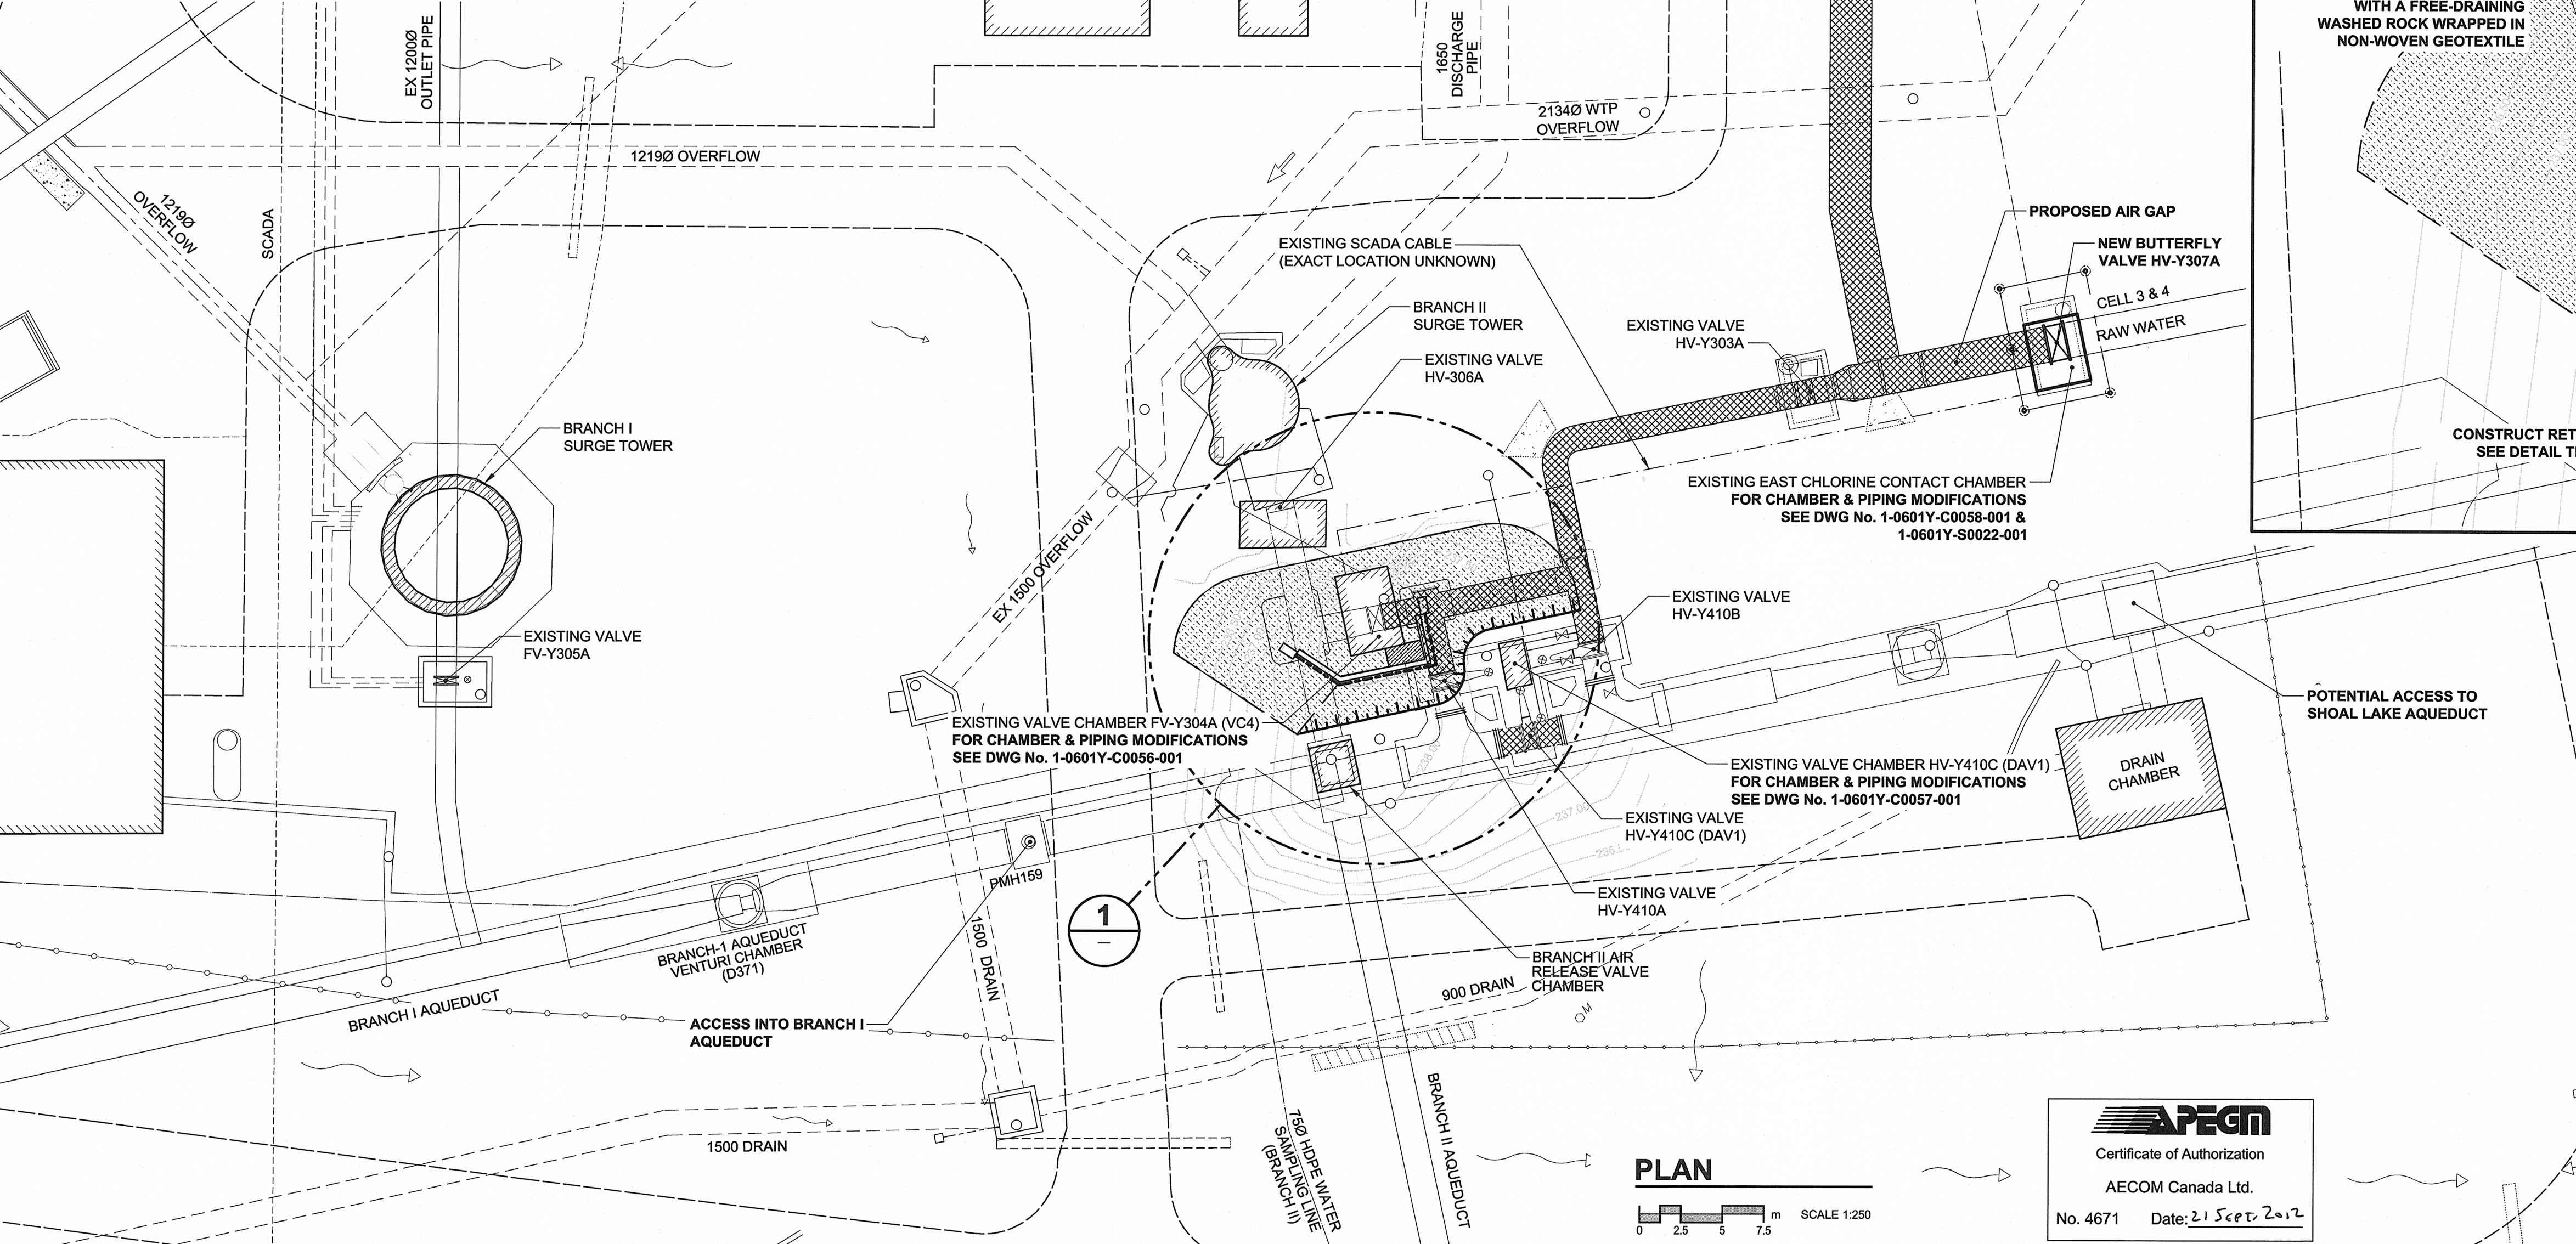

AECOM
Certificate of Authorization
AECOM Canada Ltd.
No. 4671 Date: 21 Sept 2012

150 WM	WATERMAIN	150 WM	○	CURB STOP	○	150 WM	WATERMAIN	150 WM	○	LOCATION APPROVED
○	HYDRANT	○	○	REDUCER	○	○	HYDRANT	○	○	UNDERGROUND STRUCTURES
○	VALVE	○	○	COUPLING	○	○	VALVE	○	○	DATE
○	300 LDS LAND DRAINAGE SEWER	○	○	ANODE	○	○	LAND DRAINAGE SEWER	○	○	COMMITTEE
○	250 WWS WASTE WATER SEWER	○	○	HYDRO	○	○	WASTE WATER SEWER	○	○	NOTE:
○	MANHOLE	○	○	MTS	○	○	PAVEMENT CROWN	○	○	LOCATION OF UNDERGROUND STRUCTURES AS SHOWN ARE BASED ON THE BEST INFORMATION AVAILABLE. BUT NO GUARANTEE IS GIVEN THAT ALL EXISTING UTILITIES ARE SHOWN OR THAT THE GIVEN LOCATIONS ARE EXACT. CONFIRMATION OF EXISTENCE AND EXACT LOCATION OF ALL SERVICES MUST BE OBTAINED FROM THE INDIVIDUAL UTILITIES BEFORE PROCEEDING WITH CONSTRUCTION.
○	CATCH BASIN	○	○	GAS	○	○	DITCH	○	○	
○	CURB INLET	○	○	TESTHOLE	○	○	BOTTOM OF SLOPE	○	○	
○	CULVERT	○	○	LAMP STANDARD	○	○		○	○	
○	PIPE ABANDONMENTS	○	○	TREE	○	○		○	○	
○	SURVEY BAR	○	○		○	○		○	○	
○	EXISTING	○	○		○	○		○	○	
○	LEGEND - PLAN	○	○		○	○		○	○	
○	NEW	○	○		○	○		○	○	
○	EXISTING	○	○		○	○		○	○	
○	LEGEND - PROFILE	○	○		○	○		○	○	
○	NEW	○	○		○	○		○	○	
○	EXISTING	○	○		○	○		○	○	

0	ISSUED FOR CONSTRUCTION	12/09/21	KMB/KLC
NO.	REVISIONS	YYMMDD	BY

DESIGNED BY	ADB	CHECKED BY	CCW
DRAWN BY	KMB	APPROVED BY	CCW
HOR. SCALE	1:250	RELEASED FOR CONSTRUCTION	21 Sept 2012
VERT. SCALE	N/A	DATE	21 Sept 2012

PROFESSIONAL'S SEAL
PROVINCE OF MANITOBA
21 Sept 2012
C.C. MACEY
REGISTERED ENGINEER
CONSULTANT DRAWING NO.
60163046-01-C-101-ROX.dwg

METRIC
WHOLE NUMBERS INDICATE MILLIMETRES
DECIMALIZED NUMBERS INDICATE METRES

THE CITY OF WINNIPEG
WATER AND WASTE DEPARTMENT

WATER TREATMENT PLANT PROTECTED CONNECTIONS

CIVIL SITE PLAN

SHEET 2 OF 10
CITY DRAWING NUMBER
1-0601Y-C0055-001
REV 0

BID OPPORTUNITY NO. 708-2012