



SYMBOL SCHEDULE

	FLUORESCENT LIGHT FIXTURE
	INCANDESCENT/H.I.D. LIGHT FIXTURE, WALL OR CEILING MOUNTED, AS INDICATED.
	WALL MOUNTED FLOURESCENT LIGHT FIXTURE CONTROLLED BY L.V. RELAY #3
	EXIT LIGHT
	EMERGENCY LIGHTING TYPE 'A'
	EMERG. BATTERY
	LIGHT SWITCH
	GANG MOUNTED LIGHT SWITCHES
	THREE WAY TOGGLE SWITCHES
	LIGHT SWITCH C/W PILOT LIGHT
	DUPLEX RECEPTACLE
	DUPLEX RECEPTACLE C/W W.P. COVER
	MOTOR
	PANIC ALARM HORN
	PANIC ALARM SYSTEM
	PANIC ALARM LIGHT
	MISCELLANEOUS EQUIPMENT
	FIRE ALARM MANUAL STATION
	FIRE ALARM
	FIRE ALARM DETECTOR TYPE 'D', ZONE 1
	SPEAKER TYPE 'A'
	MICROPHONE OUTLET
	FLOOR OUTLET TYPE 'A'
	TIMING SYSTEM JUNCTION BOX 'A'
	L.V. TRANSFORMER

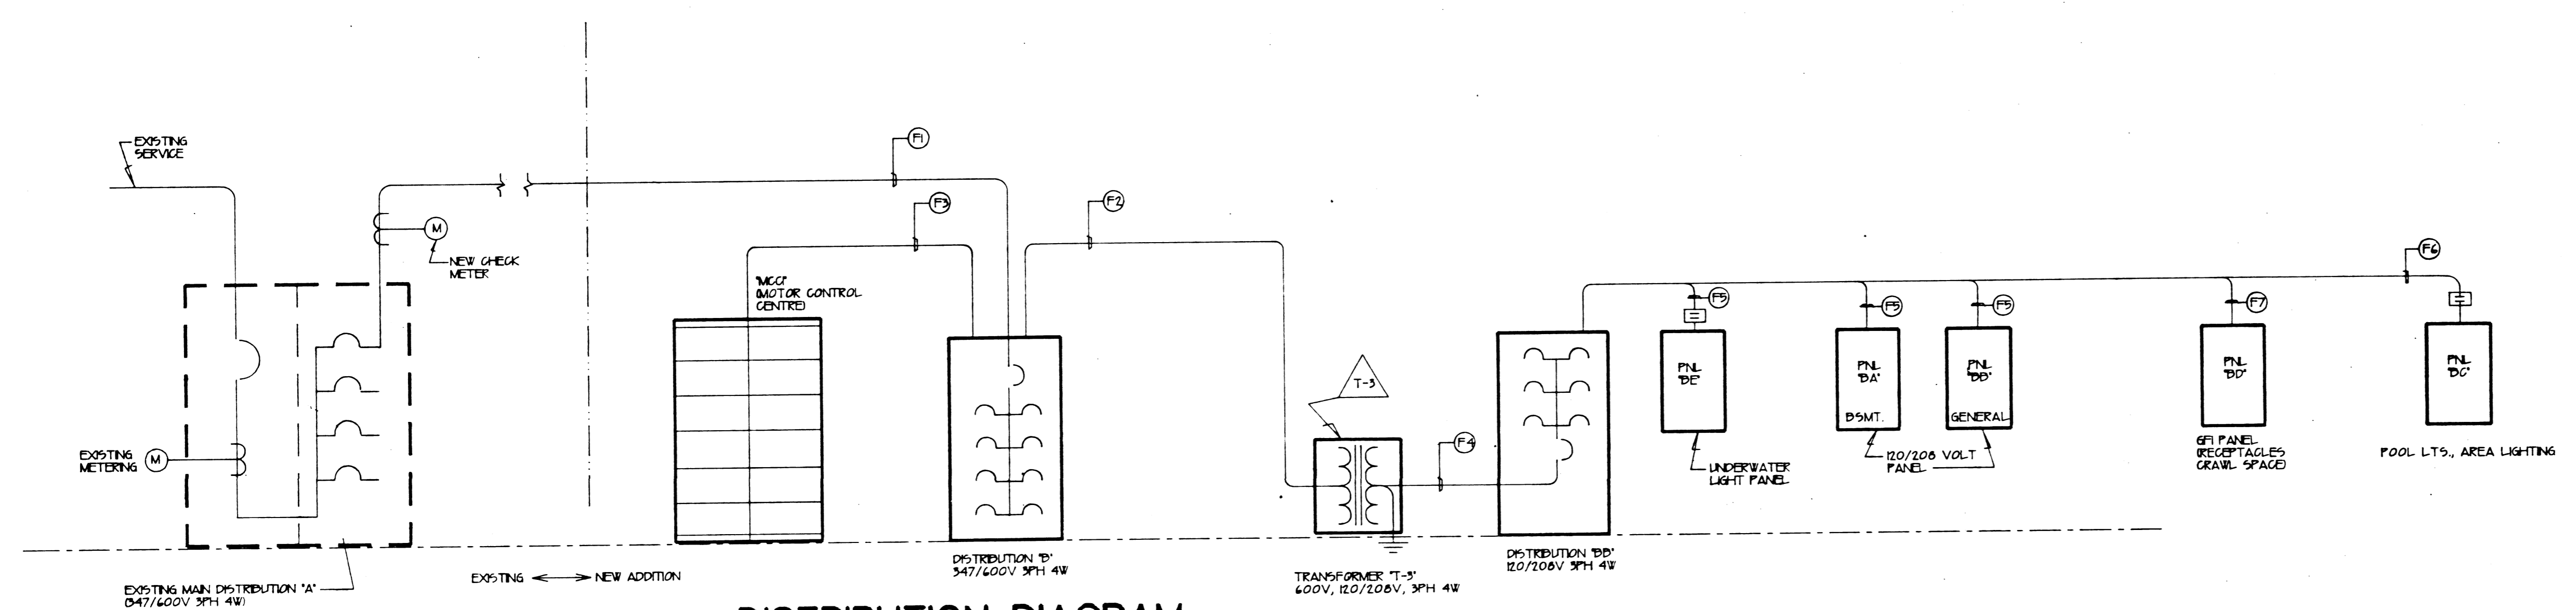

DISTRIBUTION DIAGRAM

N.T.S. 600 VOLT, 3PH., 3W. - 120/208V., 3PH., 4W.

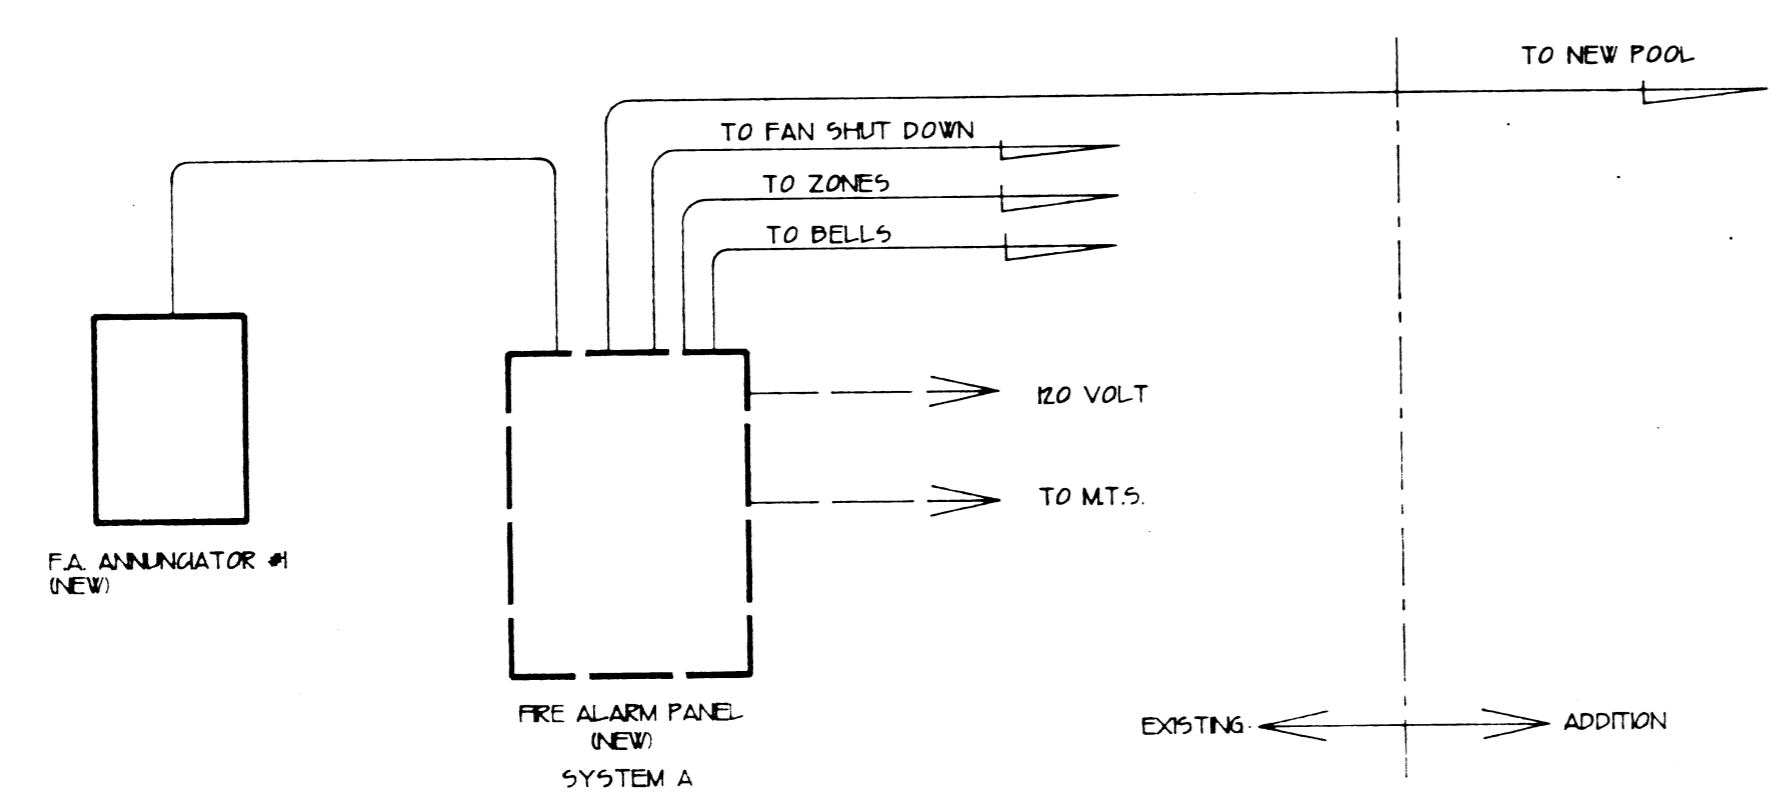


FIRE ALARM RISER DIAGRAM (TYPICAL)

N.T.S.

DPSP-1	7 1/2 HP.	PP - 1	
DPSP-2	7 1/2 HP.	PP - 2	25 HP.
SF-1	2 HP.	VP - 1	5 HP.
SF-2	2 HP.	PP - 1	5 HP.
		PP - 2	5 HP.
			SPARE


MCC1 ELEVATION

N.T.S. 600 VOLT, 3 PH., 3 W.

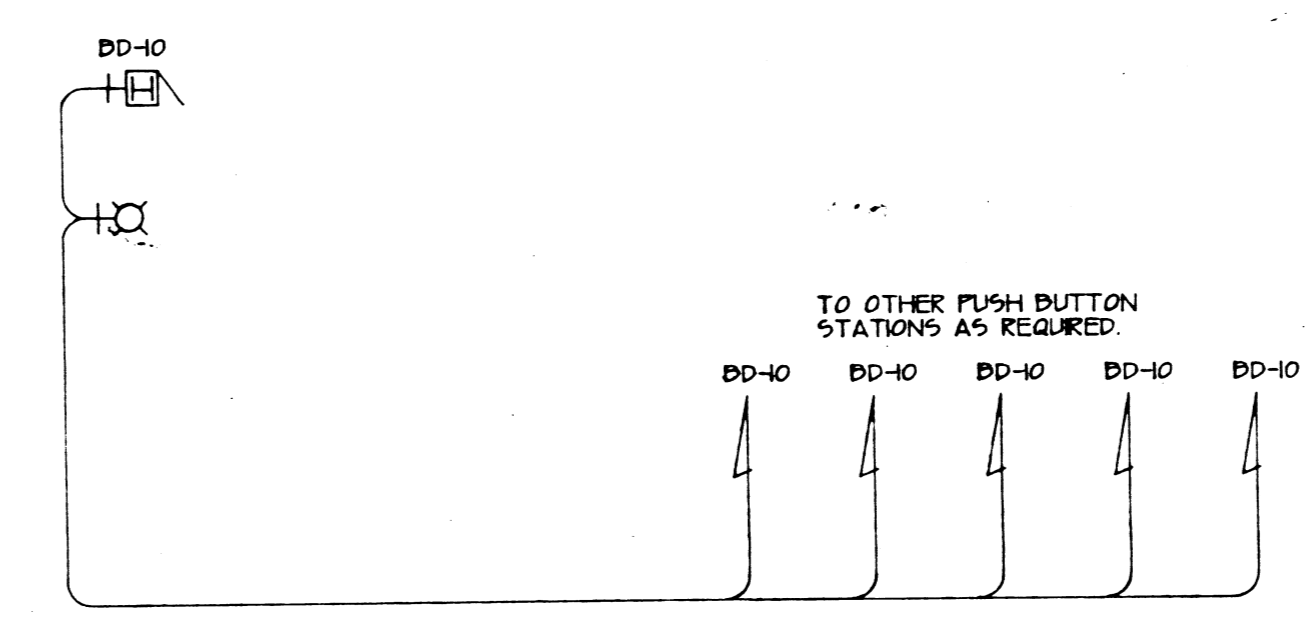

PANIC ALARM SYSTEM RISER DIAGRAM

N.T.S.

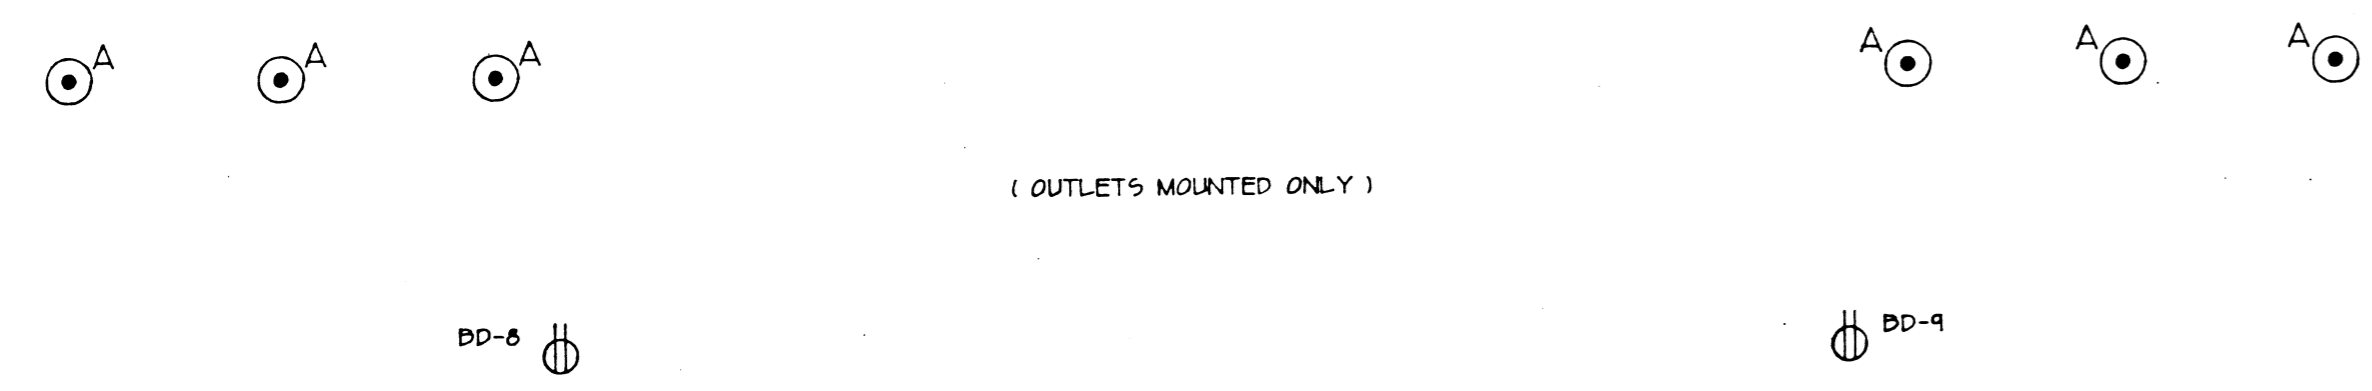

TIMING SYSTEM RACEWAY RISER DIAGRAM

N.T.S. REFER TO SPECIFICATIONS

REVISION NO. 2 PER POST TENDER ADDENDUM (AUG/13)

REVISION NO. 1

SWIM MANITOBA
PAN AM POOL ADDITION

L. P. WILLIAMS AND ASSOCIATES LTD
ELECTRICAL CONSULTING ENGINEERS
1217 LORETTA AVENUE, WINNIPEG, MANITOBA, R3M-1V1
(204) 453-8220

JOB #	
DATE	MAY 10 / 1993
DRAWN BY	D.A.M.
CHECK BY	L.P.W.

SHEET TITLE	ELECTRICAL DETAILS
SCALE	AS NOTED
CAD FILE	

AS BUILT