


1 M&R BUILDING PLAN  
1:100

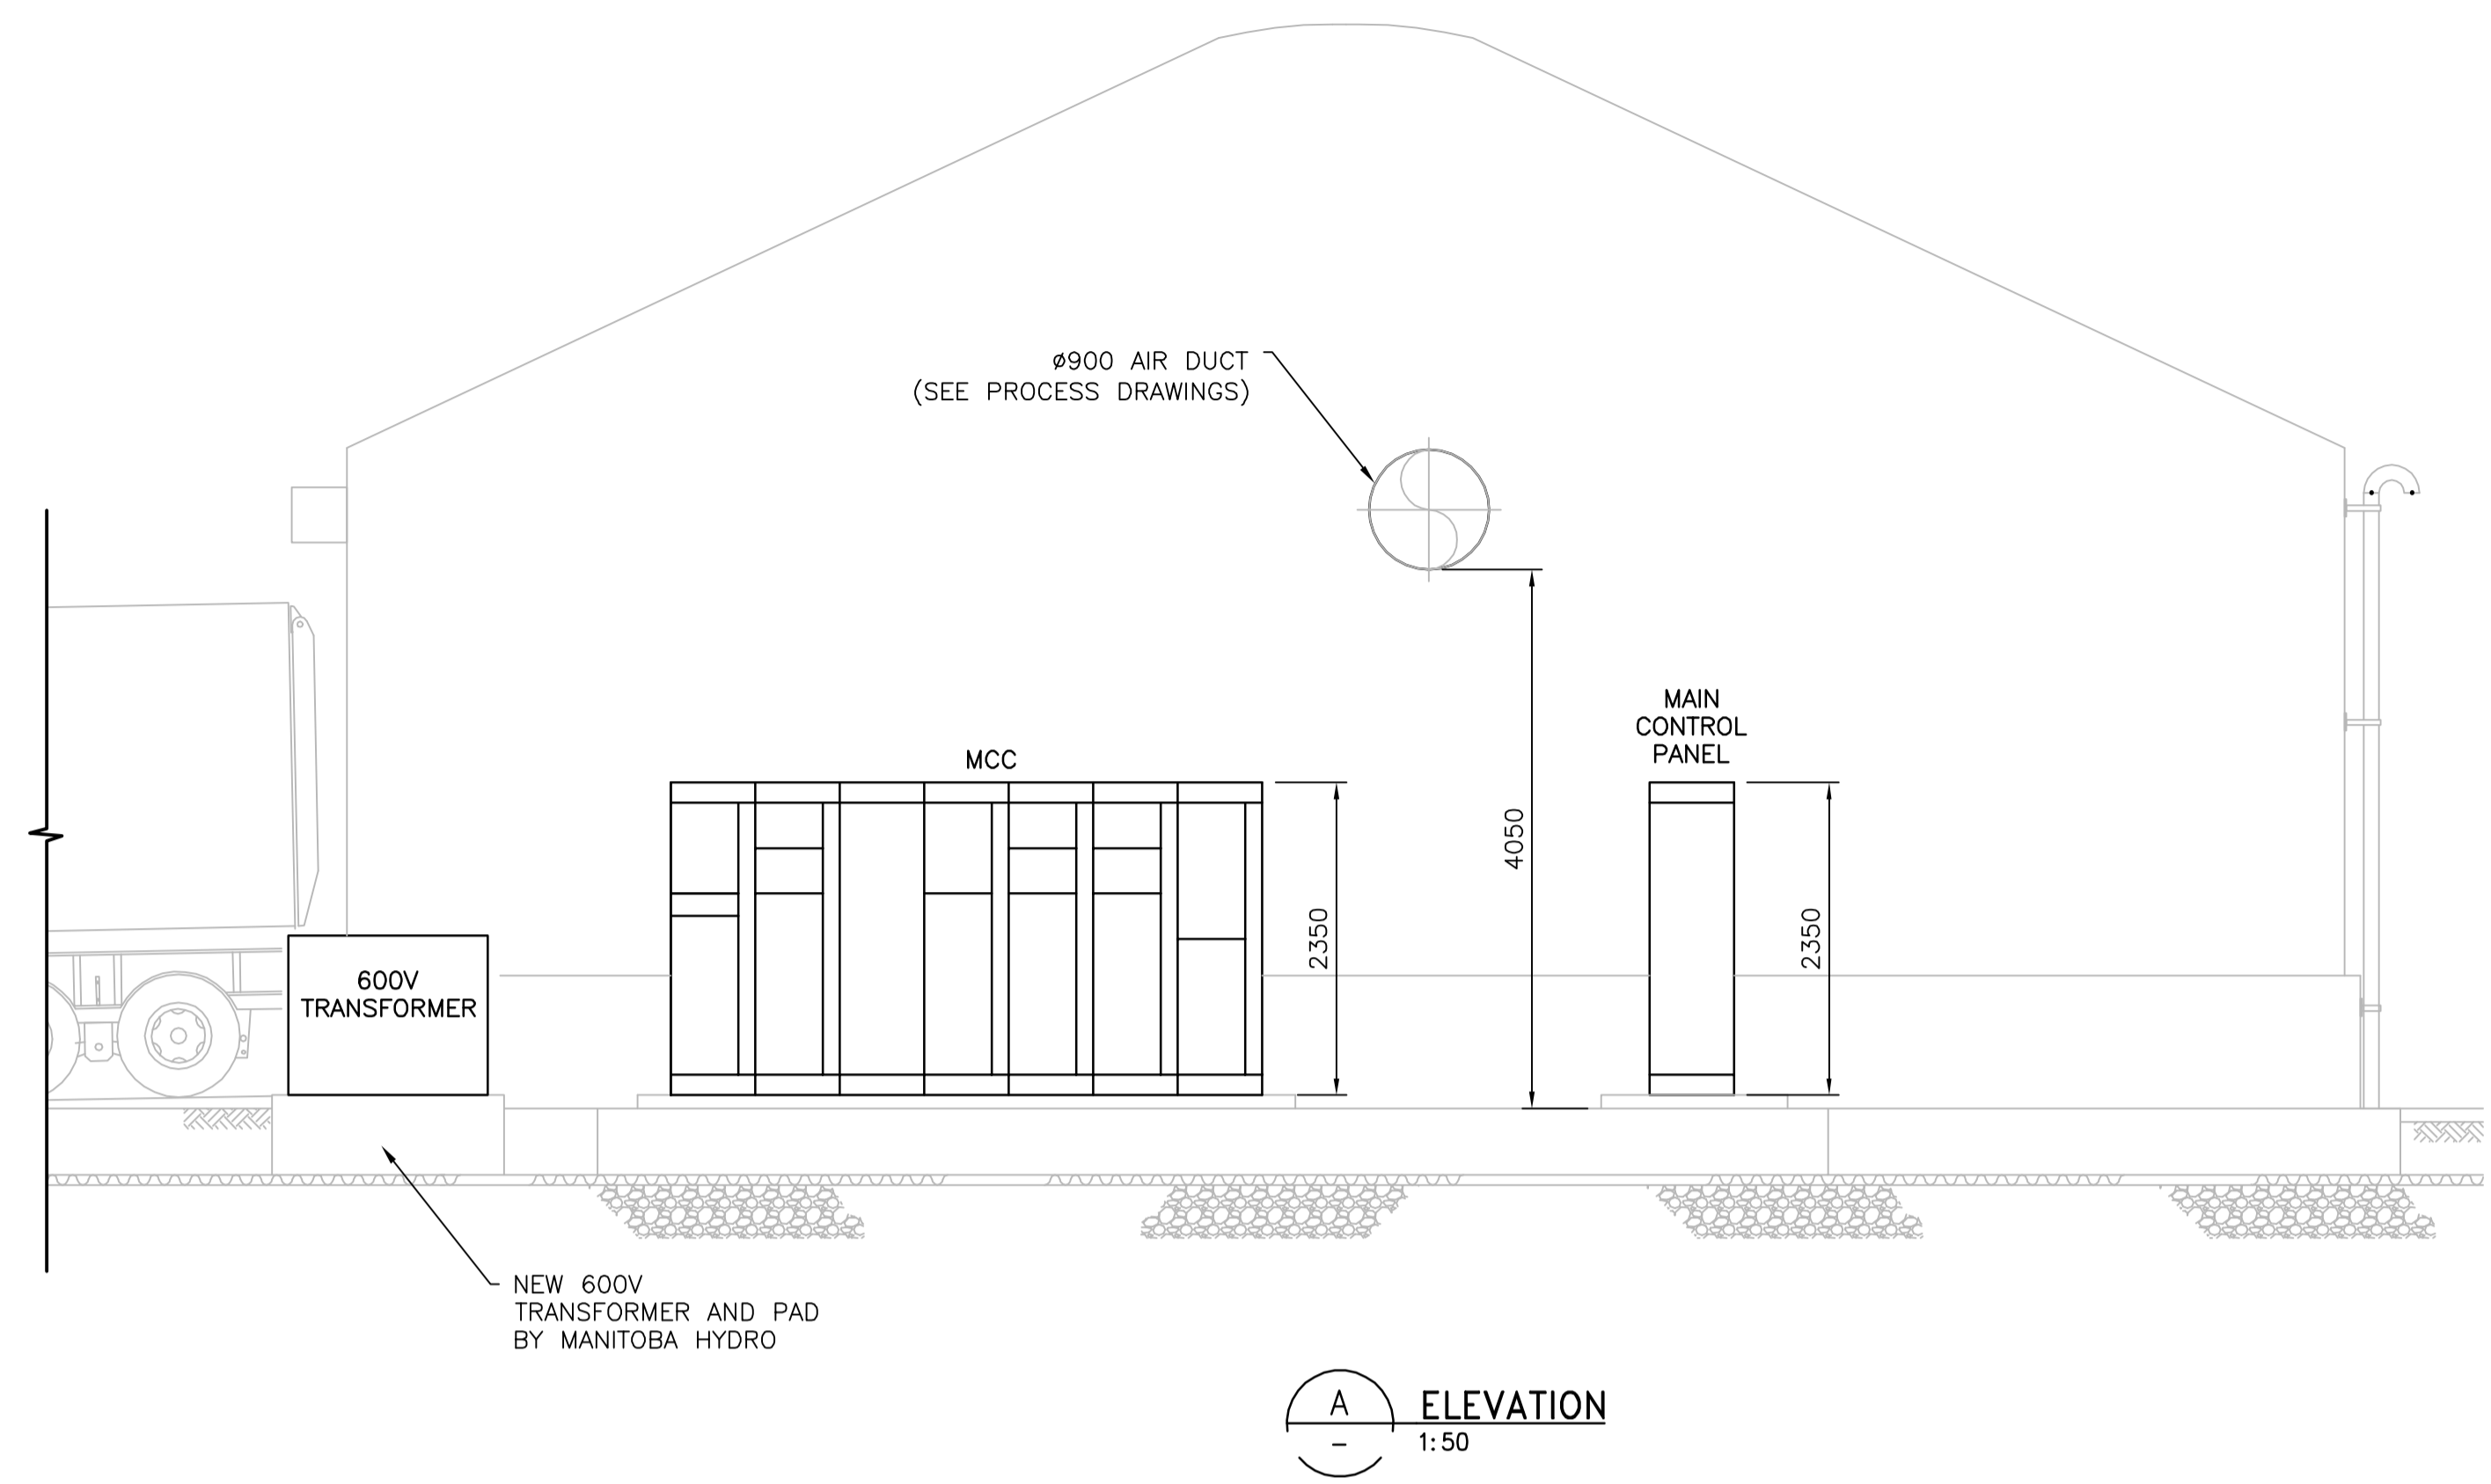


A ELEVATION  
1:50

- NOTE:  
 1. FOR LUMINAIRE SCHEDULE, SEE DRAWING E-203.  
 2. CONTRACTOR TO COORDINATE WITH EQUIPMENT SUPPLIER TO LOCATE ELECTRICAL POWER SUPPLY FOR THE MIXER AND CONVEYORS.



B.M. ELEV.		CONSTRUCTION COMPLETION DATE: YYYY MM DD	
DESIGNED BY	LL	CHECKED BY	WT
DRAWN BY	EA	APPROVED BY	BW
SCALE: HORIZONTAL	AS NOTED	RELEASED FOR CONSTRUCTION	
DATE	2013 01 25	DATE	
NO.	REVISIONS	DATE	BY
0	ISSUED FOR CONSTRUCTION	13/01/25	JBC

<b>CH2MHILL</b>	
DESIGNED BY	LL
DRAWN BY	EA
SCALE: HORIZONTAL	AS NOTED
DATE	2013 01 25

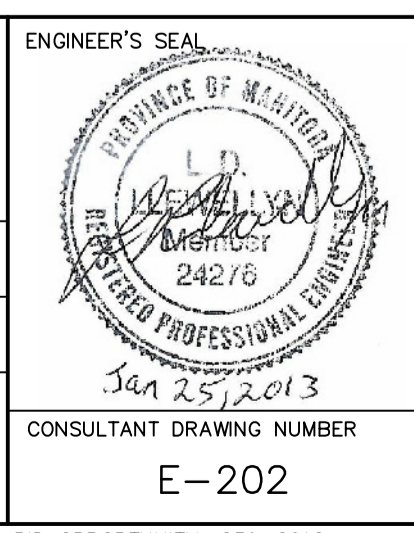

**THE CITY OF WINNIPEG**  
 WATER AND WASTE DEPARTMENT  
 ENGINEERING DIVISION

**Winnipeg**

BRADY ROAD RESOURCE MANAGEMENT FACILITY  
 LEAF AND YARD WASTE AND  
 PILOT BIOSOLIDS COMPOSTING

ELECTRICAL  
 M&R BUILDING LIGHTING PLAN

SHEET 40 OF 45  
 CITY DRAWING NUMBER  
 1-0400B-E0003-001-00