


AI - 841594

2014-01-13

ACCOMMODATION\_DEFAULT.DWG

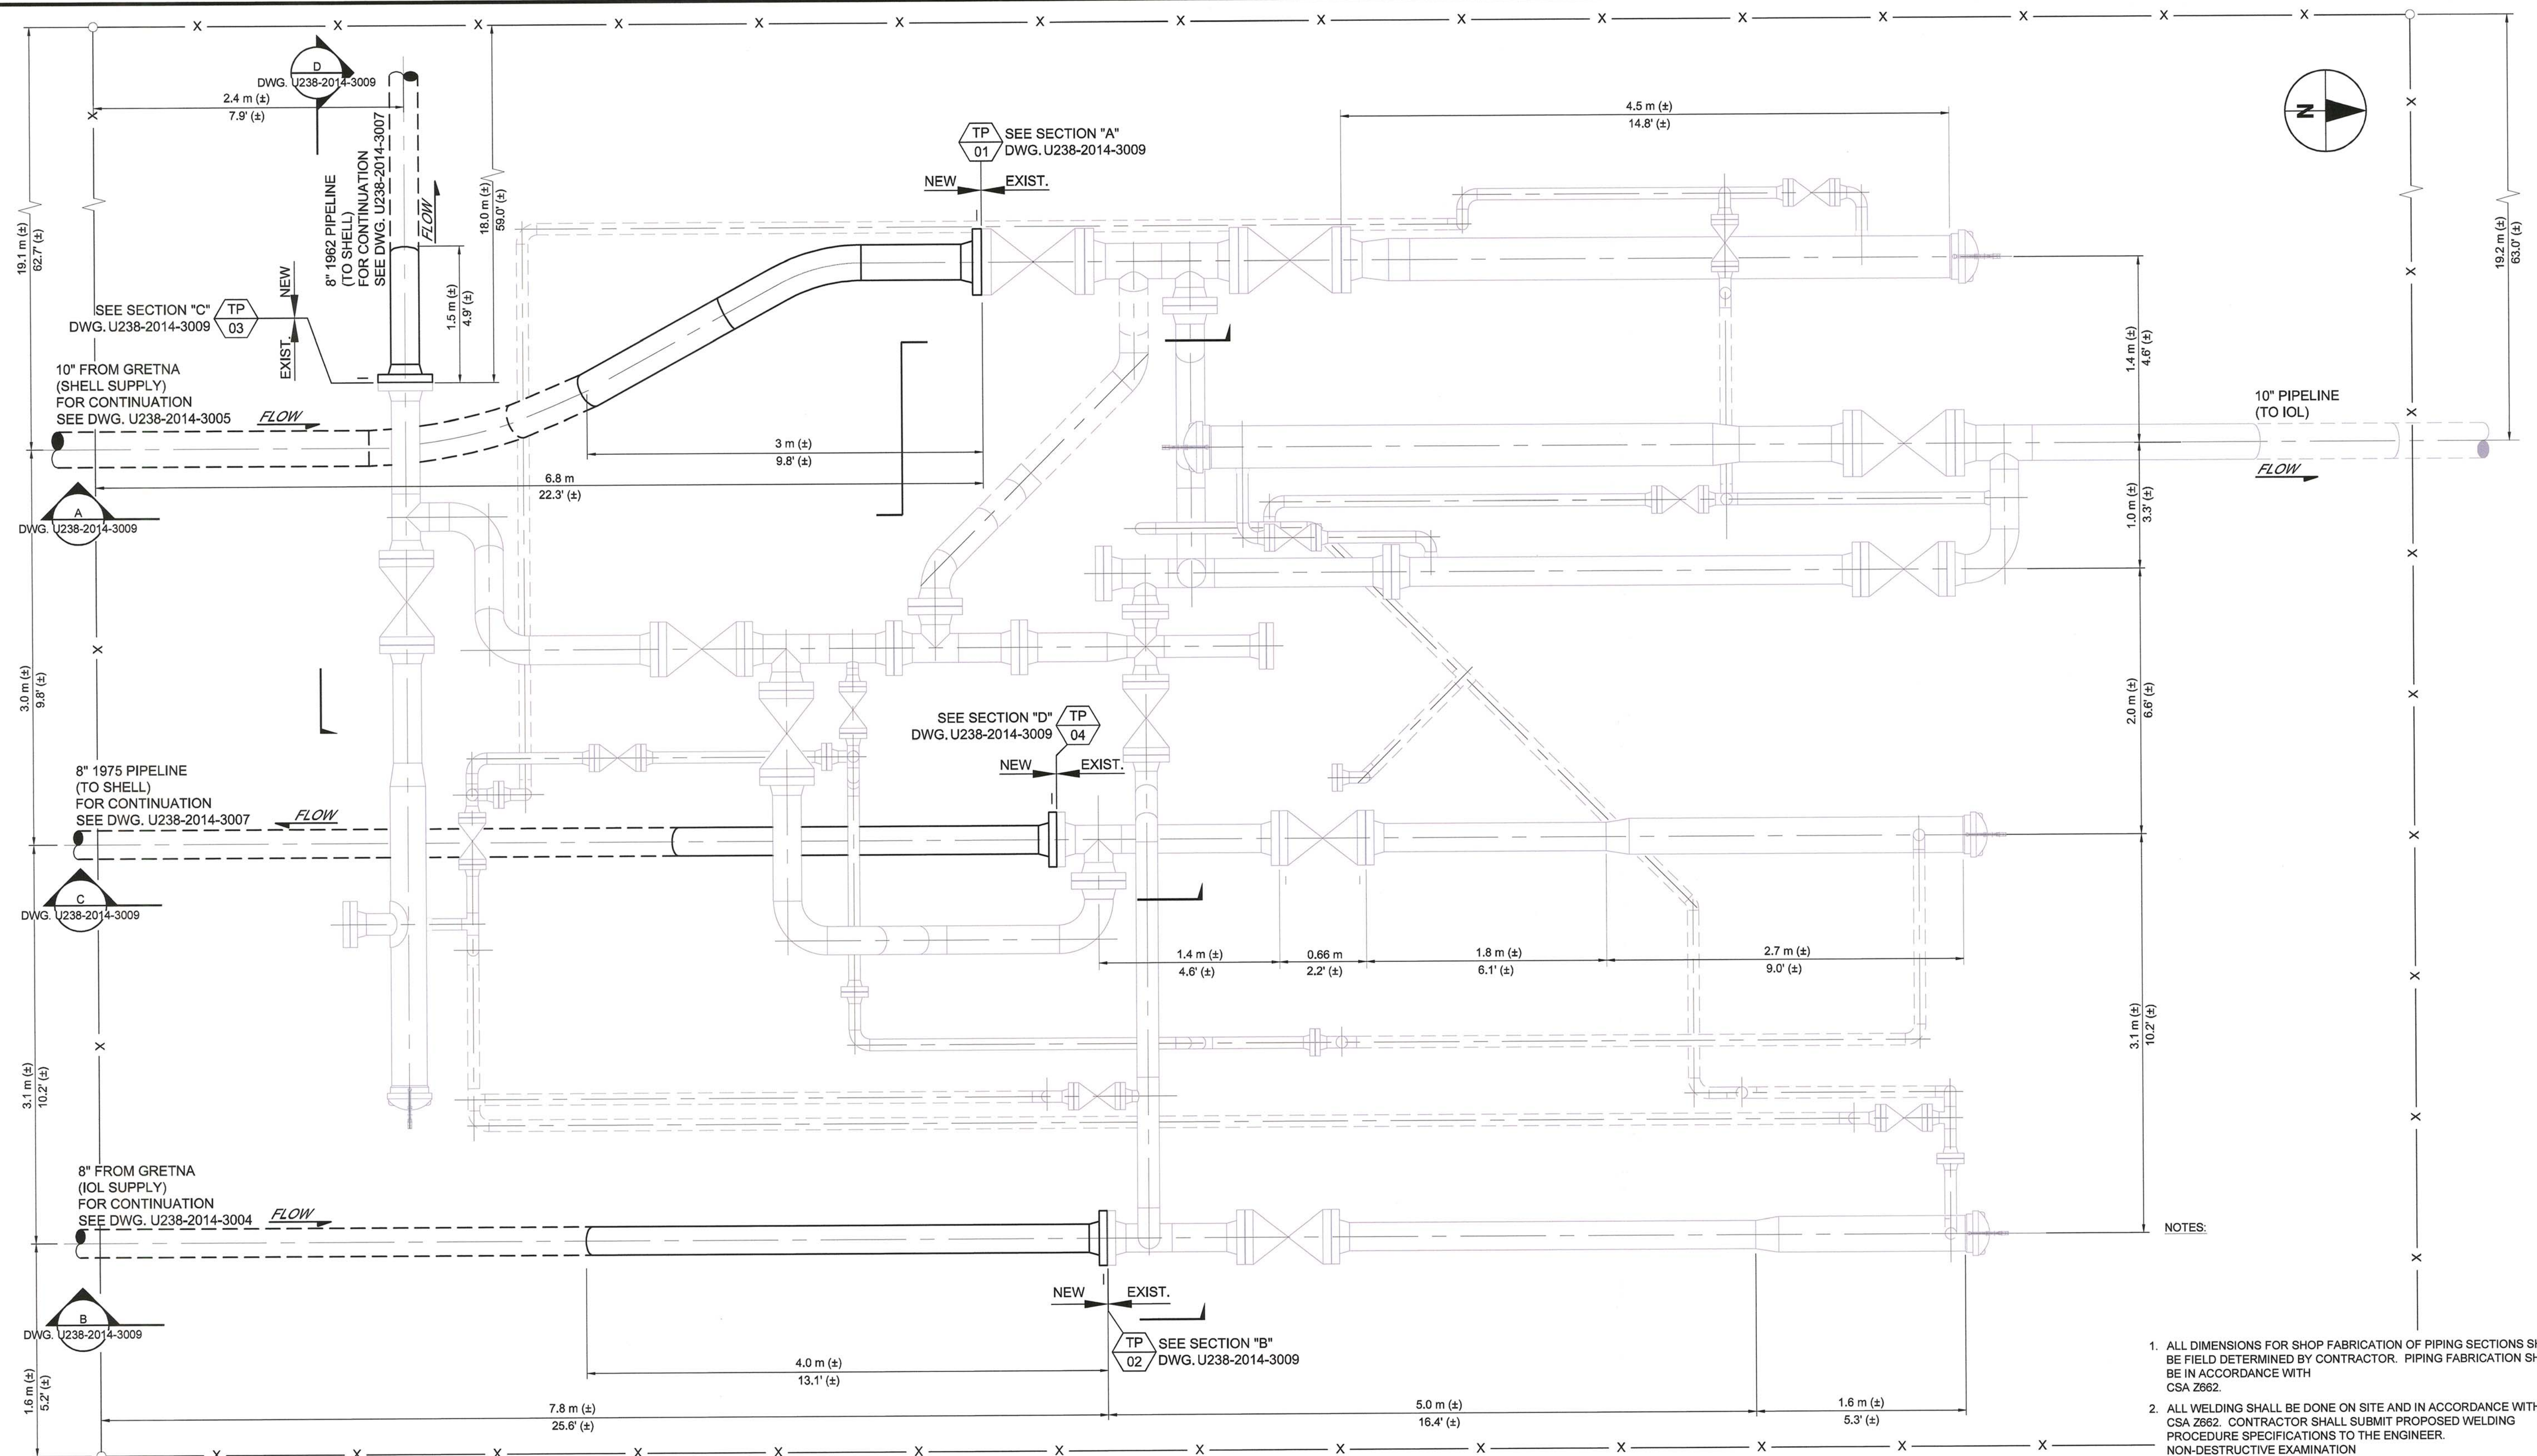

**SITE PLAN**  
SCALE=1:25

- NOTES:
1. ALL DIMENSIONS FOR SHOP FABRICATION OF PIPING SECTIONS SHALL BE FIELD DETERMINED BY CONTRACTOR. PIPING FABRICATION SHALL BE IN ACCORDANCE WITH CSA Z662.
  2. ALL WELDING SHALL BE DONE ON SITE AND IN ACCORDANCE WITH CSA Z662. CONTRACTOR SHALL SUBMIT PROPOSED WELDING PROCEDURE SPECIFICATIONS TO THE ENGINEER. NON-DESTRUCTIVE EXAMINATION (INCLUDING RADIOGRAPHIC EXAMINATION) OF WELDS SHALL BE PERFORMED ON ALL WELDS IN ACCORDANCE WITH CSA Z662. ACCEPTANCE STANDARDS SHALL BE IN ACCORDANCE WITH CSA Z662.
  3. PRIOR TO INSTALLATION, NEW PIPING SECTIONS SHALL BE HYDROSTATICALLY TESTED IN ACCORDANCE WITH CSA Z662.
  4. CONTRACTOR TO FIELD VERIFY ALL DIMENSIONS AND ELEVATIONS PRIOR TO CONSTRUCTION.
  5. DESIGNS ARE NOT YET FINALIZED AND APPROVED BY IMPERIAL OIL AND SHELL OIL.



BID OPPORTUNITY NO. 1058-2013

**DISCLAIMER:**  
URS MAKES NO WARRANTY (EXPRESS, IMPLIED OR OTHERWISE) THAT THE INFORMATION CONTAINED HEREIN IS ACCURATE OR COMPLETE AS TO ANY AND ALL SUBSURFACE CONDITIONS AND CONFORMATION. ANY RELIANCE CONTRACTOR PLACES ON THE INFORMATION CONTAINED HEREIN AS TO SUCH CONDITIONS IS DONE SO AT ITS OWN RISK AND EXPENSE. IT IS THE SOLE RESPONSIBILITY OF THE CONTRACTOR TO CONTACT THE PROVINCE "ONE CALL" SYSTEM PRIOR TO ANY EXCAVATION.



**LOCATION APPROVED UNDERGROUND STRUCTURES**  
SUPV. UG STRUCTURES COMMITTEE DATE  
NOTE: LOCATION OF UNDERGROUND STRUCTURES AS SHOWN ARE BASED ON THE BEST INFORMATION AVAILABLE, BUT NO GUARANTEE IS GIVEN THAT ALL EXISTING UTILITIES ARE SHOWN OR THAT THE GIVEN LOCATIONS ARE EXACT. CONFIRMATION OF EXISTENCE AND EXACT LOCATION OF ALL SERVICES MUST BE OBTAINED FROM THE INDIVIDUAL UTILITIES BEFORE PROCEEDING WITH CONSTRUCTION.

B.M. ELEV.	NO.	REVISIONS	DATE	BY
	0	ISSUED FOR TENDER	14/01/11	CC
	B	ISSUED FOR APPROVAL	14/01/10	CC
	A	ISSUED FOR APPROVAL	14/01/09	CC

<b>URS</b> 4th FLOOR, 30 LEEK CR RICHMOND HILL, ON L4B 4N4		DESIGNED BY: CC	CHECKED BY: BB
DRAWN BY: CC	APPROVED BY: LN	HOR. SCALE: 1:25	RELEASED FOR CONSTRUCTION BY: URS
VERTICAL: N/A	DATE: 2013-12-28	DATE: 2013-12-28	

ENGINEER'S SEAL  
PROVINCE OF MANITOBA  
G. RAMNATH  
Member  
36779  
CONSULTANT DRAWING NO.  
49235421-1701-001

**THE CITY OF WINNIPEG PUBLIC WORKS DEPARTMENT**

IMPERIAL OIL LIMITED AND SHELL CANADA PIPELINES RELOCATION WORKS

TRANSCONA VALVE STATION TIE-IN LOCATION PIPING PLAN

CITY DRAWING NUMBER: U238-2014-3008  
SHEET 01 OF 02  
01