


WEST WING EAST WING

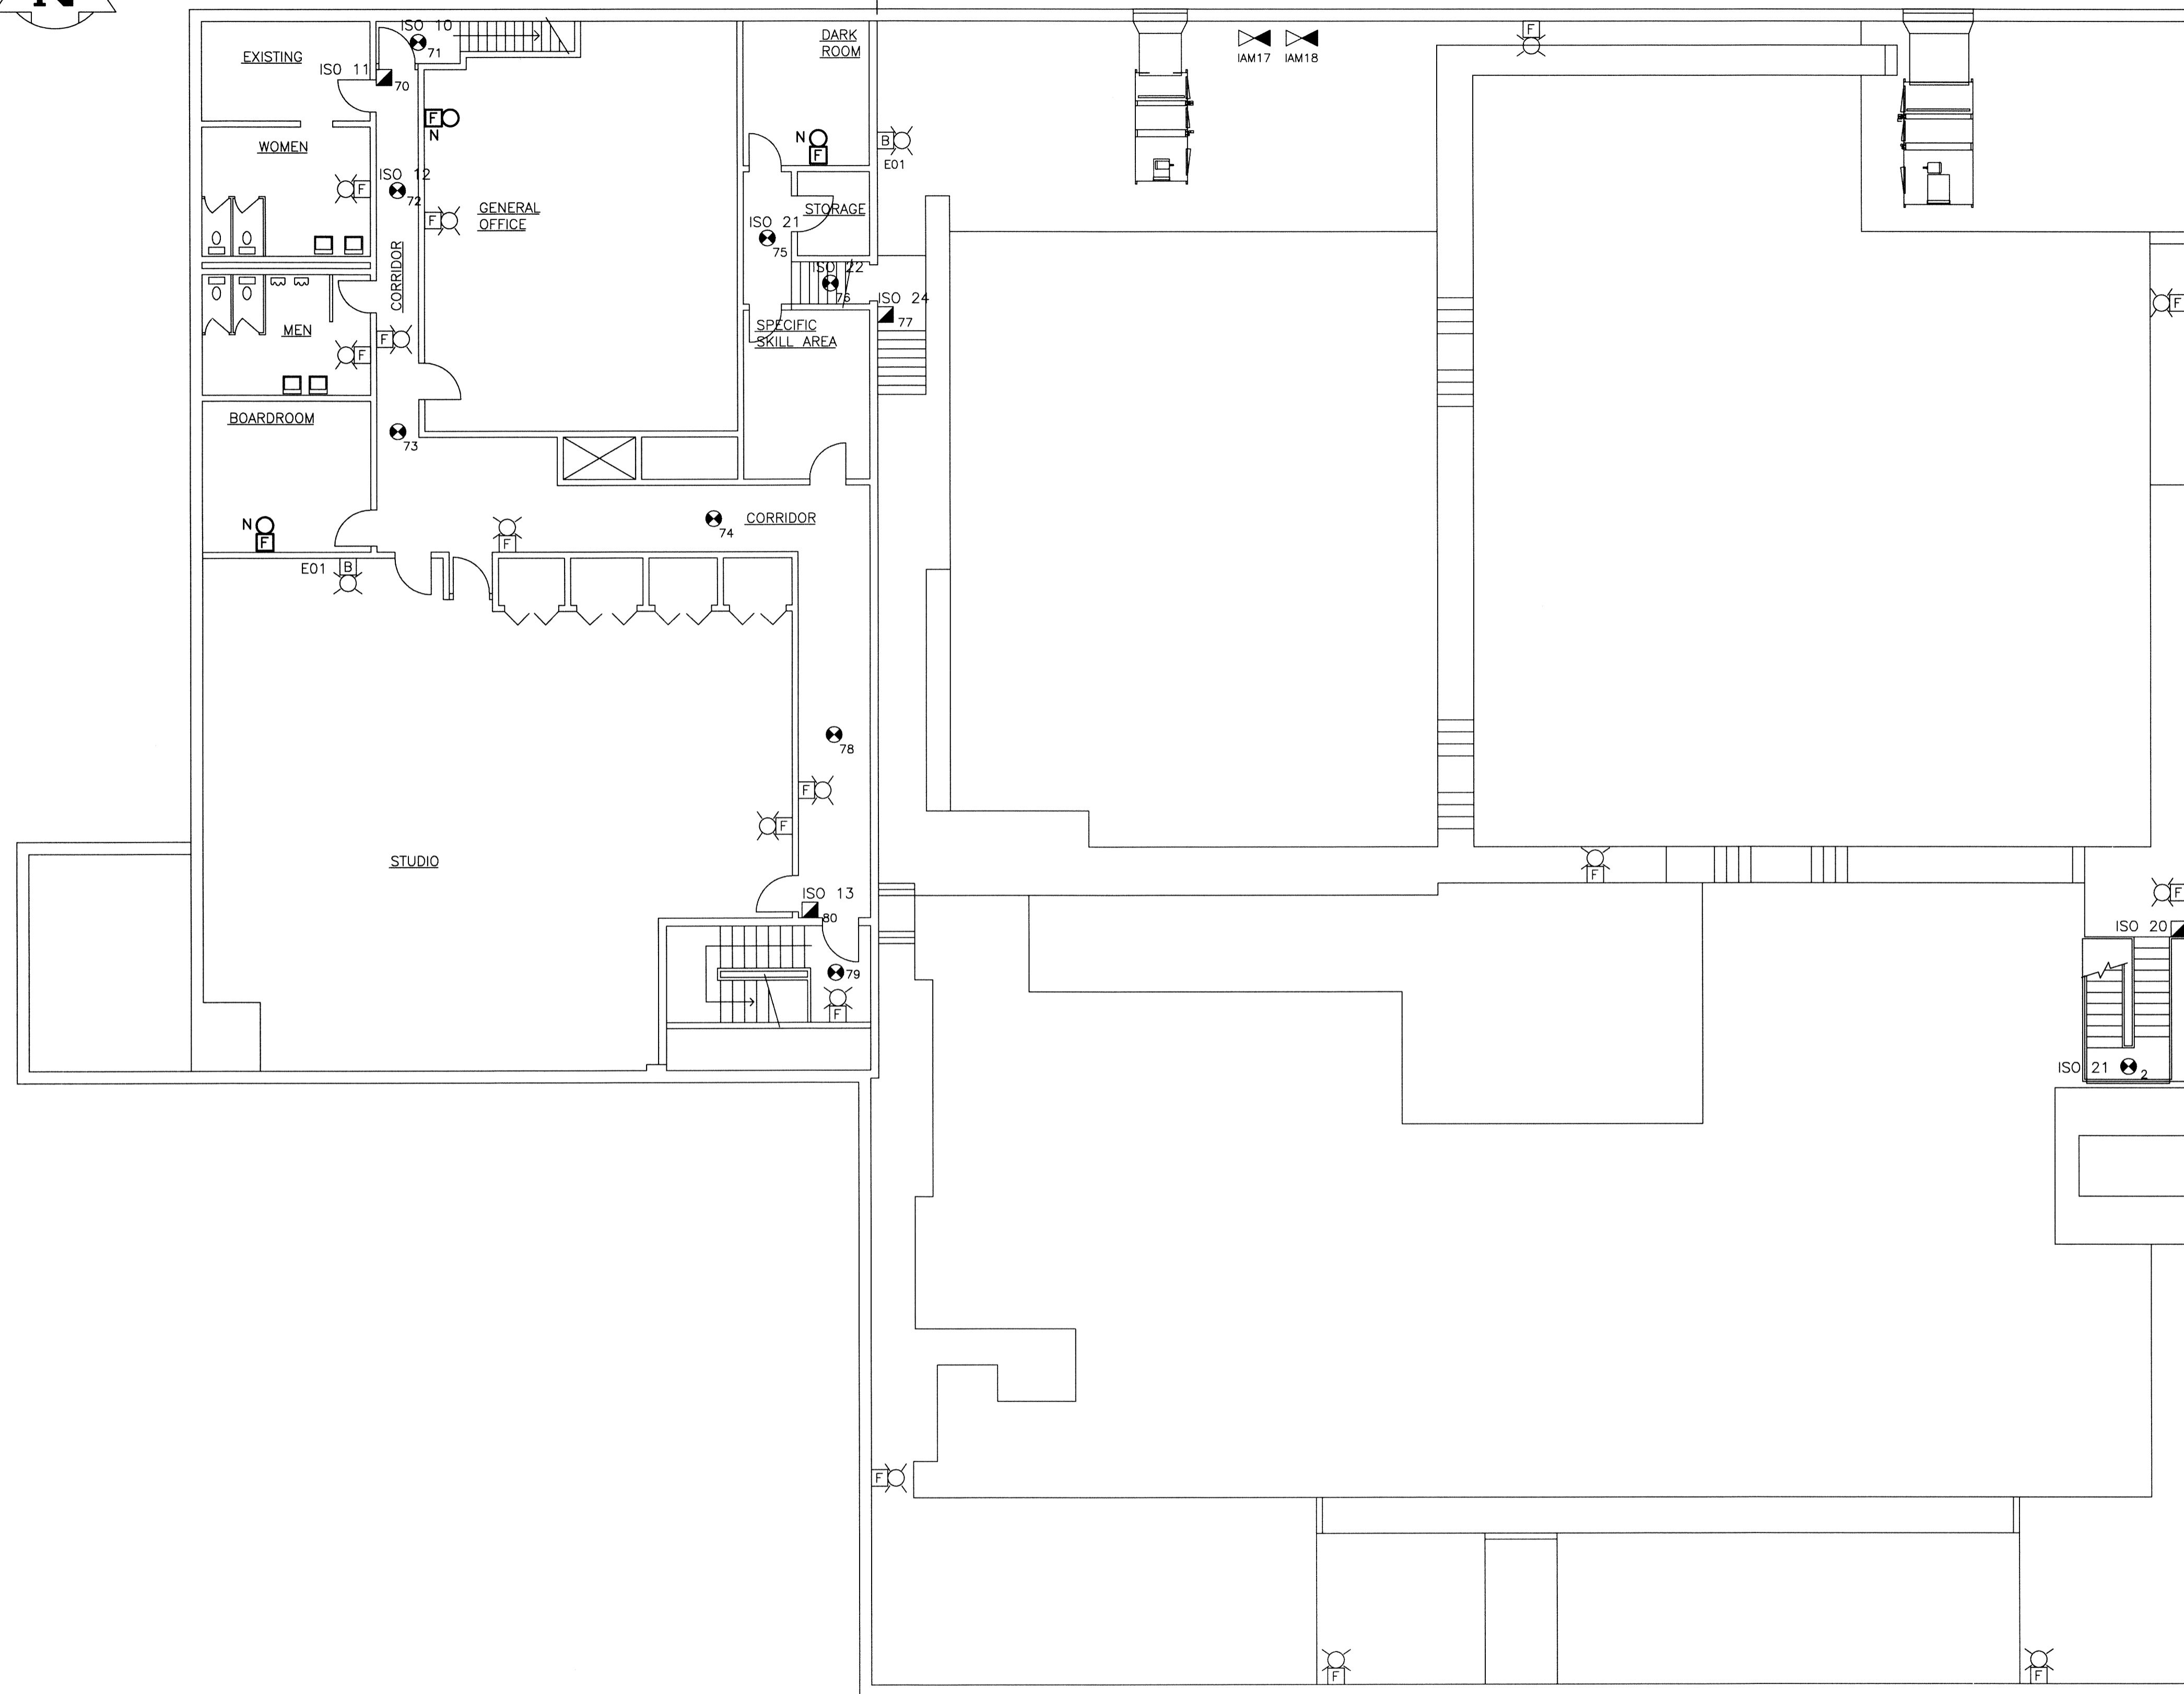

NOTES:


- 1. ADD NEW FIRE ALARM BELLS AS SHOWN.

LEGEND:

- MAIN FIRE ALARM PANEL
- SMOKE DETECTOR
- HEAT DETECTOR
- MANUAL PULLSTATION
- FIRE ALARM STROBE LIGHT
- FIRE ALARM BELL (12")
- FIRE ALARM BELL (12") AND STROBE LIGHT

File Name: P:\Projects\2011\11-0107-02\Doc.Control\Tab\Issued\DWG\11-0107-02_P2-E04_Rev 1.dwg - Tab: P2-E04 Plotted By: DDerocche 13/03/12 [Tue 4:28pm]

MEZZANINE/SECOND FLOOR PLAN

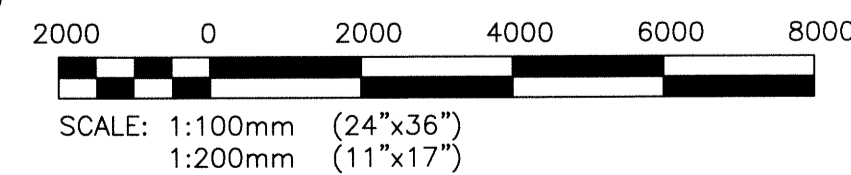

B.M. ELEV.			
DESIGNED BY	AP		
DRAWN BY	GCN		
1	RE-ISSUED FOR TENDER	13/03/08	
0	ISSUED FOR TENDER	12/03/07	AP
NO.	REVISIONS	DATE	BY

KGS GROUP CONSULTING ENGINEERS & PROJECT MANAGERS
WINNIPEG (204) 896-1209
THUNDER BAY (807) 345-2233

DESIGNED BY	AP	CHECKED BY	JLL
DRAWN BY	GCN	APPROVED BY	
HOR. SCALE:	AS SHOWN	RELEASED FOR CONSTRUCTION:	
VERTICAL:		DATE	

ENGINEER'S SEAL

CONSULTANT DRAWING NO. P2-E04

THE CITY OF WINNIPEG
PLANNING, PROPERTY AND DEVELOPMENT DEPARTMENT

PROJECT TITLE: FORT ROUGE LEISURE CENTRE HVAC UPGRADES - PHASE 2 BID OPPORTUNITY NO. 190-2013

SHEET 001 OF 001
COMPUTER FILE NAME: 11-0107-02-P2-E04
CITY DRAWING NUMBER