



SITE PLAN

1:200

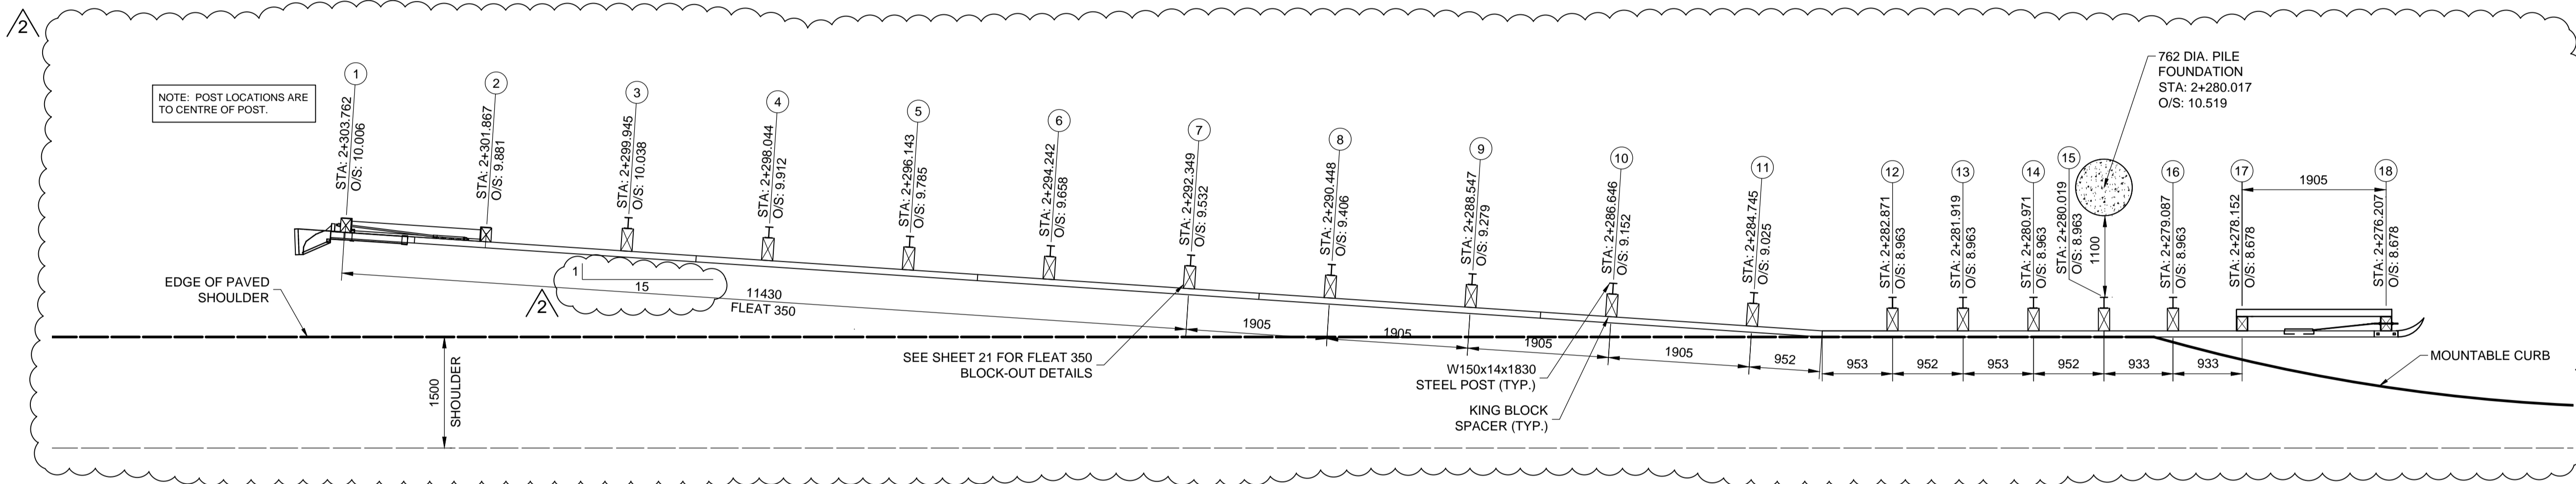

PLAN - MIDWEST GUARD RAIL SYSTEM

1:50

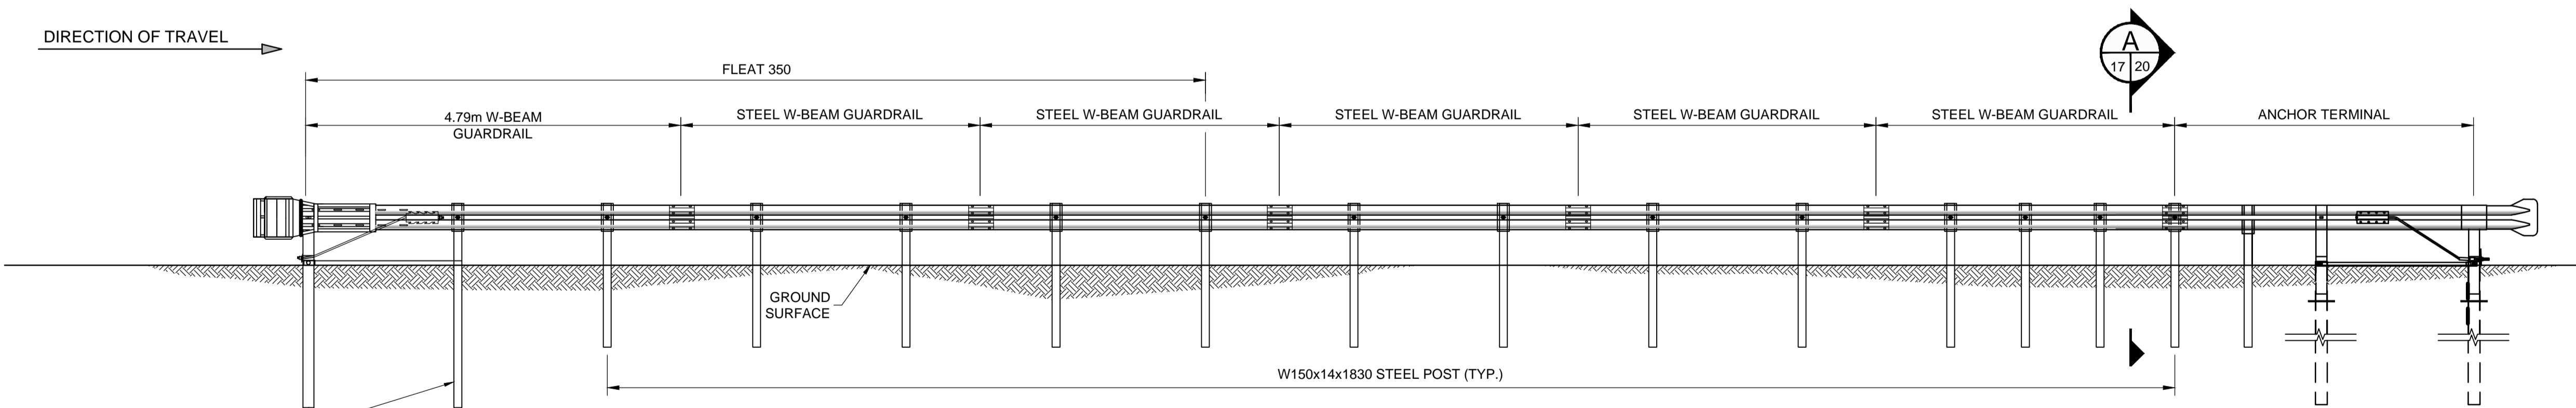

ELEVATION LOOKING EAST - MIDWEST GUARD RAIL SYSTEM

1:50

APEGM
 Certificate of Authorization
Dillon Consulting Limited (MB)
 No. 1789 Date: 2013-04-05

METRIC

WHOLE NUMBERS INDICATE MILLIMETRES
 DECIMALIZED NUMBERS INDICATE METRES

WARNING

- IF POWER EQUIPMENT OR EXPLOSIVES ARE TO BE USED FOR EXCAVATION ON THIS PROJECT THE CONTRACTOR MUST:
1. NOTIFY THE GAS COMPANY OF THE PROPOSED LOCATION OF EXCAVATION.
 2. TAKE PRECAUTION TO AVOID DAMAGE TO GAS COMPANY INSTALLATIONS SEE PROVINCIAL REGULATION 210/72 FOR DETAILS.
 3. OBTAIN EXCAVATION PERMITS PRIOR TO CONSTRUCTION.

G:\CAD\126606\Contract\Contract_3\Current\126606-09-STR_Guard_Rails.dwg

150 WM	WATERMAIN	150 WM	M.T.S.	M.T.S.	150 mm W.M.	WATERMAIN	150 mm W.M.
⊕	HYDRANT	⊕	CONCRETE	CONCRETE	+	HYDRANT	+
⊗	VALVE	⊗	ASPHALT	ASPHALT	⊗	VALVE	⊗
300 LDS	LAND DRAINAGE SEWER	300 LDS	PLANNING	PLANNING	300 mm L.D.S.	LAND DRAINAGE SEWER	300 mm L.D.S.
250 WWS	WASTE WATER SEWER	250 WWS	SIDEWALK	SIDEWALK	250 mm W.W.S.	WASTE WATER SEWER	250 mm W.W.S.
○	MANHOLE	●	PAVING STONES	PAVING STONES	—	MANHOLE	—
□	CATCH BASIN	■	PROPERTY LINE	PROPERTY LINE	—	CATCH BASIN	—
▽	CURB INLET	⊕	SURVEY BAR	SURVEY BAR	—	CURB INLET	—
●	TEST HOLES	▼	CURB RAMP	CURB RAMP	—	TEST HOLES	—
—	CULVERT	—	DITCH	DITCH	—	CULVERT	—
100 GAS	GAS	100 GAS	SWALE	SWALE	—	GAS	—
EXISTING	LEGEND-PLAN	PROPOSED	EXISTING	LEGEND-PLAN	PROPOSED	EXISTING	LEGEND-PROFILE
							PROPOSED

UNDERGROUND STRUCTURES

LOCATIONS OF UNDERGROUND STRUCTURES AS SHOWN ARE BASED ON THE BEST INFORMATION AVAILABLE BUT NO GUARANTEE IS GIVEN THAT ALL EXISTING UTILITIES ARE SHOWN OR THAT THE GIVEN LOCATIONS ARE EXACT. CONFIRMATION OF EXISTENCE AND EXACT LOCATION OF ALL SERVICES MUST BE OBTAINED FROM THE INDIVIDUAL UTILITIES BEFORE PROCEEDING WITH CONSTRUCTION.

B.M. 654008 N: 5515764.610 E: 633359.697
 ELEV. 232.463 m

DESIGNED BY: MRD
 DRAWN BY: JD
 CHECKED BY: DBW
 APPROVED BY: DPK

DESIGN TEAM: **DILLON CONSULTING**

ENGINEER'S SEAL: **DOUCET** (Member 22306)

CONSULTANT PROJECT NUMBER: **12-6606**

THE CITY OF WINNIPEG PUBLIC WORKS DEPARTMENT

WWARP III - KENASTON BLVD EXTENSION CONTRACT 3

S769 - KENASTON BLVD. S.B. NORTH OF WAVERLEY ST. OHSS AND GUARDRAIL LOCATION

CITY DRAWING NUMBER: S769-2013-01-R1
 SHEET 17 OF 23
 CONSULTANT DRAWING NUMBER

ISSUED FOR ADDENDUM 1: 13-04-23 MRD
 ISSUED FOR TENDER: 13-04-05 MRD
 ISSUED FOR 90% REVIEW: 13-02-22 MRD

NO. REVISIONS: 0
 DATE: 2013-04-05

RELEASED FOR CONSTRUCTION: DATE