


FILE NAME:

DATE: 2013.03.22


SHEET TITLE:

PROJECT No: 486-2011

ADDRESS: 989 SARGENT AVE

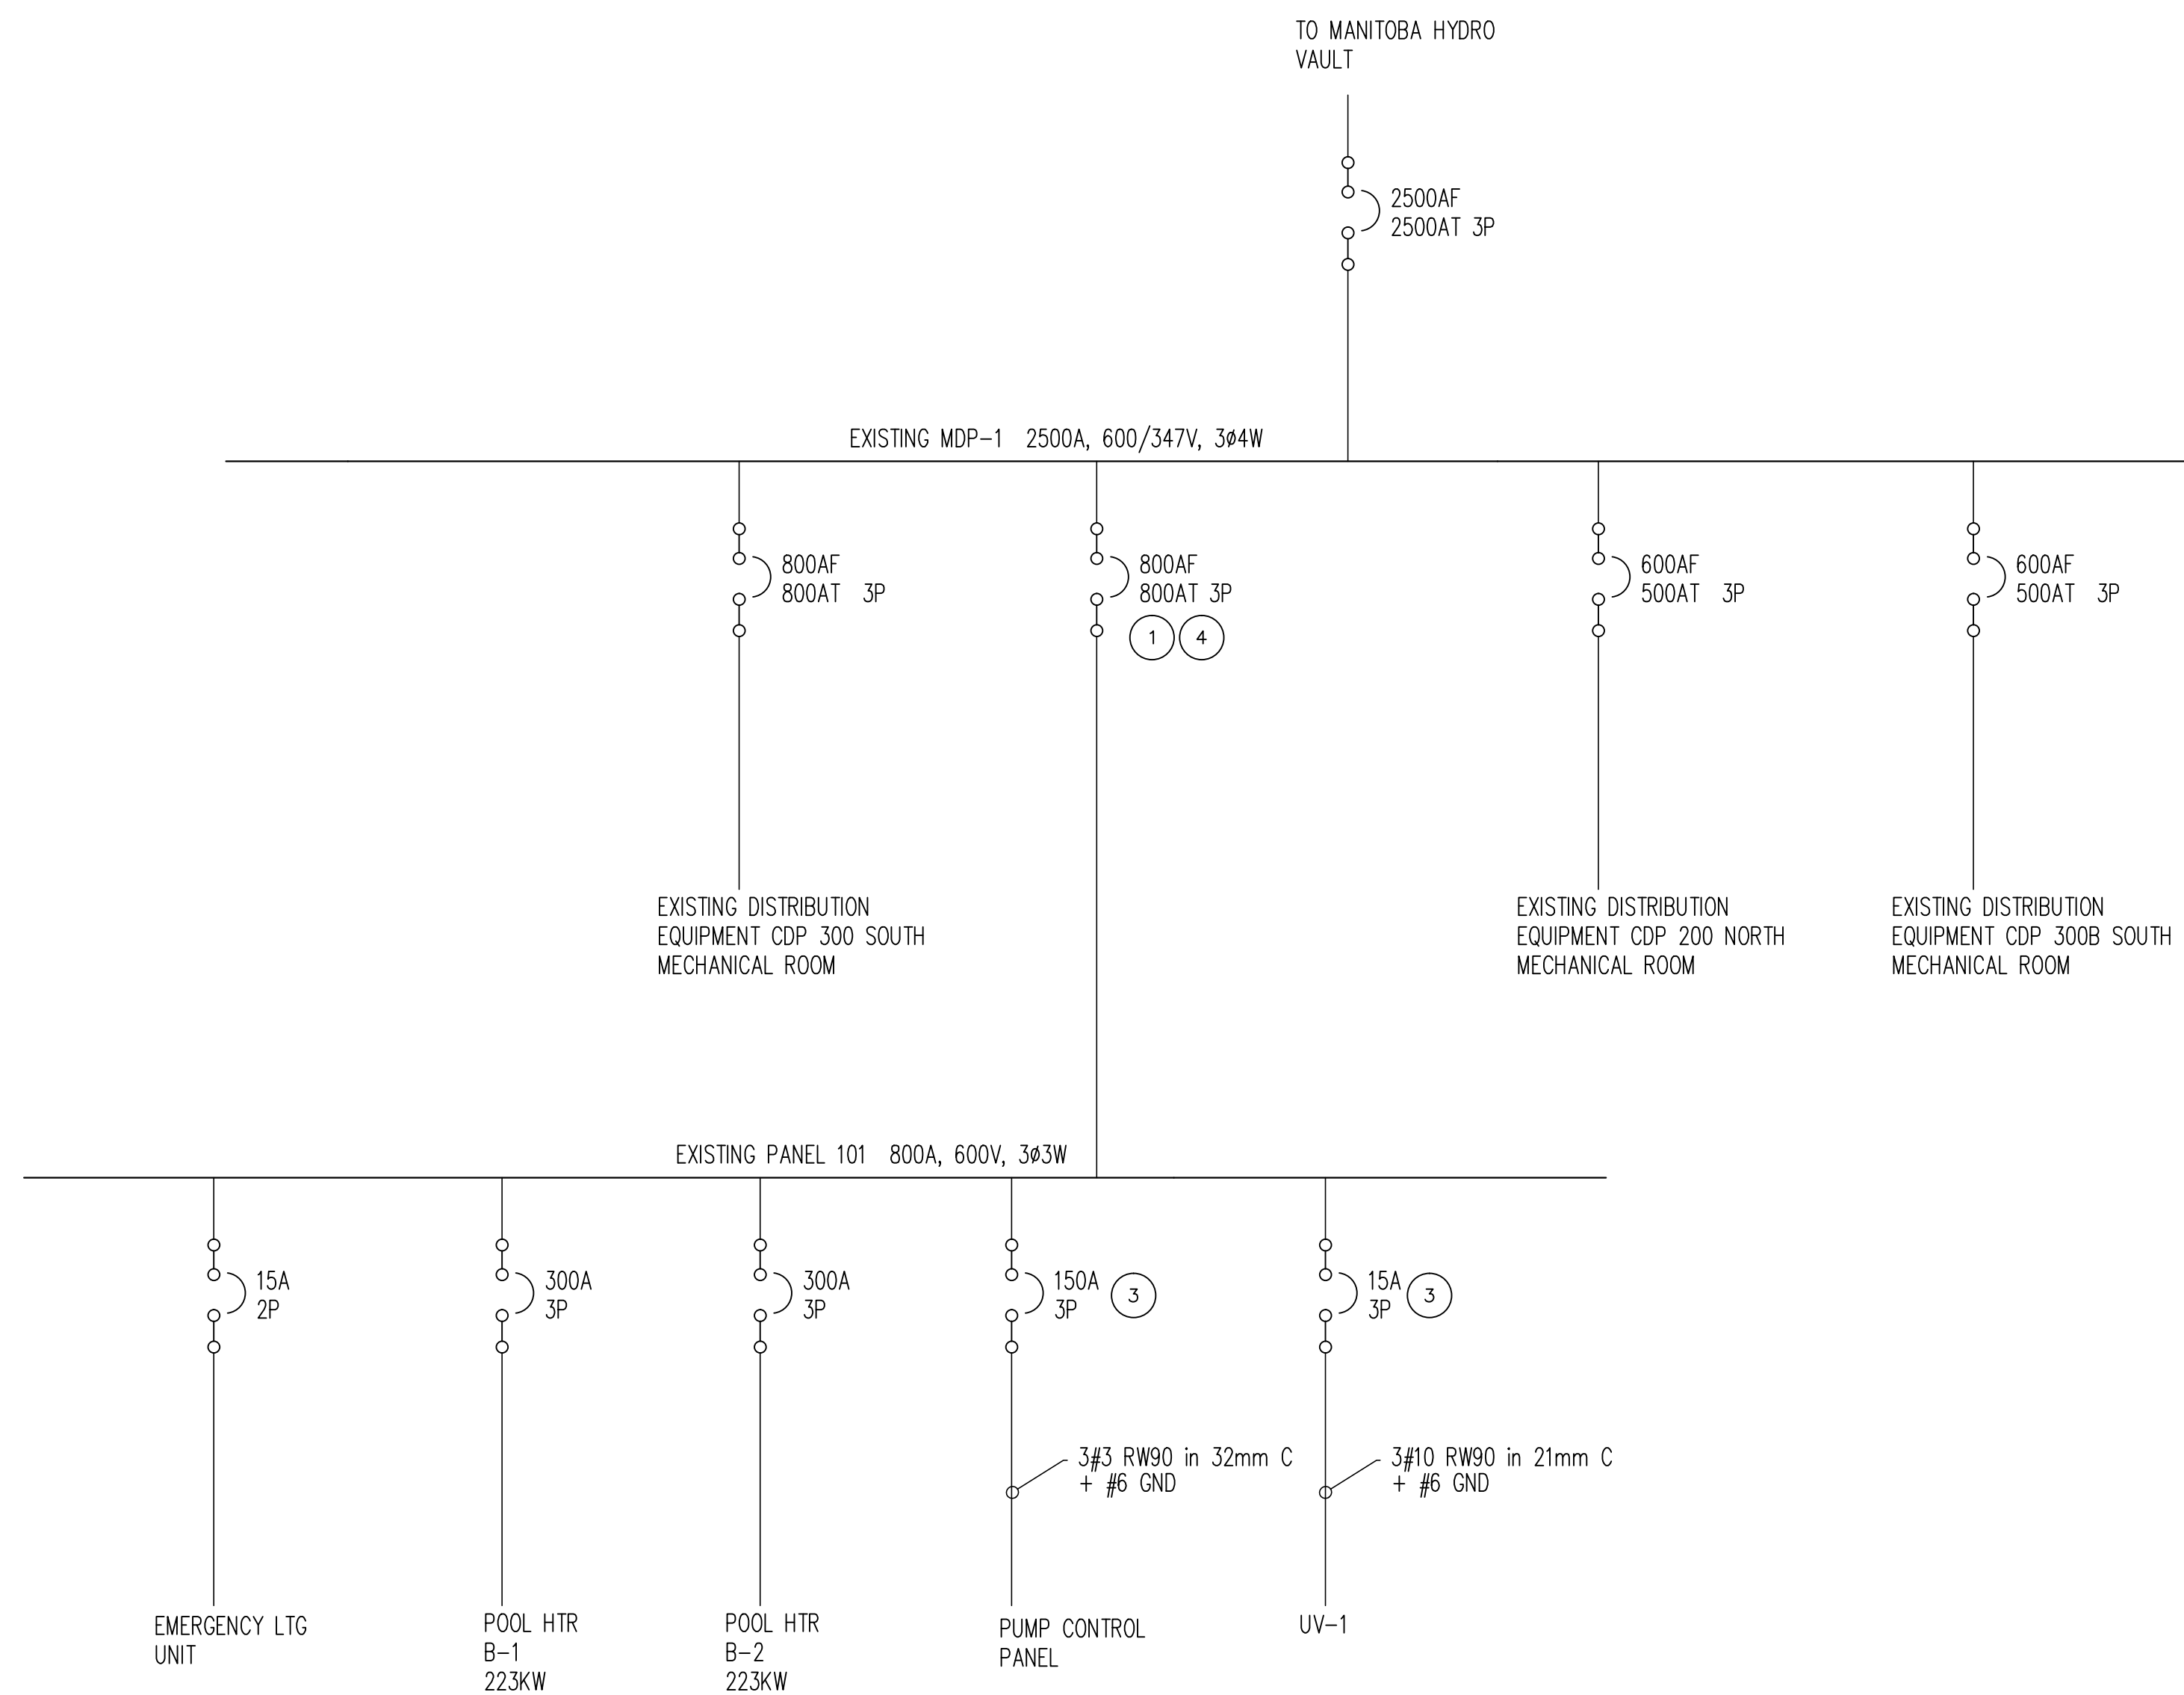




1 SINGLE LINE DIAGRAM
SCALE: NTS

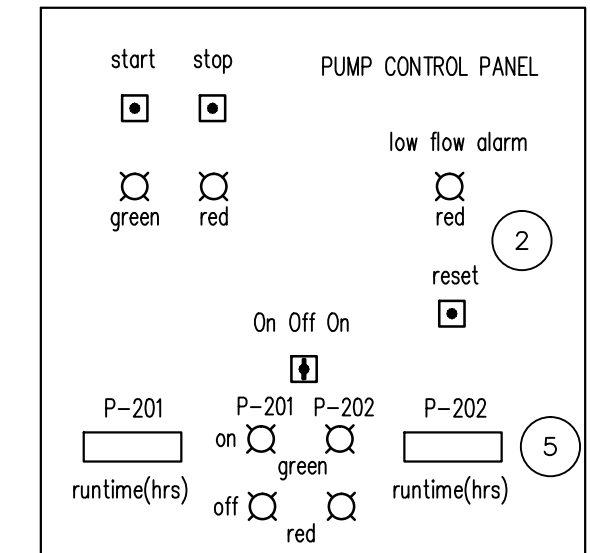

2 PUMP CONTROL PANEL
SCALE: NTS

KEY NOTES:	
1	REMOVE EXISTING 700AMP TRIP AND REPLACE WITH AN 800A UNIT.
2	CONNECT A LOW FLOW ALARM LIGHT TO ACTIVATE WHEN A LOW FLOW CONDITION IS INDICATED AT THE FLOW METER. RESET BUTTON TO ACTIVATE ONLY AFTER LOW FLOW CONDITION IS CLEARED.
3	SUPPLY AND INSTALL NEW BREAKER. ENSURE KAIC RATING MATCHES PANEL RATING. BREAKER IS TO COORDINATE WITH MAIN BREAKER.
4	EXISTING BREAKER IS A WESTINGHOUSE TRI PAC DE-ION UNIT.
5	DIGITAL RUNTIME METERS TO HAVE INTEGRAL RESET BUTTON.

NOTES:

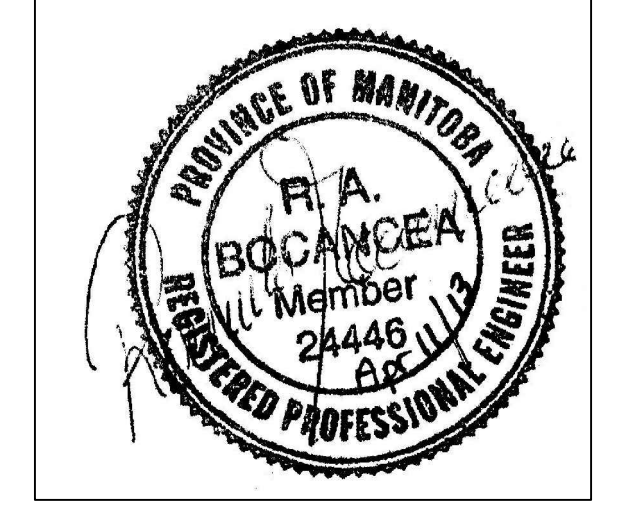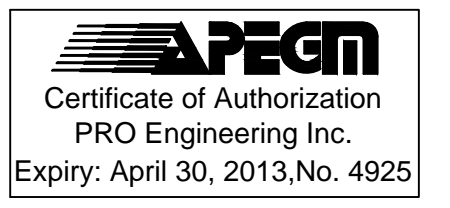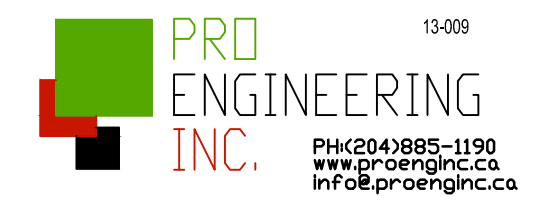

2	ISSUED FOR CONSTRUCTION	KO	13.04.11
1	ISSUED FOR CONSTRUCTION	KO	13.03.22

No.	REVISION/DESCRIPTION	BY	DATE

DRAWN	CHECKED	DESIGNED	APPROVED
KO	KO	KO	RB
DATE: 2013.03.22	USER APPROVAL		

THE CITY OF WINNIPEG
PLANNING, PROPERTY AND
DEVELOPMENT DEPARTMENT
MUNICIPAL ACCOMMODATIONS DIVISION
4TH FLOOR 185 KING STREET

PROJECT
WATER TREATMENT
PROCESS UPGRADES
BID OPPORTUNITY # 237-2013
989 SARGENT AVE

SHEET TITLE
SINGLE LINE DIAGRAM
DETAILS PLAN
ELECTRICAL

SCALE	PROJECT No:	SHEET No:
AS SHOWN	2012-140	E3.0

DRAWING SHEET SIZE: A1 (841mm x 594mm) PLOT 1:1