


1 PARTIAL FLOOR PLAN - ELECTRICAL - DEMOLITION  
SCALE: 3/32"=1'-0"

SYMBOL LEGEND	
	GFI DUPLEX RECEPTACLE (20A)
	JUNCTION BOX
	DISCONNECT
	MOTOR AND DISCONNECT
	VARIABLE FREQUENCY DRIVE
	SURFACE MOUNTED PANEL
WP	WEATHER PROOF

• PLEASE NOTE •  
ALL EQUIPMENT SHOWN "FADED BACK" IS EXISTING TO REMAIN UNLESS OTHERWISE NOTED.  
ALL EQUIPMENT SHOWN "DASHED" IS EXISTING TO BE DEMOLISHED.

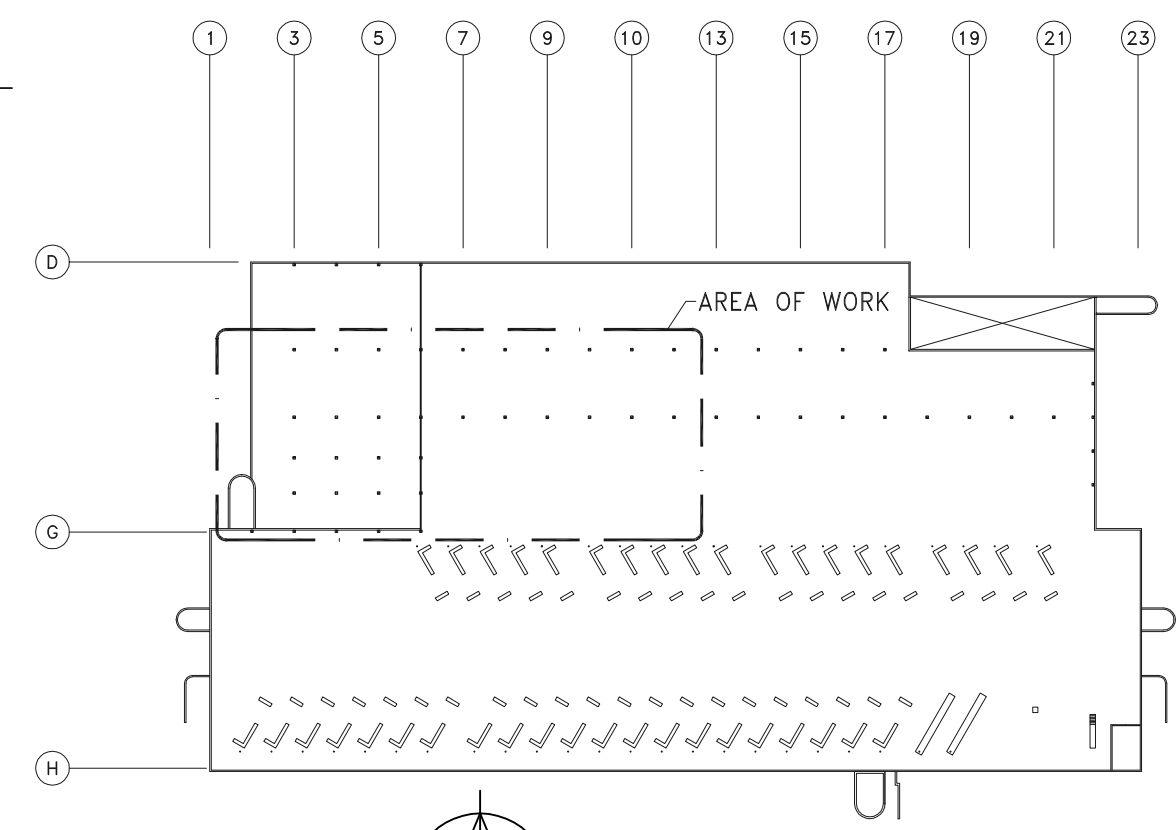

KEY PLAN  
SCALE: N.T.S.


**GENERAL NOTES**

- A. ELECTRICAL SUB-CONTRACTOR TO VISIT SITE DURING BID AND VERIFY ALL EXISTING SERVICES ON SITE PRIOR TO SUBMITTING BID. REPORT ANY DISCREPANCIES TO CONTRACT ADMINISTRATOR DURING BID PERIOD.
- B. ELECTRICAL SUB-CONTRACTOR SHALL ENSURE COORDINATION BETWEEN ALL TRADES AND CONTRACT ADMINISTRATOR, ON AND OFF SITE, AS REQUIRED FOR INSTALLATION OF ELECTRICAL EQUIPMENT.

**DEMOLITION KEY NOTES** ##

- 1. DISCONNECT EXISTING MOTORIZED DAMPER. REMOVE ALL WIRING AND CONDUIT NO LONGER REQUIRED BACK TO SOURCE.
- 2. DISCONNECT EXISTING EXHAUST FAN. REMOVE ALL DISCONNECTS, STARTERS, WIRING AND CONDUIT NO LONGER REQUIRED BACK TO SOURCE.

NO.	Revisions	BY	DD/MM/YY
0	ISSUED FOR BID OPPORTUNITY	DF	12/04/13
-	ISSUED FOR CLIENT REVIEW	DF	25/03/13
-	ISSUED FOR COORDINATION	DF	22/03/13

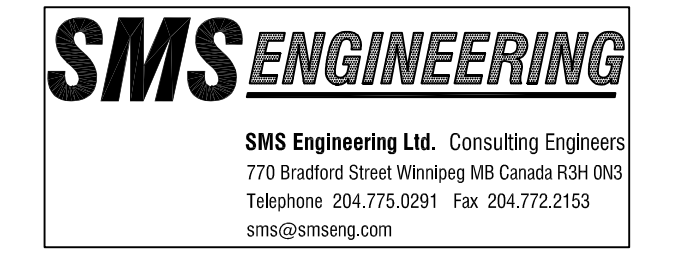

Project Title  
**CITY OF WINNIPEG  
TRANSIT GARAGE PAINT BOOTH #4  
MAKE-UP AIR UNIT REPLACEMENT  
WINNIPEG MANITOBA**

Drawing Title  
**PARTIAL FLOOR PLAN  
ELECTRICAL  
DEMOLITION**

Drawn By GB	Checked By DF	Approved By GH
Scale AS NOTED	Date APR. 2013	Project No. 13-064-01
Revision Number 0	Drawing Number E-1	Sheet Order 1 OF 2