


DETAILS

REVISIONS		
No.	DATE	DETAIL

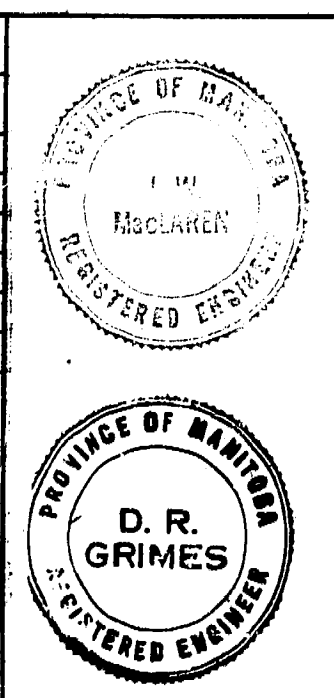

THE METROPOLITAN CORPORATION OF GREATER WINNIPEG
WATERWORKS AND WASTE DISPOSAL DIVISION
NORTH END SEWAGE TREATMENT PLANT

**CONTRACT A
SITE PLAN**

APPROVED: *James F. MacLaren*
JAMES F. MACLAREN LIMITED
ENGINEERS TORONTO

APPROVED: *A. Penman*
W.L. WARDROP ASSOCIATES
(MANAGEMENT) LIMITED
ENGINEERING CONSULTANTS WINNIPEG
DIRECTOR & CHIEF ENGINEER

DATE: MARCH 11, 1963
SCALE: 1" = 50'-0"
DWG. No. OF: 217
NEP-1

AS BUILT

FOR ACTUAL ELEV.
SUBTRACT 0.37 FT.

1" NATURAL GAS LINE
trees & high brush
LIMIT OF CONTRACT 'A'

SPUR LINE
EXISTING EXTERIOR WALL
EXISTING EXTERIOR WALL
OIL STORAGE

MONUMENT #7
V 6+02.03
S 6+51.36

D.S. PLACE MAIN
TO WEST SIDE
LIMIT.