
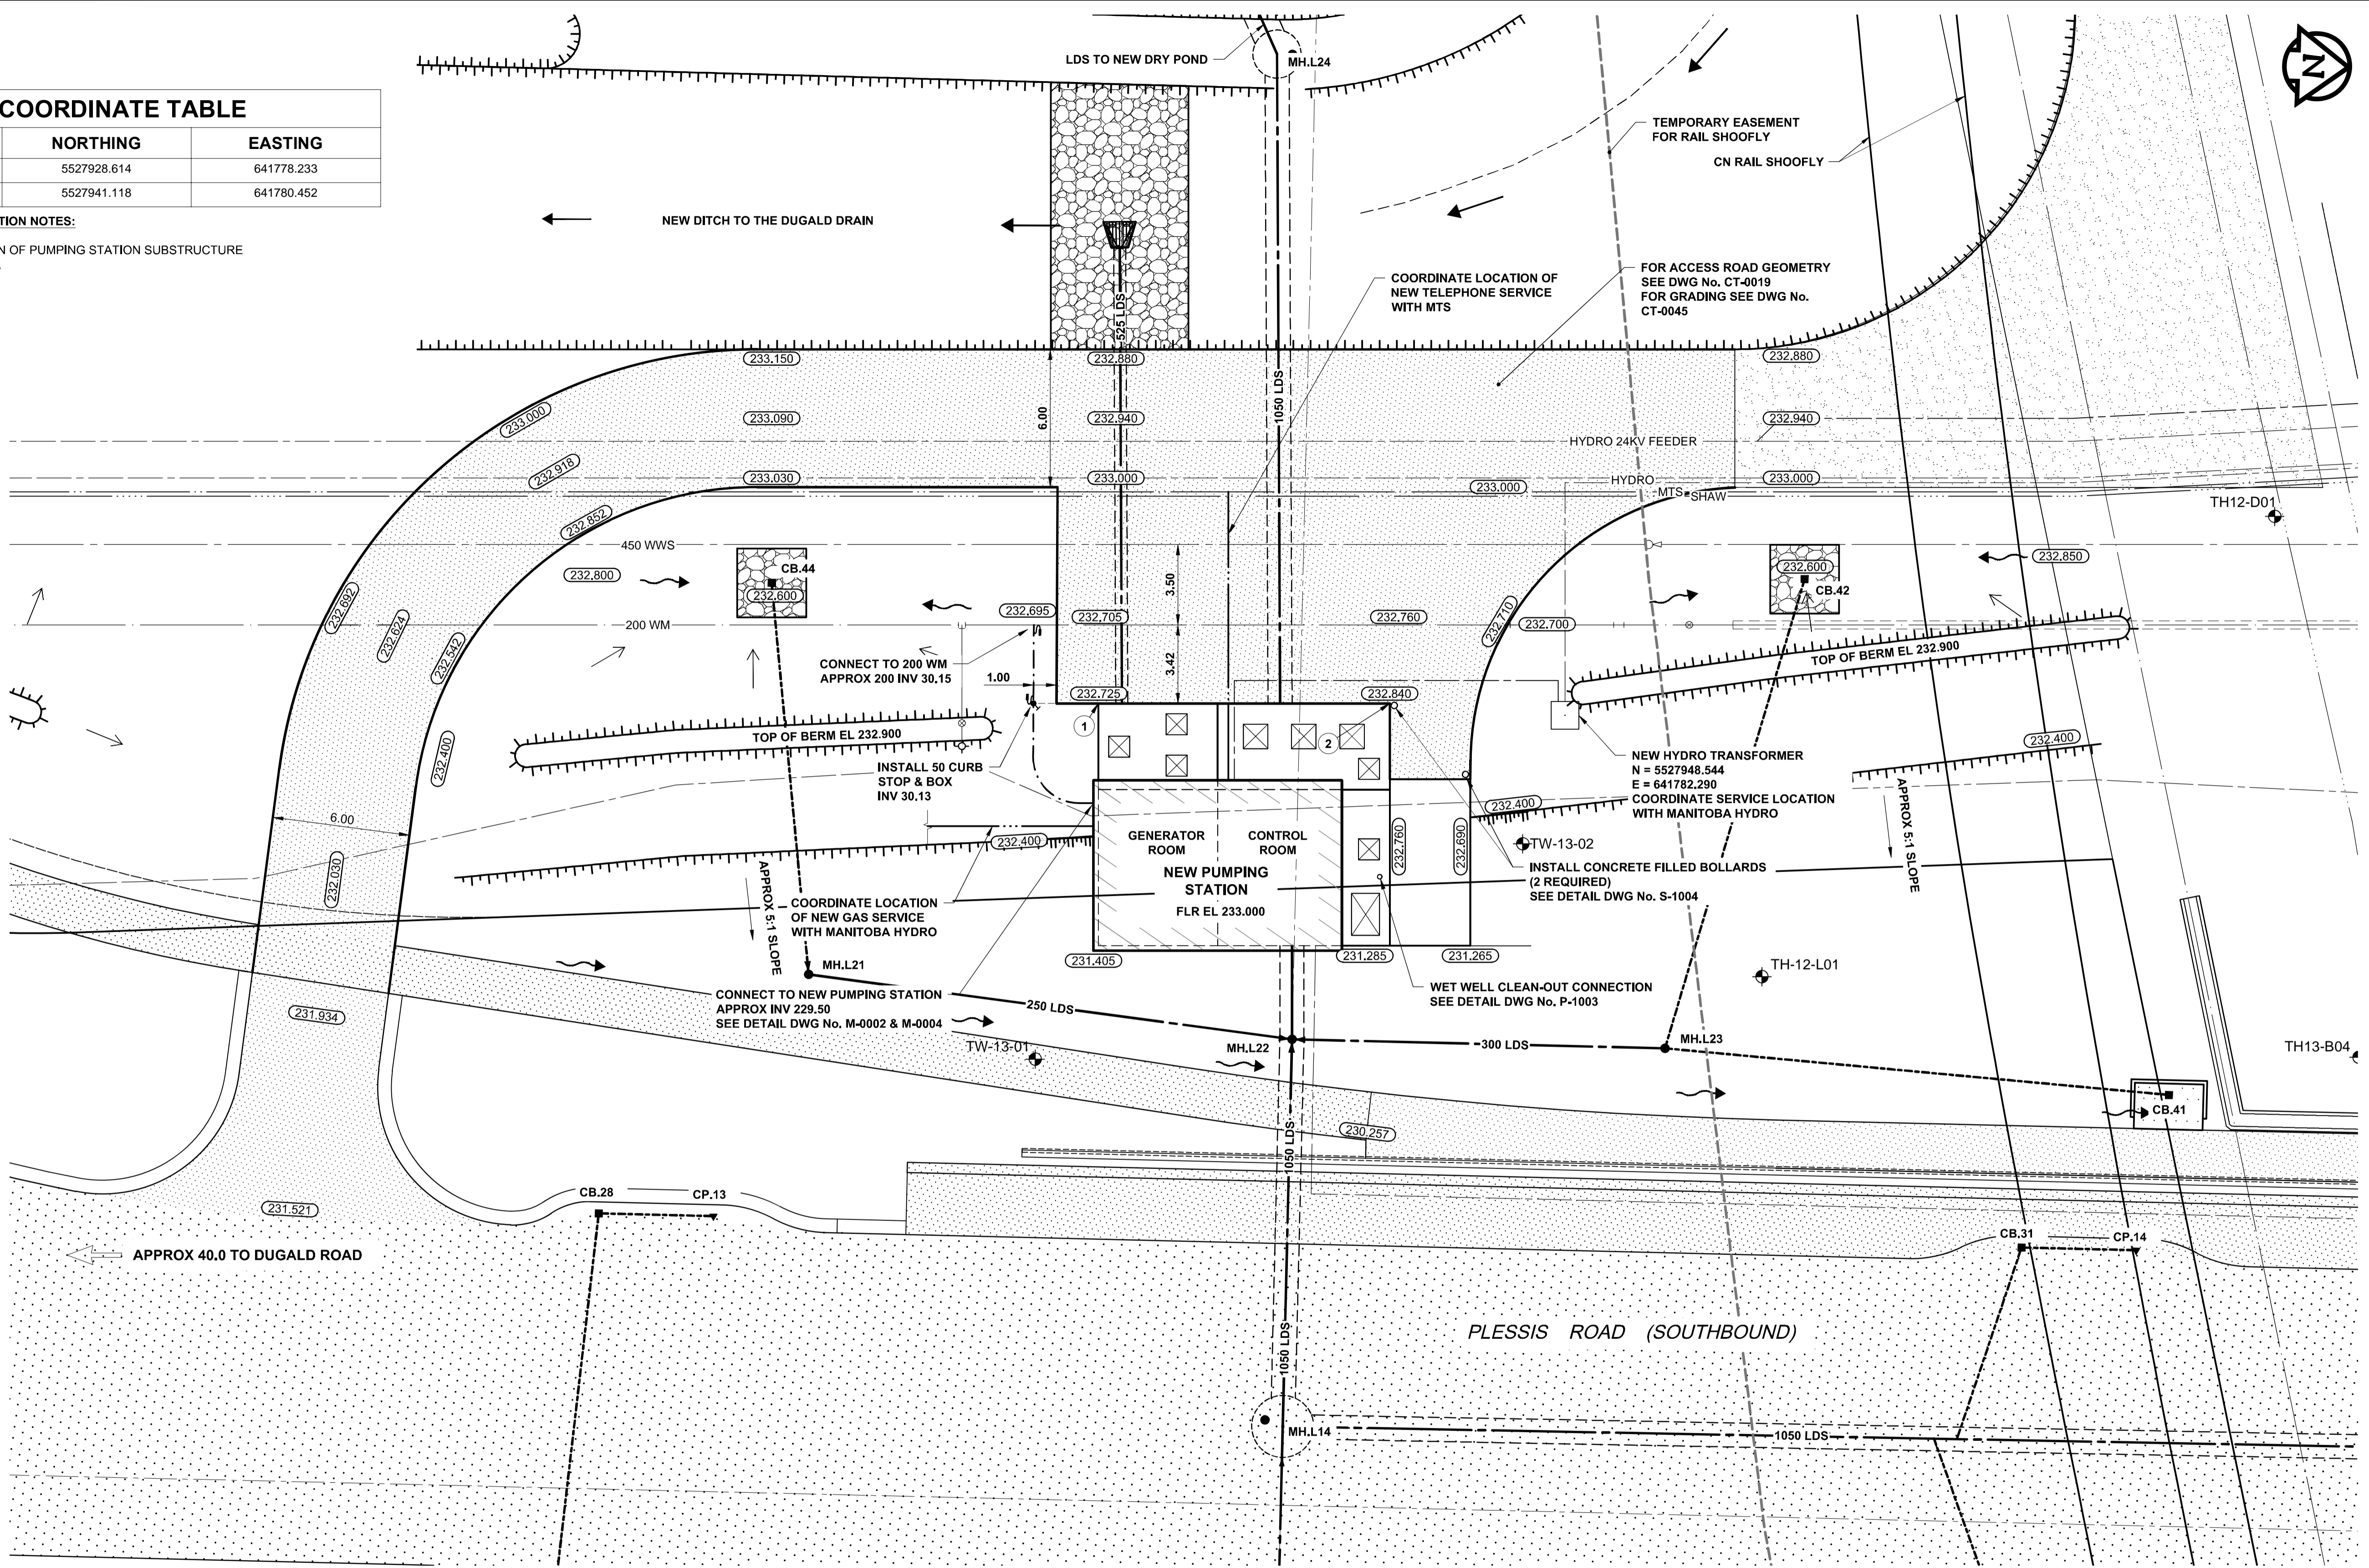


COORDINATE TABLE

POINT	NORTHING	EASTING
1	5527928.614	641778.233
2	5527941.118	641780.452

GENERAL CONSTRUCTION NOTES:


- 1. FOR CONSTRUCTION OF PUMPING STATION SUBSTRUCTURE SEE SPECIFICATION.

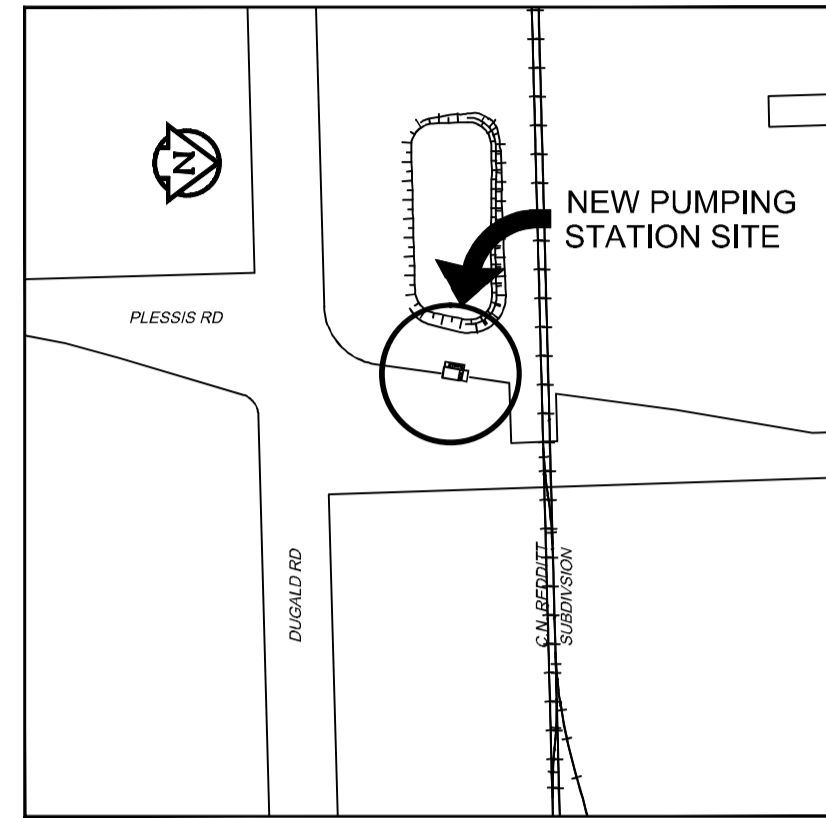

WARNING

- IF POWER EQUIPMENT OR EXPLOSIVES ARE TO BE USED FOR EXCAVATION ON THIS PROJECT, THE CONTRACTOR MUST:
- 1) NOTIFY THE GAS COMPANY OF THE PROPOSED LOCATION OF EXCAVATION.
 - 2) TAKE PRECAUTION TO AVOID DAMAGE TO GAS COMPANY INSTALLATIONS.
- SEE PROVINCIAL REGULATION 140/92 FOR DETAILS

SITE PLAN

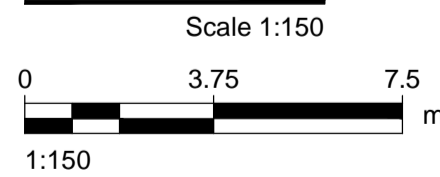

Certificate of Authorization
 AECOM Canada Ltd.
 No. 4671 Date: _____

METRIC
 WHOLE NUMBERS INDICATE MILLIMETRES
 DECIMALIZED NUMBERS INDICATE METRES

BID OPPORTUNITY NO. 712-2013

150 WM		150 WM		CURB STOP		150 WM		150 WM	
[Symbol]	WATERMAIN	[Symbol]	REDUCER	[Symbol]	REDUCER	[Symbol]	WATERMAIN	[Symbol]	WATERMAIN
[Symbol]	HYDRANT	[Symbol]	VALVE	[Symbol]	COUPLING	[Symbol]	HYDRANT	[Symbol]	HYDRANT
[Symbol]	LAND DRAINAGE SEWER	[Symbol]	300 LDS	[Symbol]	ANODE	[Symbol]	LAND DRAINAGE SEWER	[Symbol]	LAND DRAINAGE SEWER
[Symbol]	WASTE WATER SEWER	[Symbol]	250 WWS	[Symbol]	HYDRO	[Symbol]	WASTE WATER SEWER	[Symbol]	WASTE WATER SEWER
[Symbol]	MANHOLE	[Symbol]	MANHOLE	[Symbol]	MTS	[Symbol]	MANHOLE	[Symbol]	MANHOLE
[Symbol]	CATCH BASIN	[Symbol]	CATCH BASIN	[Symbol]	GAS	[Symbol]	CATCH BASIN	[Symbol]	CATCH BASIN
[Symbol]	CULVERT	[Symbol]	CULVERT	[Symbol]	TESTHOLE	[Symbol]	CULVERT	[Symbol]	CULVERT
[Symbol]	PIPE ABANDONMENTS	[Symbol]	PIPE ABANDONMENTS	[Symbol]	LAMP STANDARD	[Symbol]	PIPE ABANDONMENTS	[Symbol]	PIPE ABANDONMENTS
[Symbol]	SURVEY BAR	[Symbol]	SURVEY BAR	[Symbol]	TREE	[Symbol]	SURVEY BAR	[Symbol]	SURVEY BAR
[Symbol]	EXISTING	[Symbol]	LEGEND - PLAN	[Symbol]	NEW	[Symbol]	EXISTING	[Symbol]	LEGEND - PROFILE
[Symbol]	NEW	[Symbol]	NEW	[Symbol]	NEW	[Symbol]	NEW	[Symbol]	NEW

LOCATION APPROVED UNDERGROUND STRUCTURES

SUPV. U/G STRUCTURES COMMITTEE DATE _____

NOTE:
 LOCATION OF UNDERGROUND STRUCTURES AS SHOWN ARE BASED ON THE BEST INFORMATION AVAILABLE, BUT NO GUARANTEE IS GIVEN THAT ALL EXISTING UTILITIES ARE SHOWN OR THAT THE GIVEN LOCATIONS ARE EXACT. CONFIRMATION OF EXISTENCE AND EXACT LOCATION OF ALL SERVICES MUST BE OBTAINED FROM THE INDIVIDUAL UTILITIES BEFORE PROCEEDING WITH CONSTRUCTION.

B.M. ELEV.

NO.	REVISIONS	DATE	BY
0	ISSUED FOR TENDER	2013/11/22	KMB

AECOM

DESIGNED BY: MPG
 CHECKED BY: _____

DRAWN BY: KMB
 APPROVED BY: _____

HOR. SCALE: AS NOTED
 VERTICAL: AS NOTED
 RELEASED FOR CONSTRUCTION BY: _____

ENGINEER'S SEAL
 CONSULTANT DRAWING NO.
 60273041-SHT-01-Con3-C-1011

THE CITY OF WINNIPEG PUBLIC WORKS DEPARTMENT

PLESSIS ROAD TWINNING AND GRADE SEPARATION AT CN REDDITT SUBDIVISION CONTRACT 3

PUMPING STATION SITE PLAN

CITY DRAWING NUMBER: U238-2014-2320
 SHEET 1 OF 1

SS-0001