


AI SIZE - 594mm x 841mm

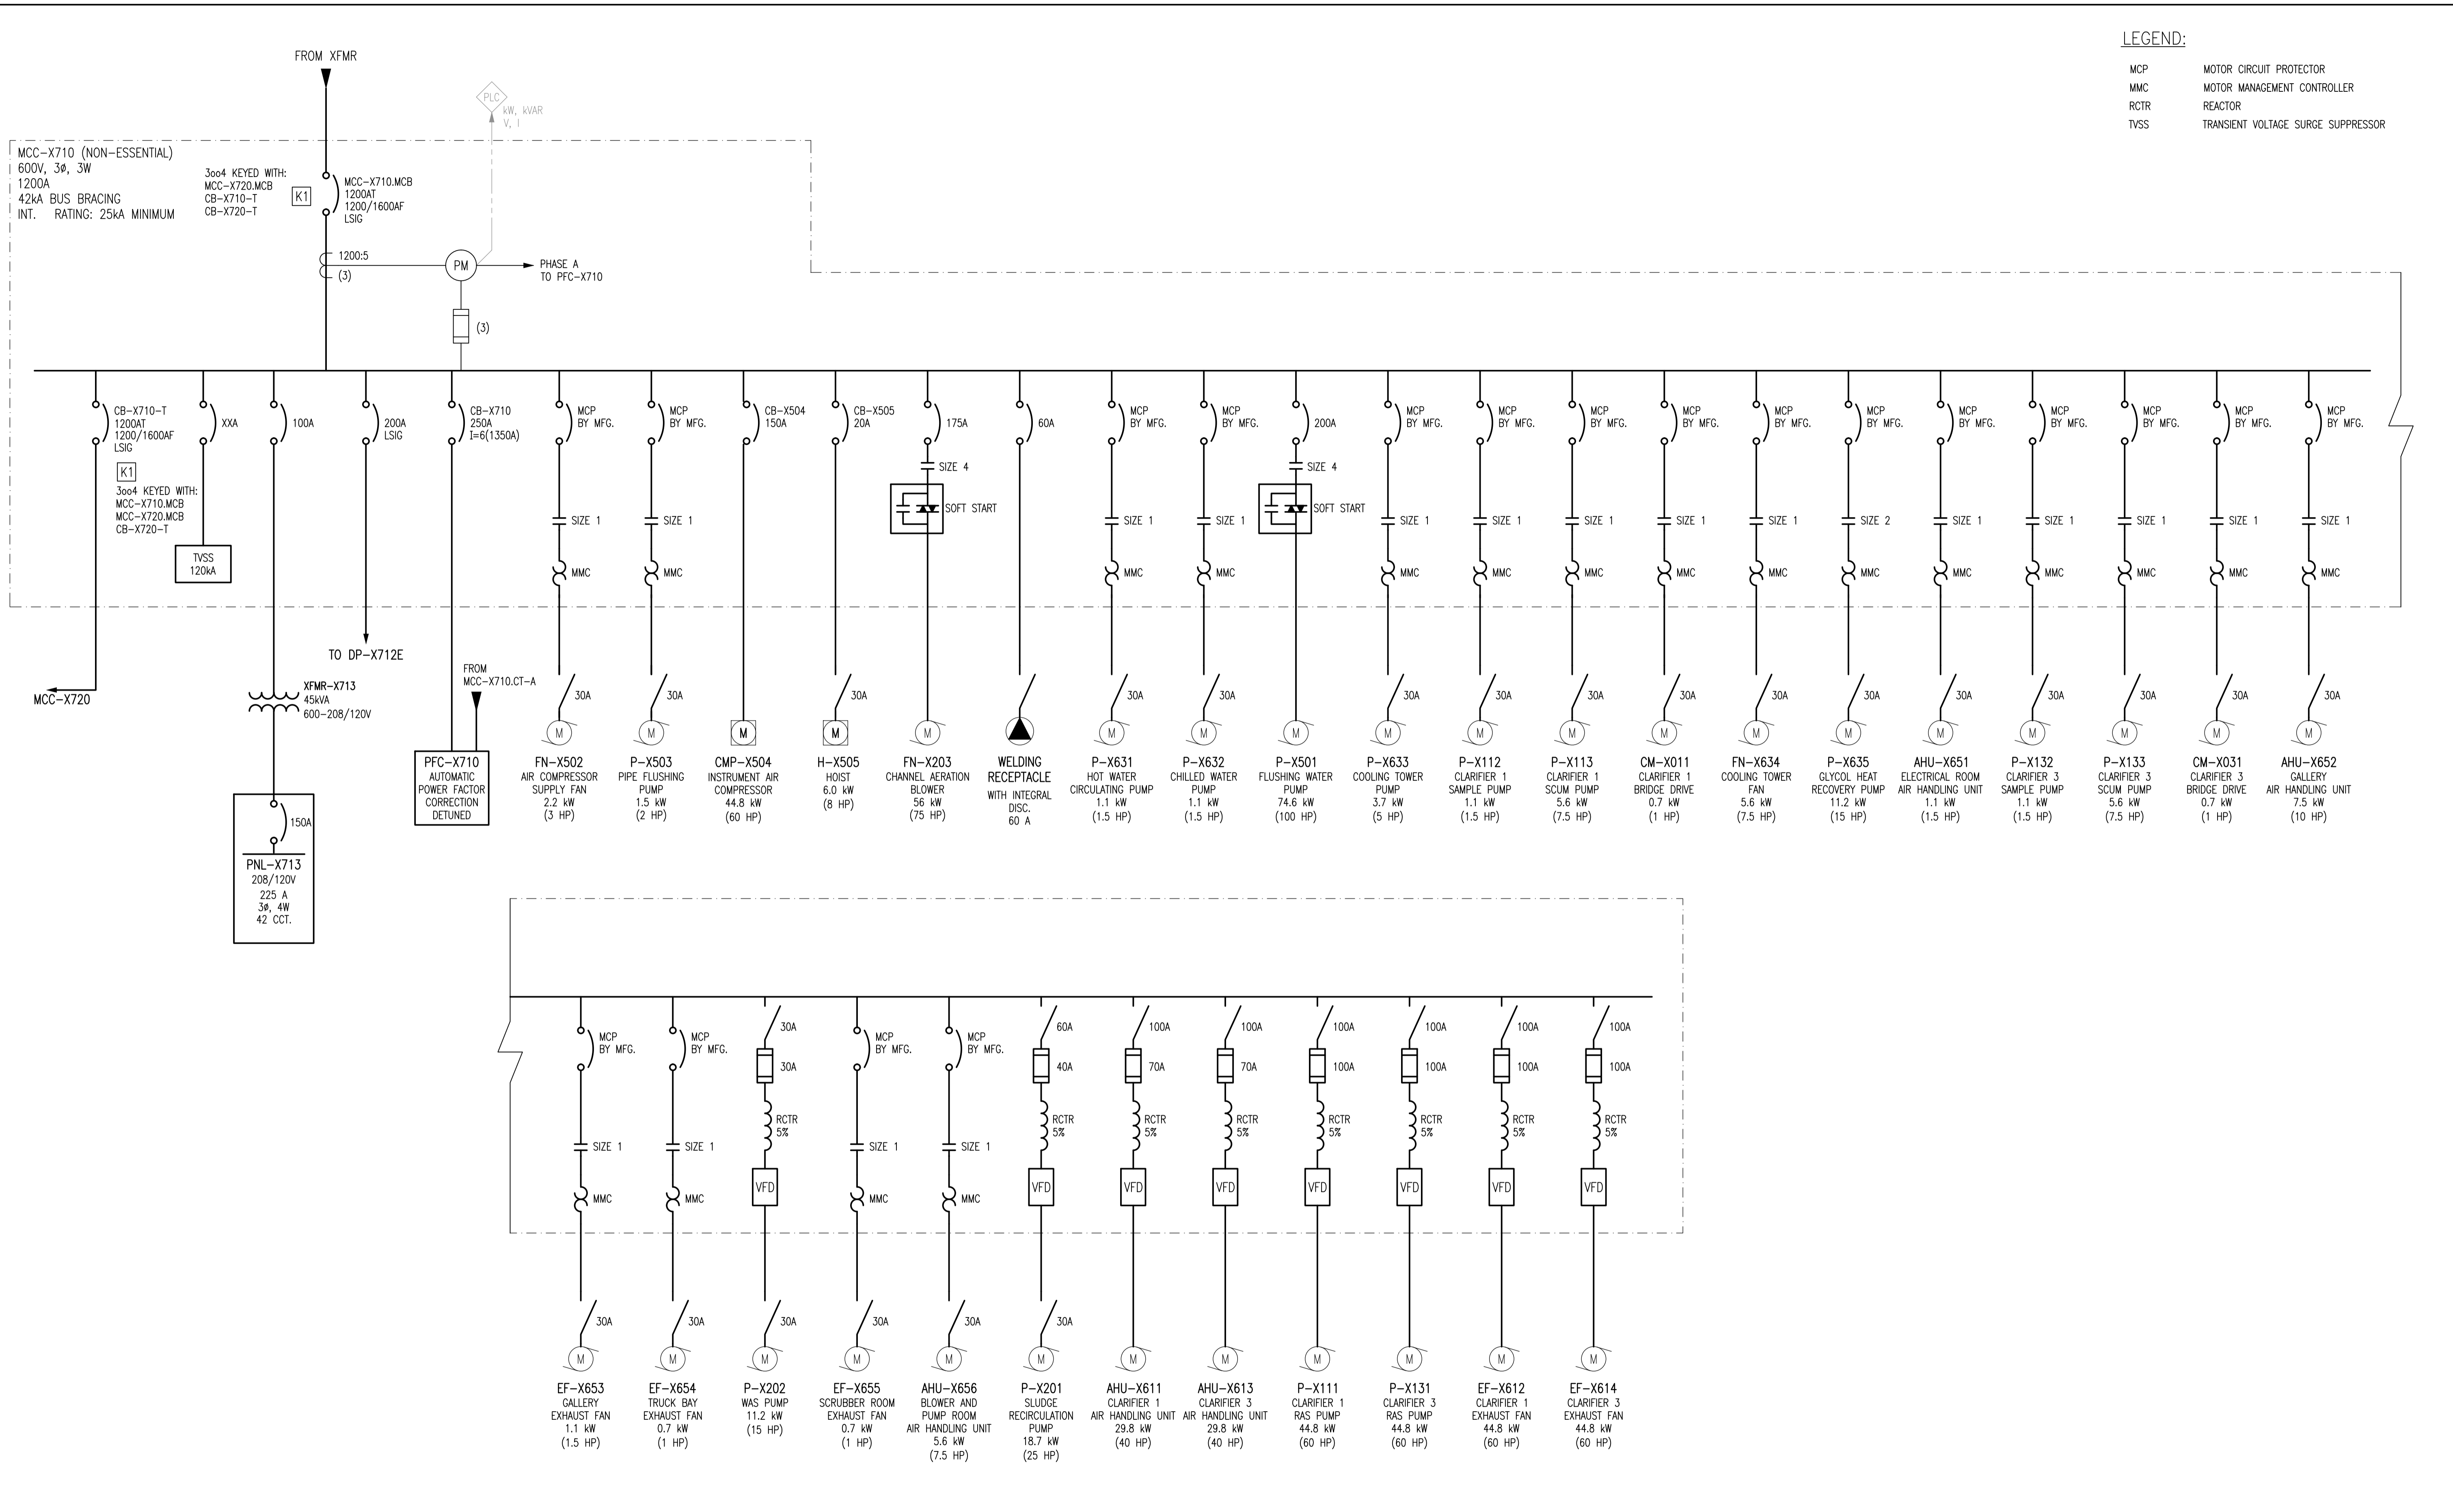

LEGEND:
 MCP MOTOR CIRCUIT PROTECTOR
 MMC MOTOR MANAGEMENT CONTROLLER
 RCTR REACTOR
 TVSS TRANSIENT VOLTAGE SURGE SUPPRESSOR

SK-E0003	MCC SCHEDULE
SK-E0002	MCC ELEVATION AND DETAILS
DRAWING NUMBER	REFERENCE DRAWINGS

APEGM
 Certificate of Authorization
SNC-Lavalin Inc.
 No. 4489

<p>SNC-Lavalin Inc. 148 Nature Park Way Winnipeg, MB, Canada R3P 0X7 204-798-8080</p>			
DESIGNED BY: I. CHURCH	CHECKED BY: C. REIMER	ENGINEER'S SEAL	
DRAWN BY: K. MOHAMMED	APPROVED BY: C. REIMER	PRELIMINARY NOT TO BE USED FOR CONSTRUCTION	
SCALE: NTS	RELEASED FOR CONSTRUCTION BY:		
DATE: 2013/05/02	DATE:		
ISSUED FOR TENDER	2013/10/30	TMC	CJR
NO. REVISIONS	DATE	DESIGN	CHECK
CONSULTANT NO.: 612620-0005-40DD-0001			

<p>THE CITY OF WINNIPEG WATER AND WASTE DEPARTMENT</p>			
WASTEWATER TREATMENT SYSTEM			
ELECTRICAL SINGLE LINE DIAGRAM MCC SYSTEM 1			
CITY DRAWING NUMBER SK-E0001	SHEET 001	REV. 00	SIZE A1

LAST SAVE: 2013/10/30 - 3:01pm
 PATH: M:\612620\0005\4EING\4EING\DD - General DWG\SK-E0001.dwg

SK-E0001.dwg