




TYPICAL ARRANGEMENT OF HEATING & VENTILATING UNIT # 1
GARAGE BUILDING
SCALE 1/2\"/>

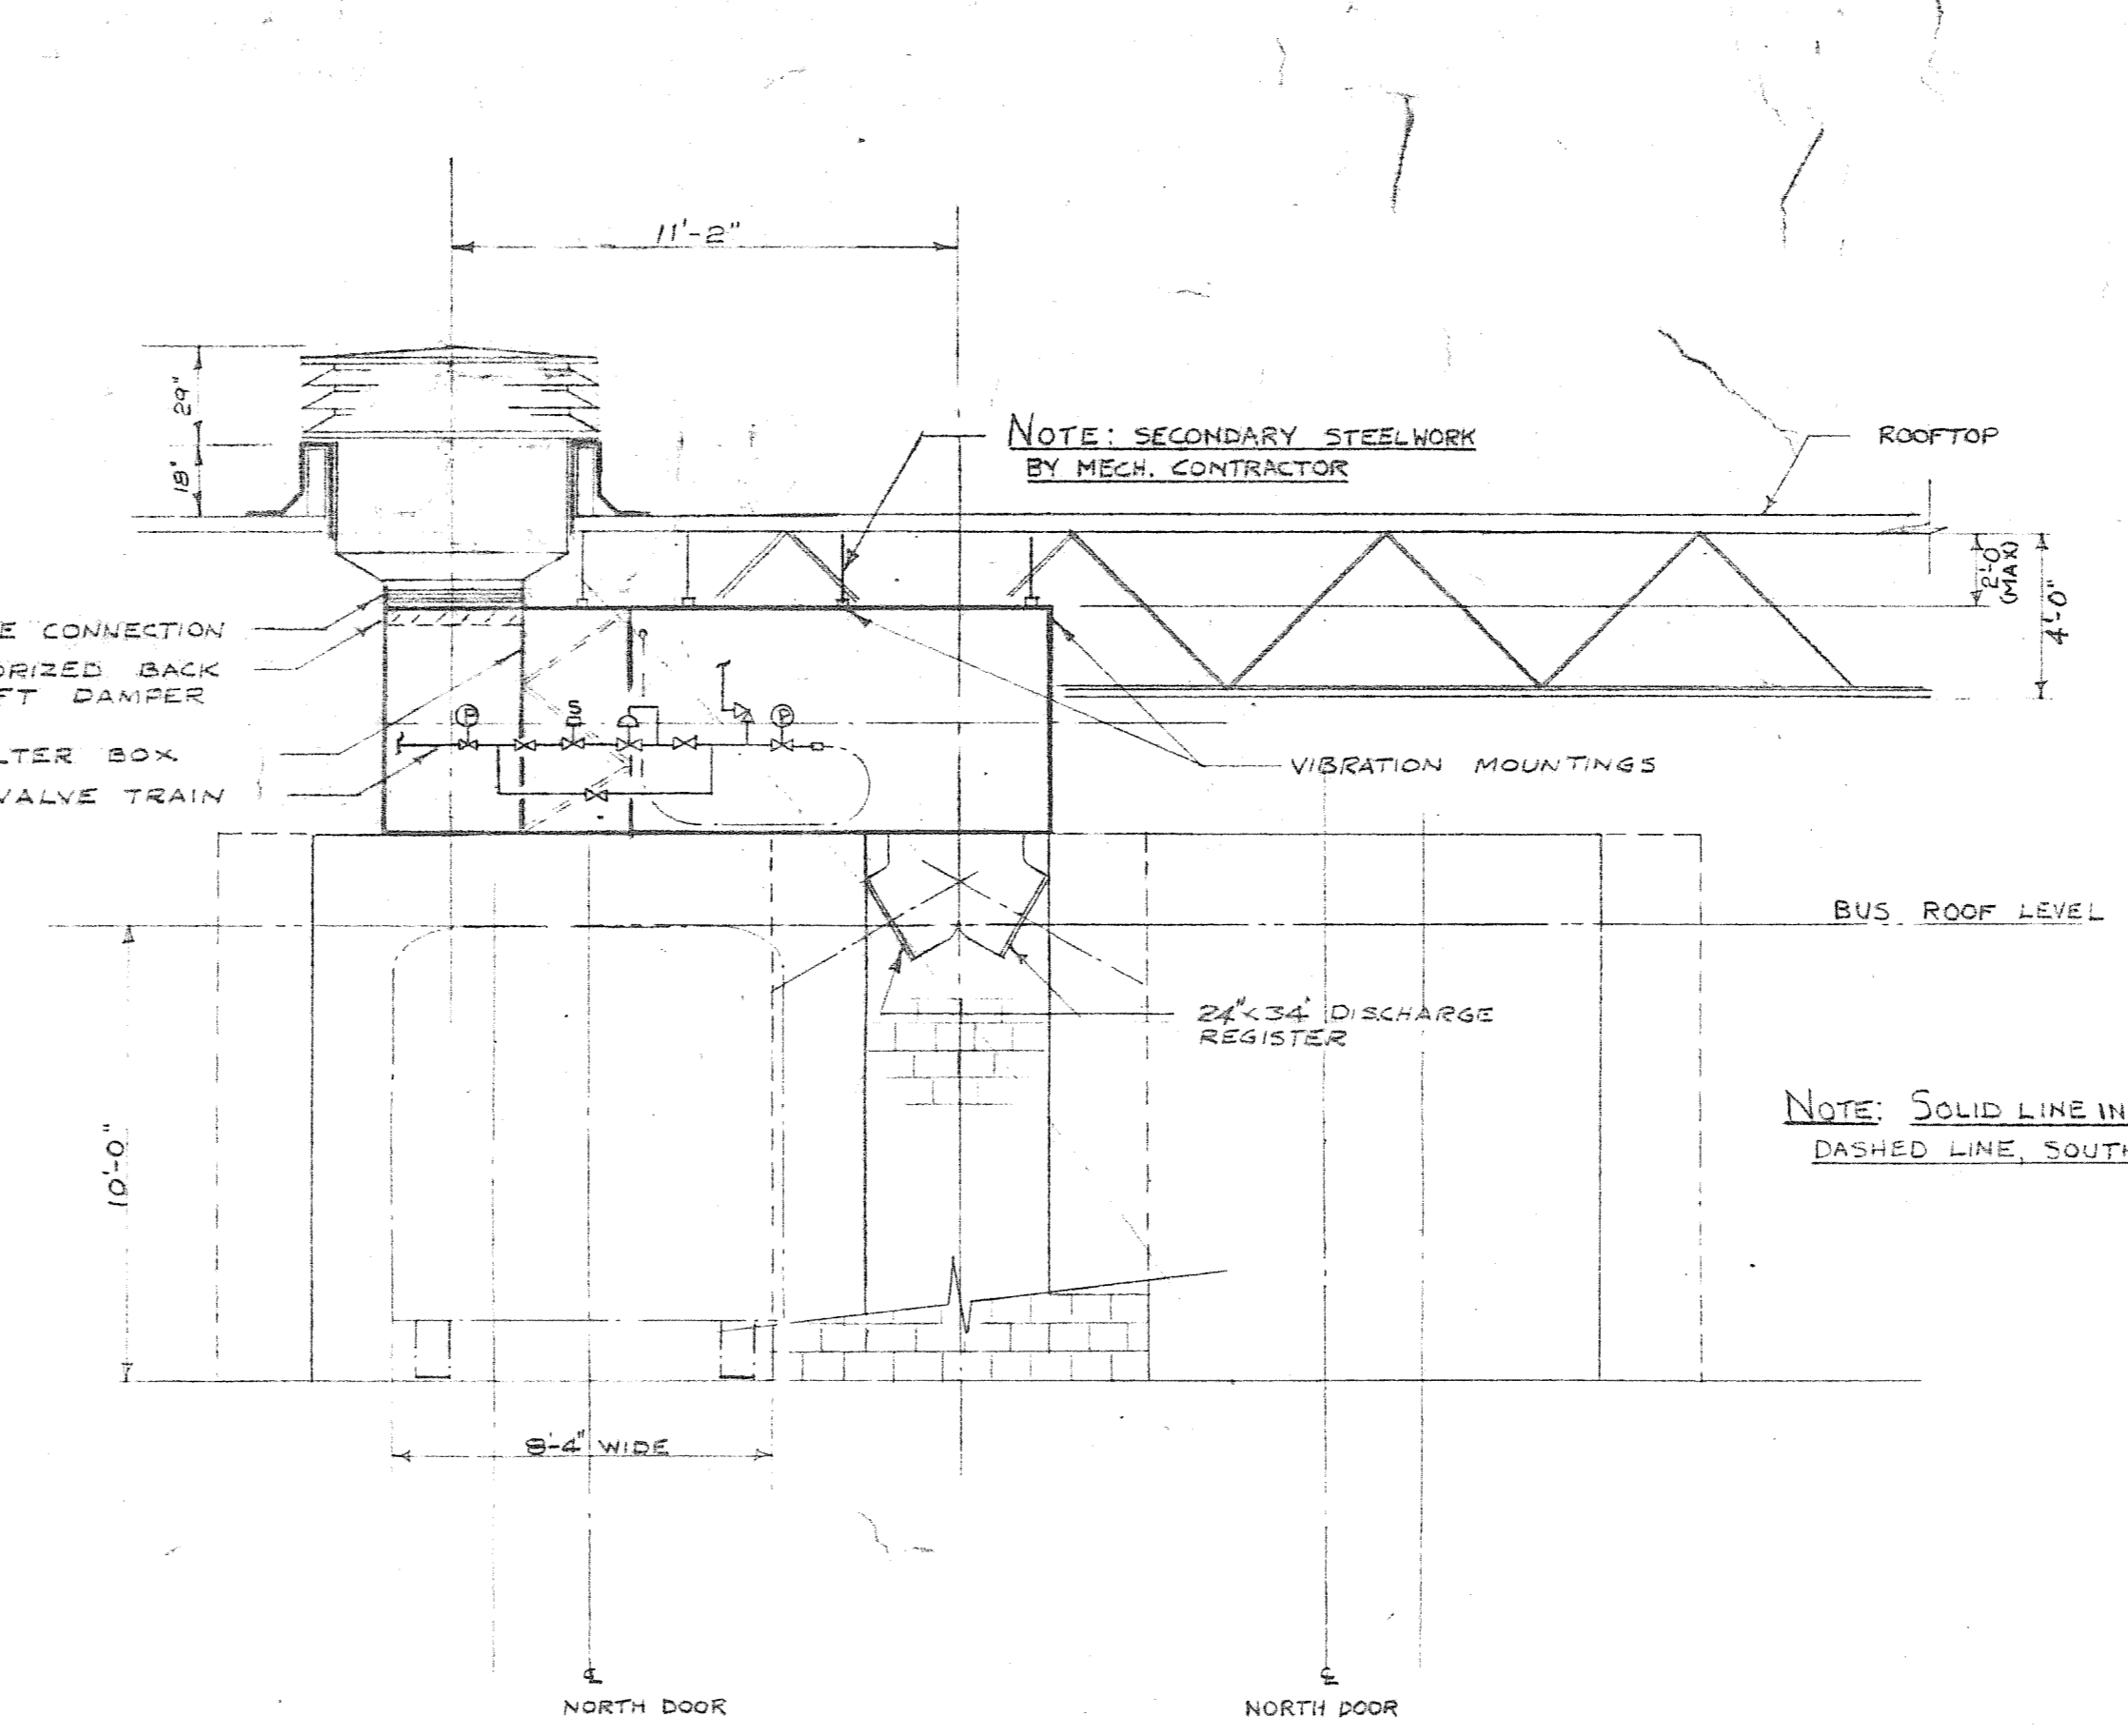


TYPICAL ARRANGEMENT OF SERVICE BAY DIRECT GAS FIRED MAKE-UP AIR UNIT
SCALE 1/2\"/>

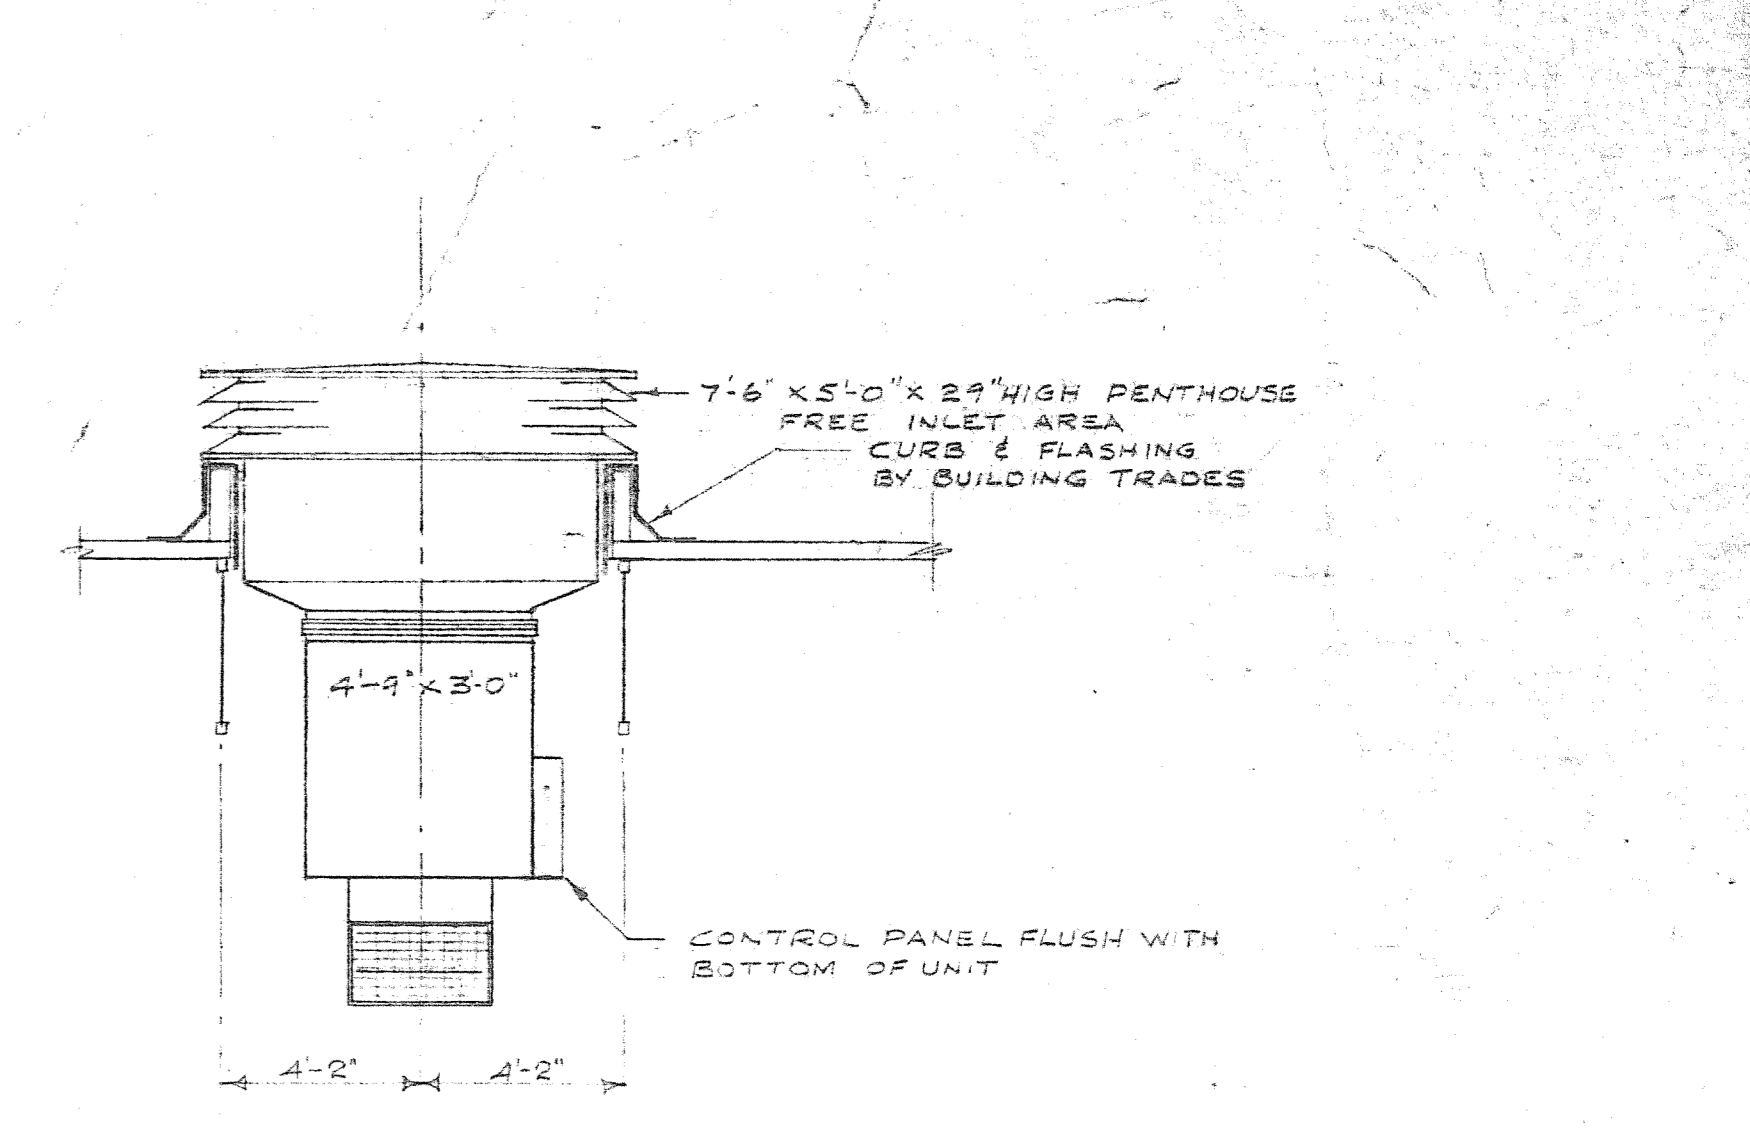


NOTE: SOLID LINE INDICATES NORTH SET OF DOORS,
DASHED LINE, SOUTH SET OF DOORS

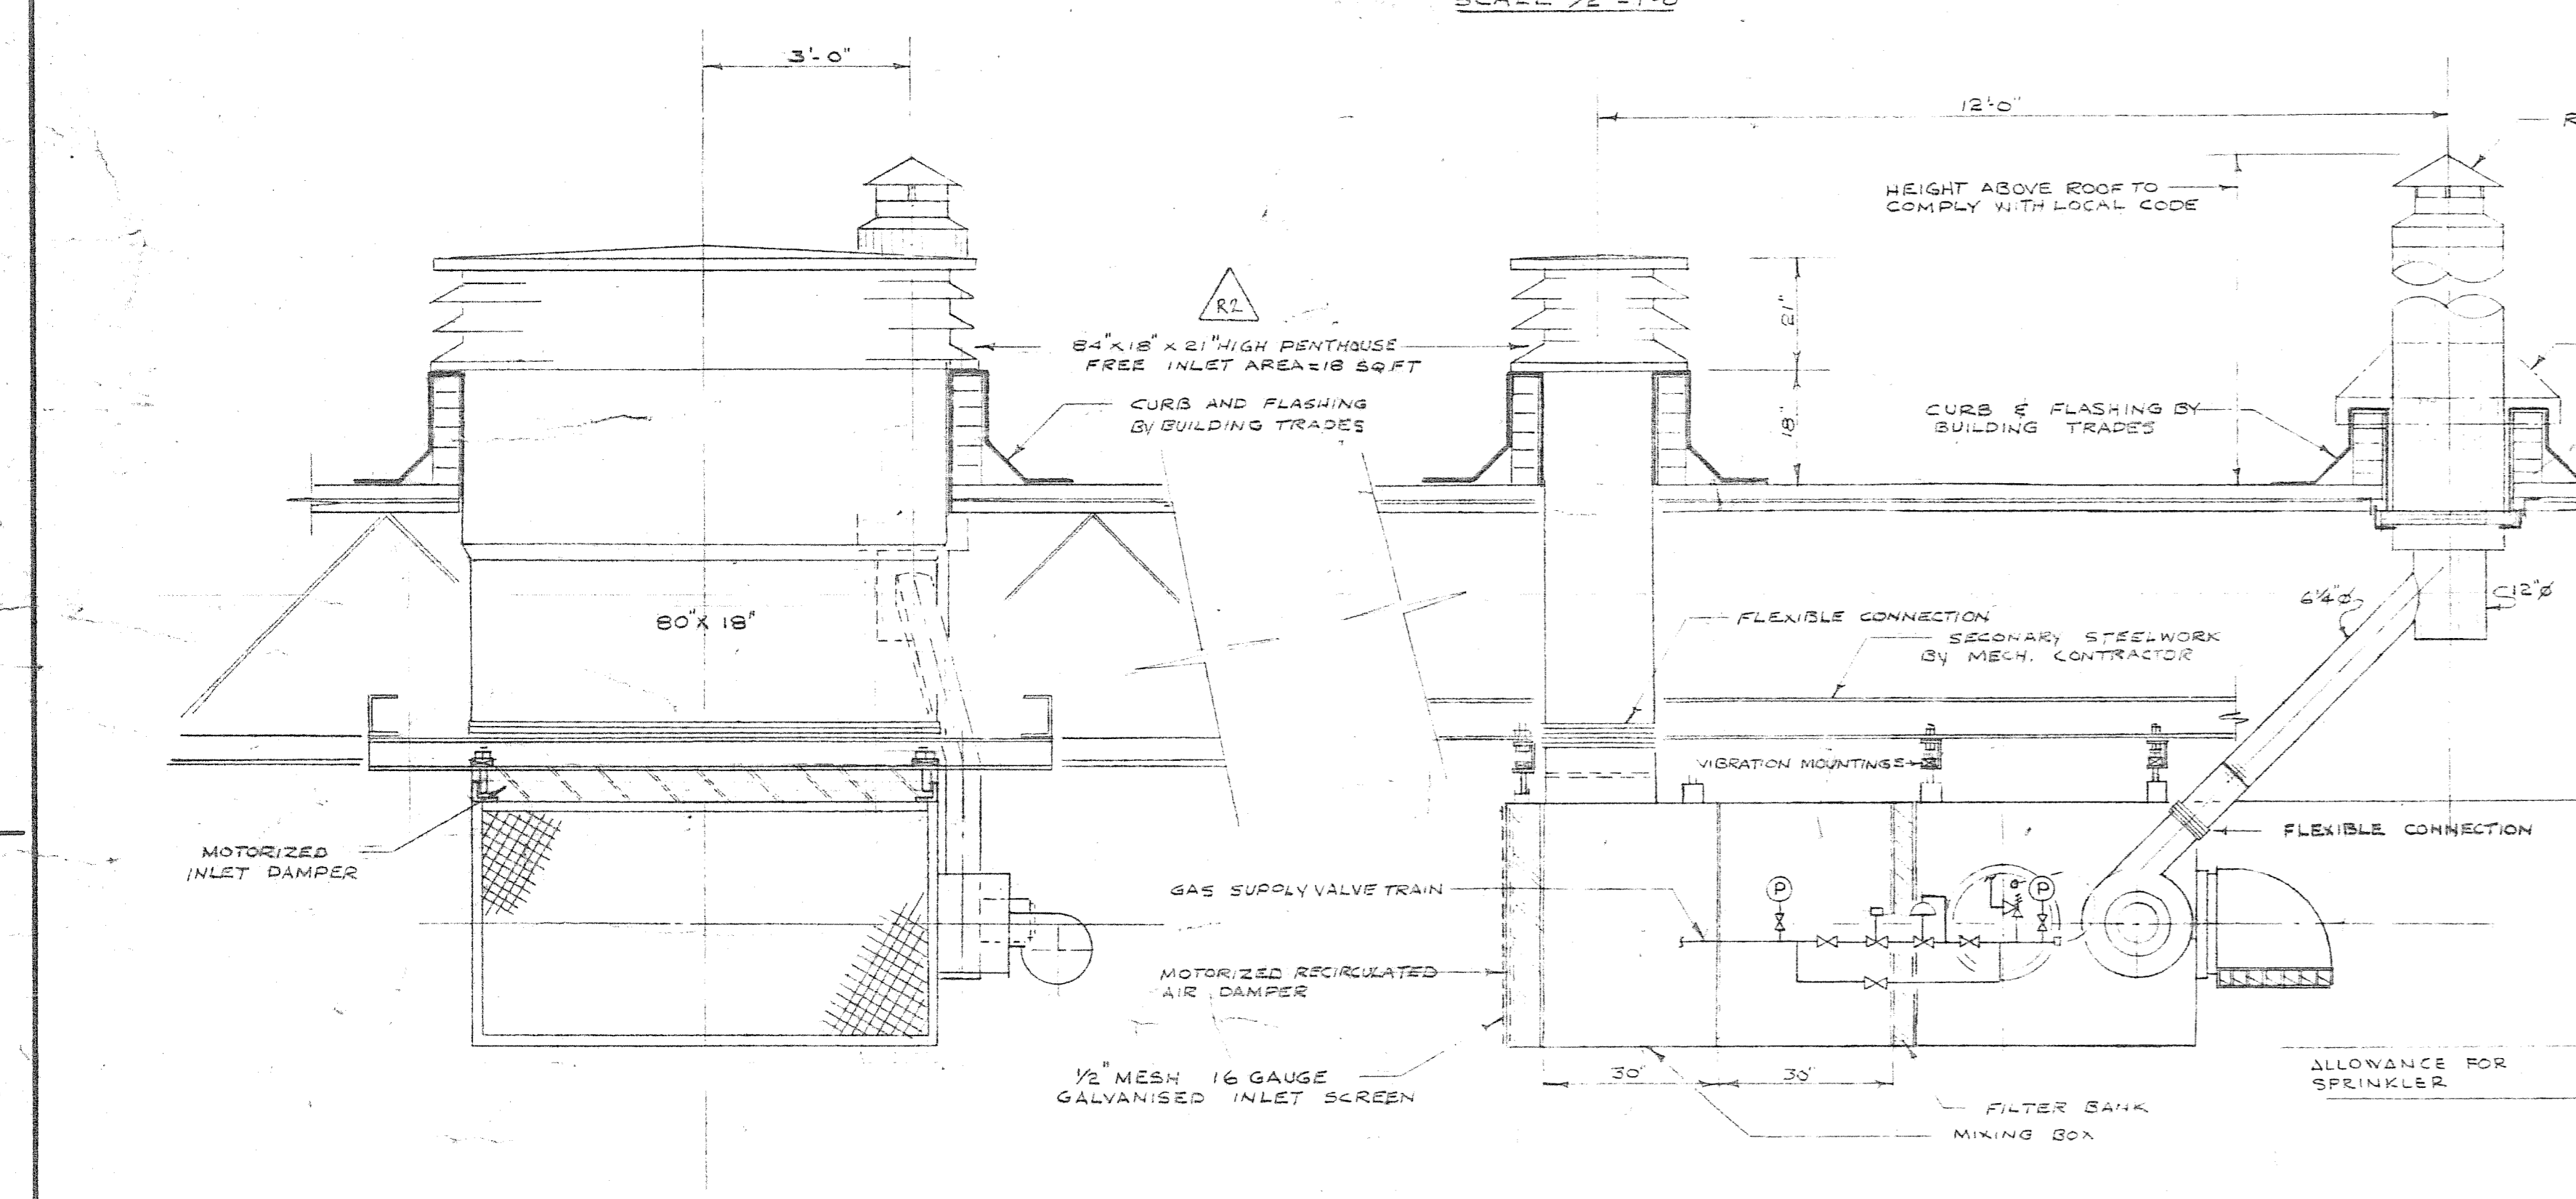


TYPICAL ARRANGEMENT OF HEATING & VENTILATING UNIT # 2
GARAGE BUILDING
SCALE 1/2\"/>

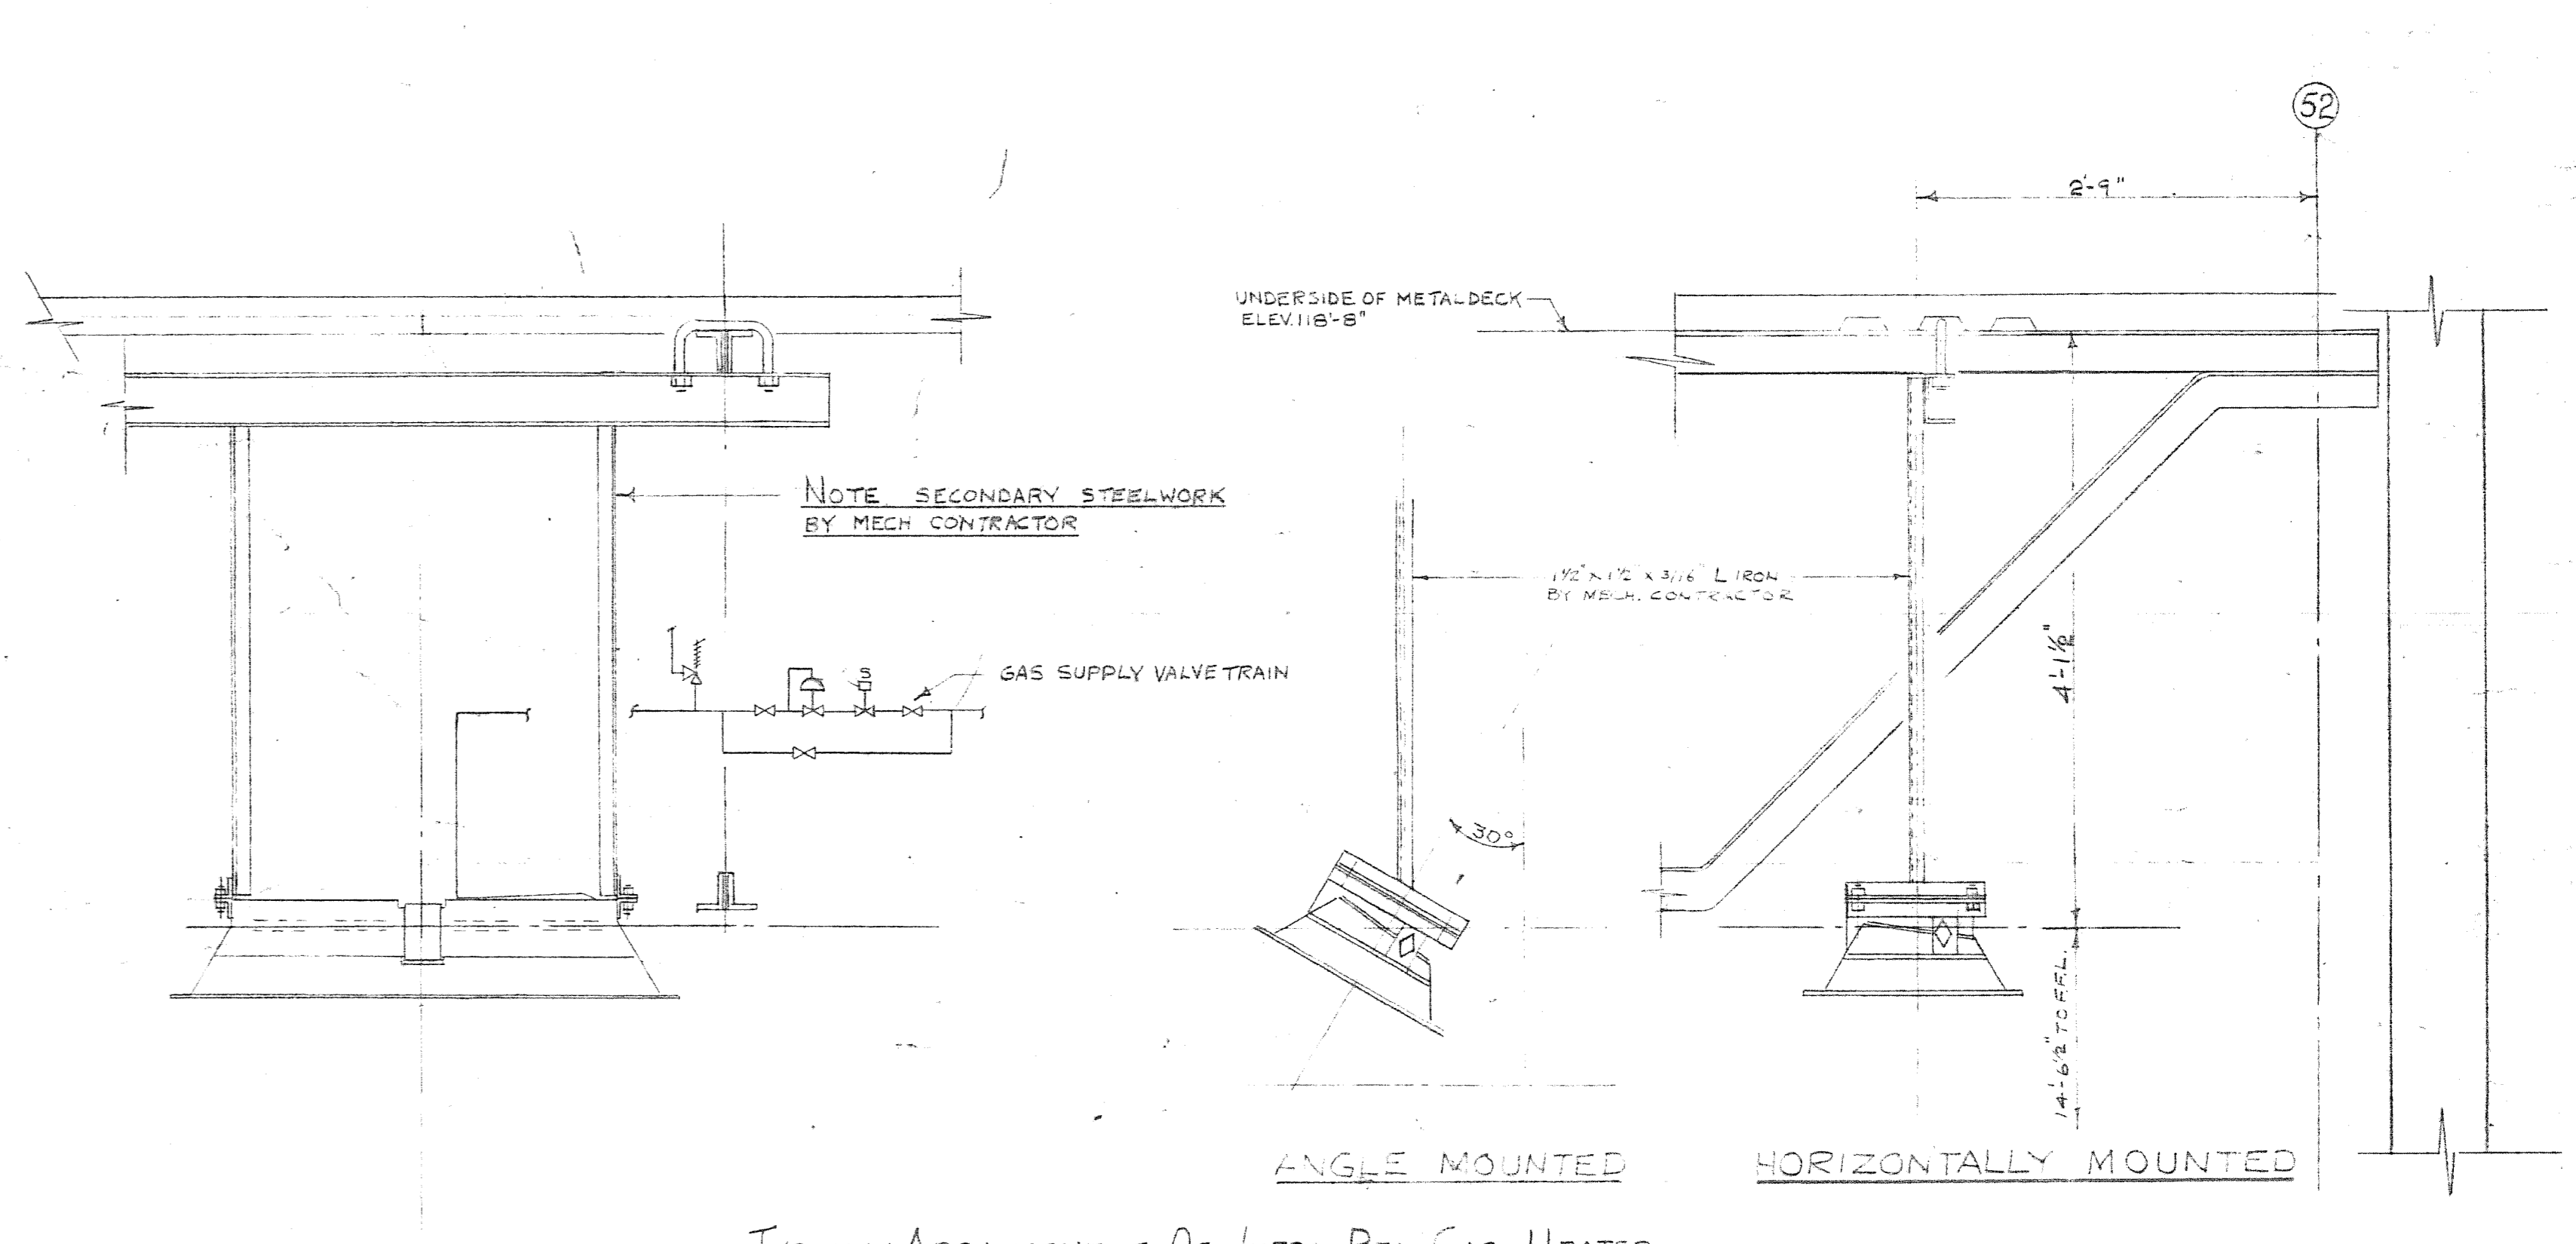


TYPICAL ARRANGEMENT OF INFRA-RED GAS HEATER
SCALE 1\"/>

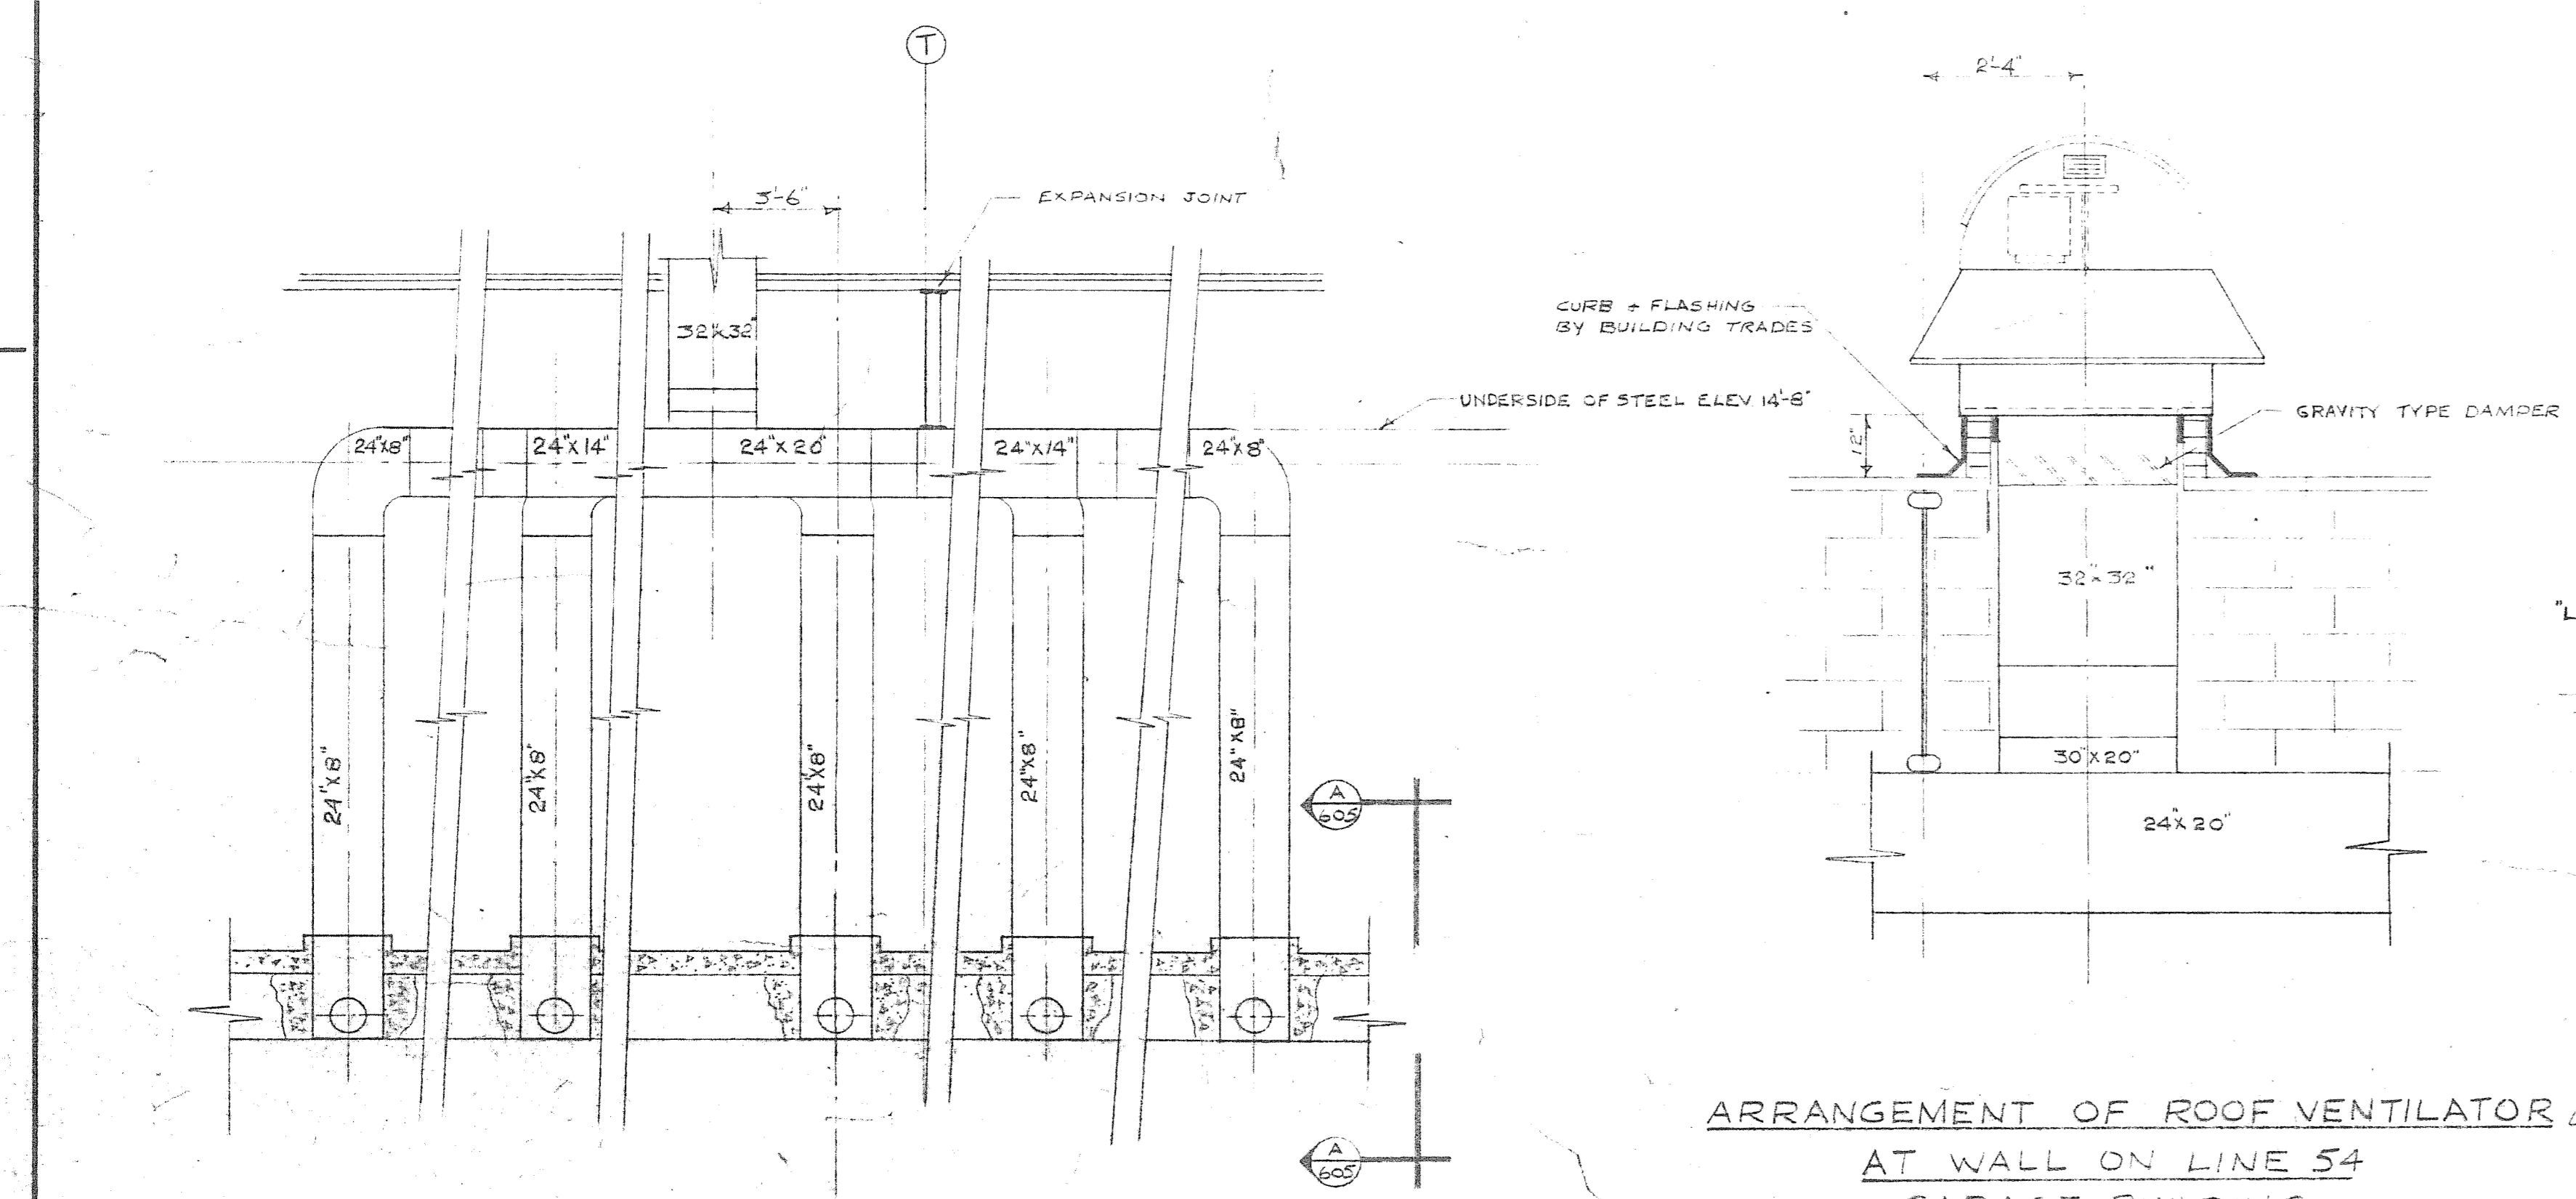

ARRANGEMENT OF ROOF VENTILATOR
AT WALL ON LINE S4
GARAGE BUILDING
SCALE 1/2\"/>

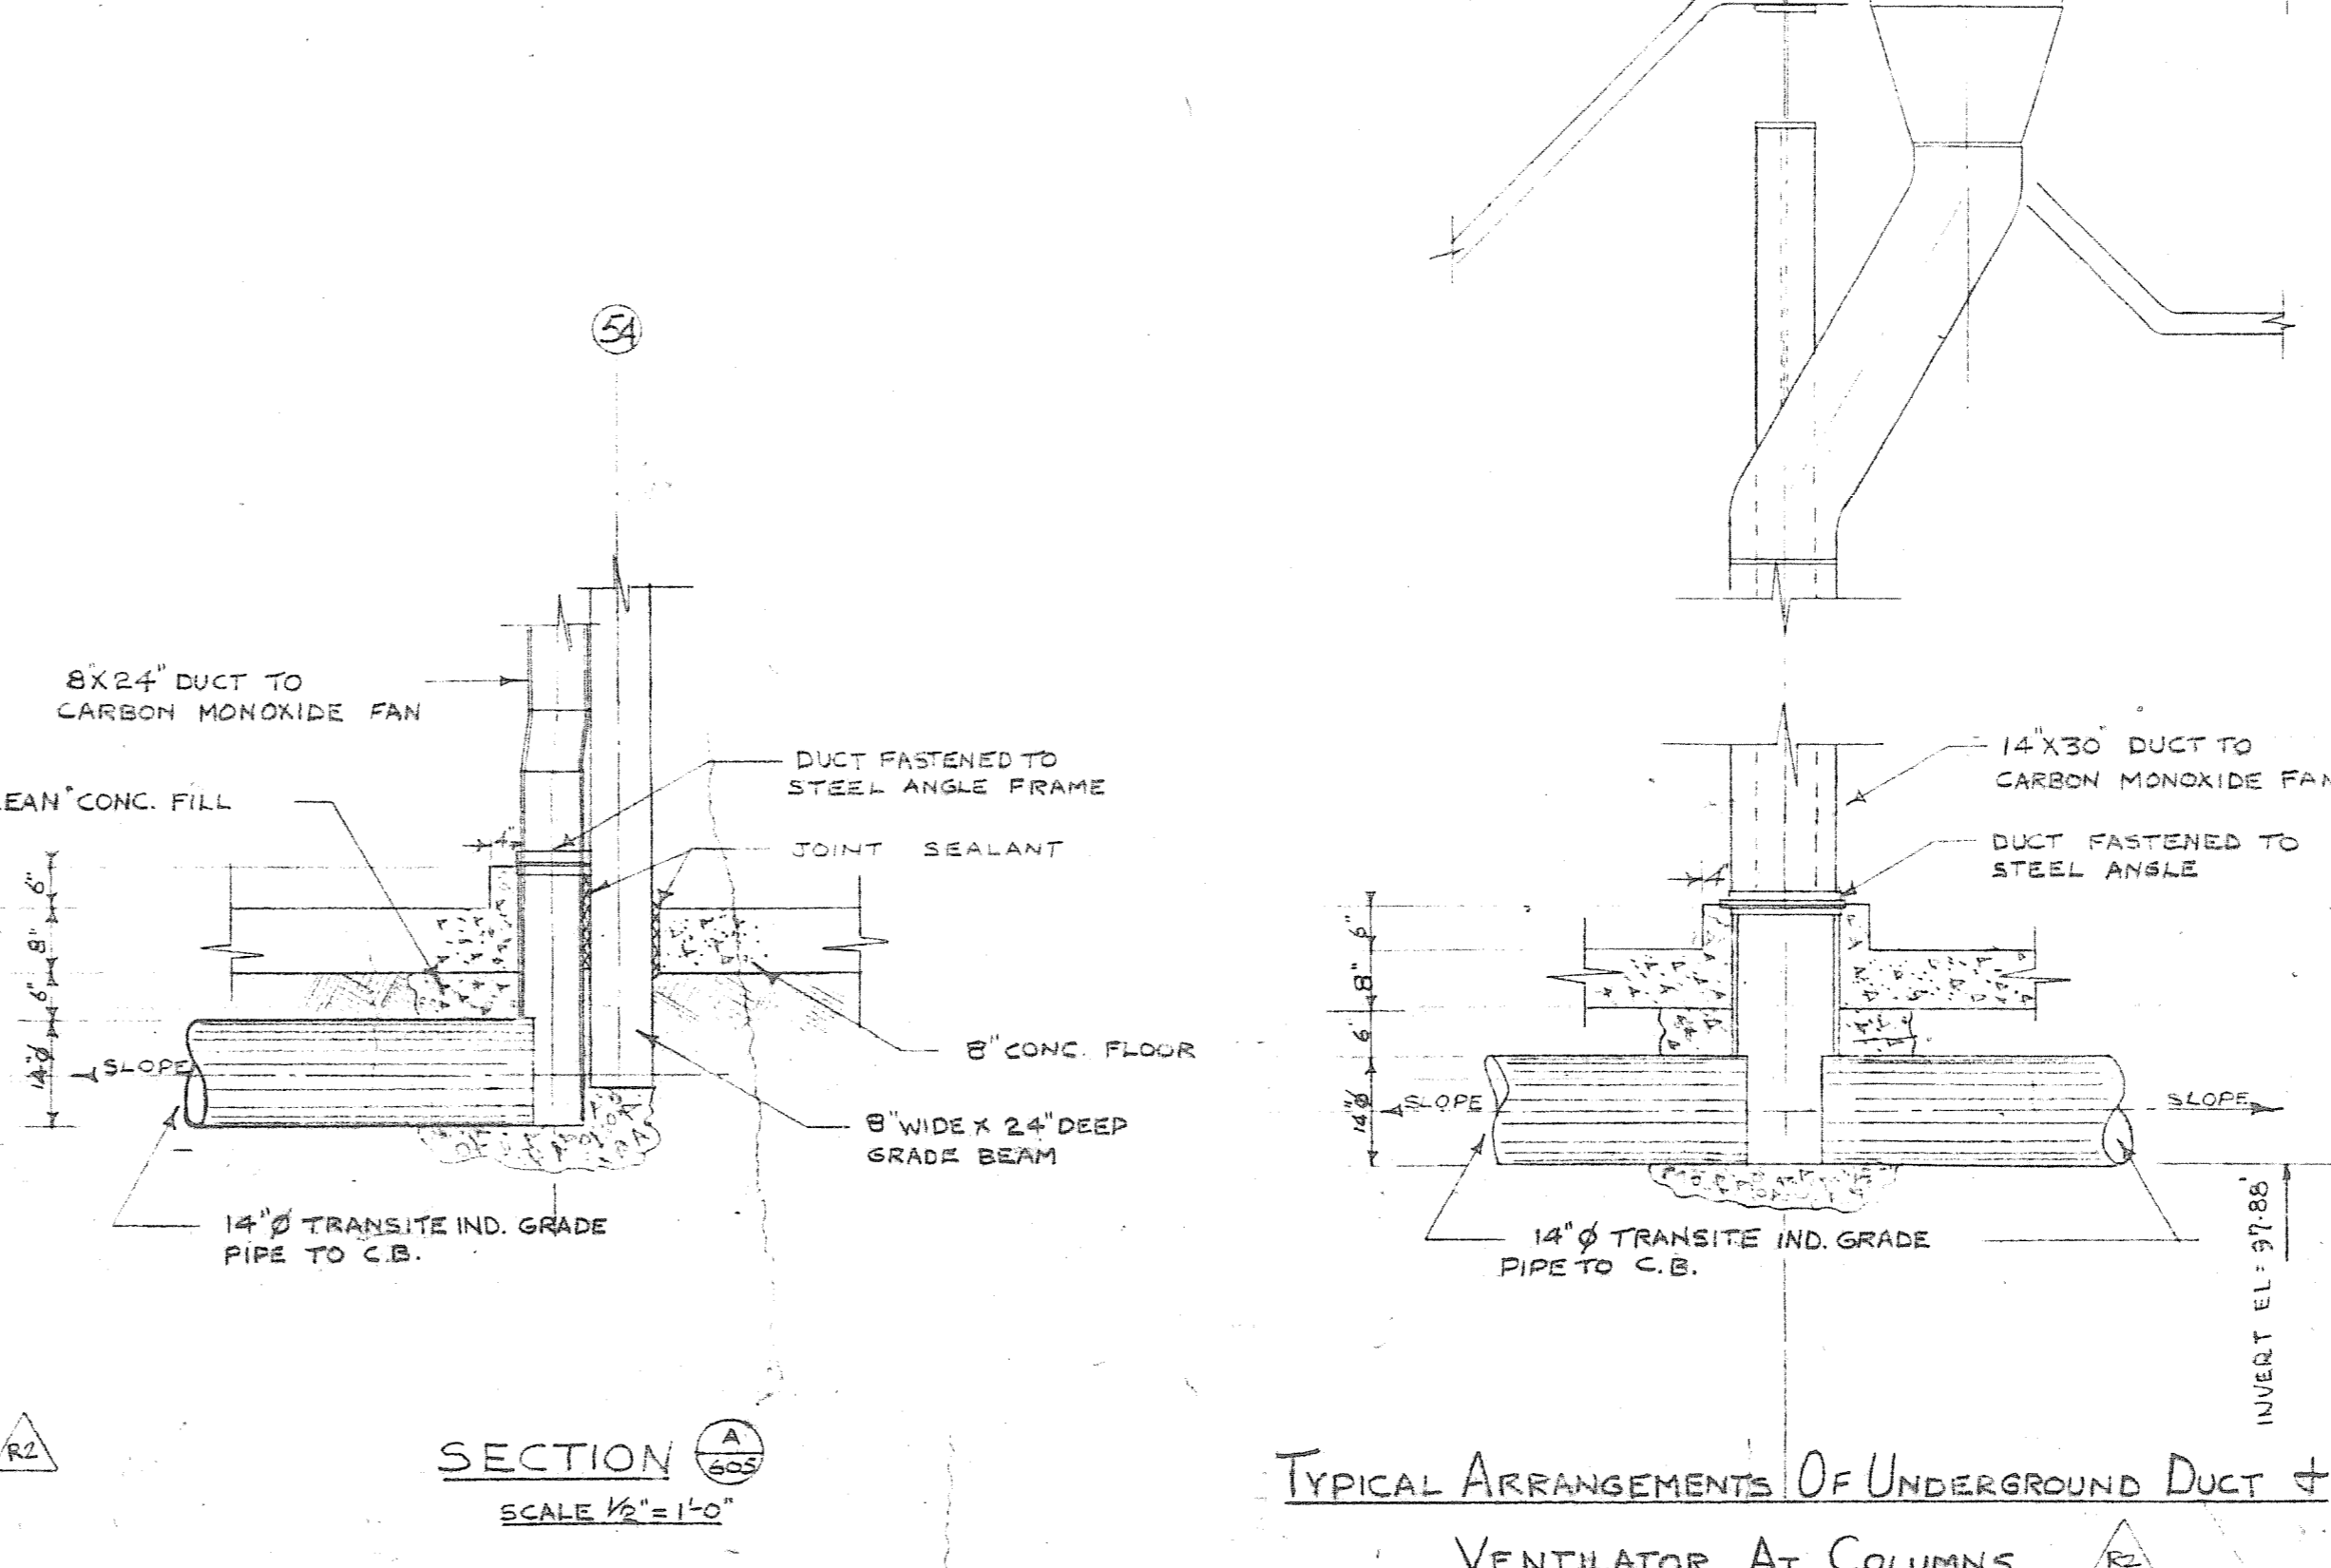

TYPICAL ARRANGEMENTS OF UNDERGROUND DUCT &
VENTILATOR AT COLUMNS
GARAGE BUILDING
SCALE 1/2\"/>

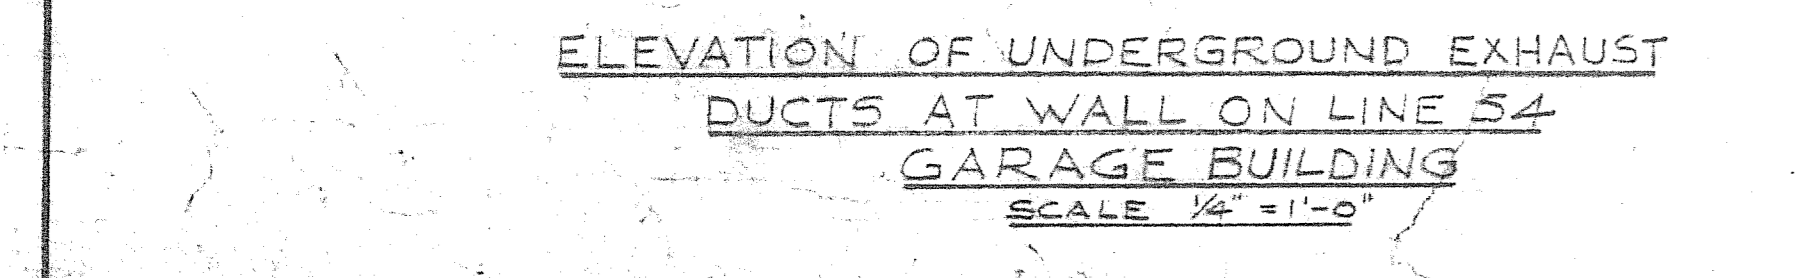

ELEVATION OF UNDERGROUND EXHAUST
DUCTS AT WALL ON LINE S4
GARAGE BUILDING
SCALE 1/2\"/>

- NOTE:-
1. NO WELDING OR DRILLING TO BUILDING STRUCTURE WILL BE PERMITTED
 2. FOR TYPICAL CONTROL DIAGRAMS SEE DWG. 2185-614 & 615
 3. ALL SECONDARY STEELWORK BY MECHANICAL CONTRACTOR

2185-605

APPROVED

A. D. MARGISON ASSOCIATES LTD.
CONSULTING PROFESSIONAL ENGINEERS
SUITE 300-1500 YONGE STREET
TORONTO, ONTARIO M4T 1Z2

NUMBER TEN ARCHITECTURAL GROUP
APPROVED

DATE	ISSUE NO.	REV.	DESCRIPTION	DRAWN BY
1.11.79	6	2	AS BUILT - SEE H.V. EQUIP. SHOP DRAWINGS	V.J.M.
9.5.77	5	1	GARAGE ADDITION - FOR TENDER	R.M.C.
2.8.76	4	1	AS BUILT	
2/13/76	3	0	FOR CONSTRUCTION	
19/7/75	2	0	FOR TENDER	
20/6/74	1	0	FOR APPROVAL	

ISSUE OR REVISION

METROPOLITAN CORPORATION OF GREATER WINNIPEG
STREETS AND TRANSIT DIVISION

TRANSIT STORAGE AND SHOP FACILITIES

HEATING & VENTILATING - DETAILS

CONSULTING PROFESSIONAL ENGINEERS
A. D. MARGISON AND ASSOCIATES LIMITED
1155 LESLIE STREET, DON MILLS, ONTARIO

APPROVED

DATE AUGUST '87

SCALE AS SHOWN

2185-605
MECHANICAL