



DILLON CONSULTING LIMITED 485 RICHMOND STREET, LONDON, ONTARIO, CANADA N6A 5A9. PHONE (519) 438-6192, FAX (519) 672-8209

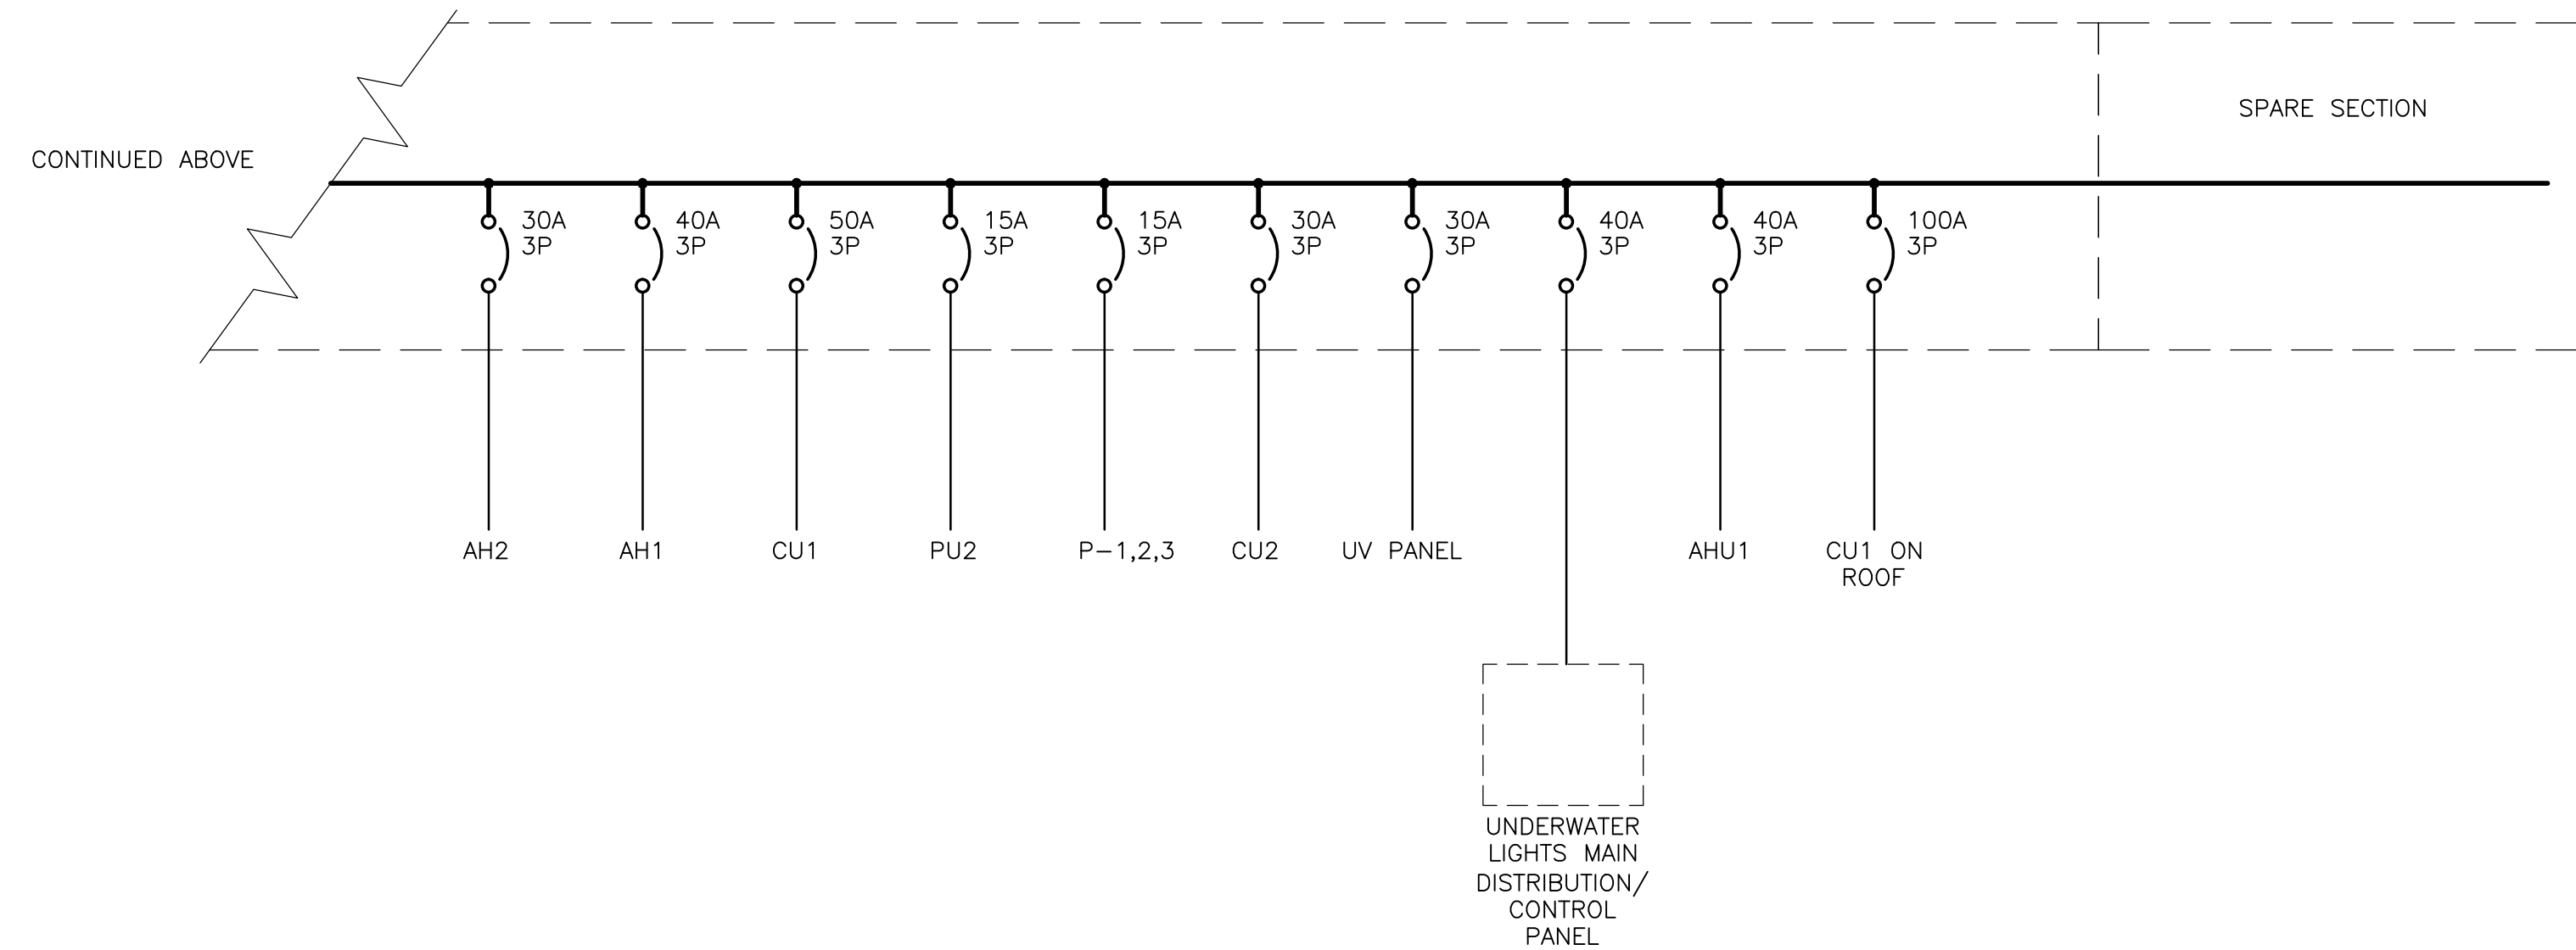

**Conditions of Use**

Verify elevations and/or dimensions on drawing prior to use. Report any discrepancies to Dillon Consulting Limited.  
Do not scale dimensions from drawing.  
Do not modify drawing, re-use it, or use it for purposes other than those intended at the time of its preparation without prior written permission from Dillon Consulting Limited.

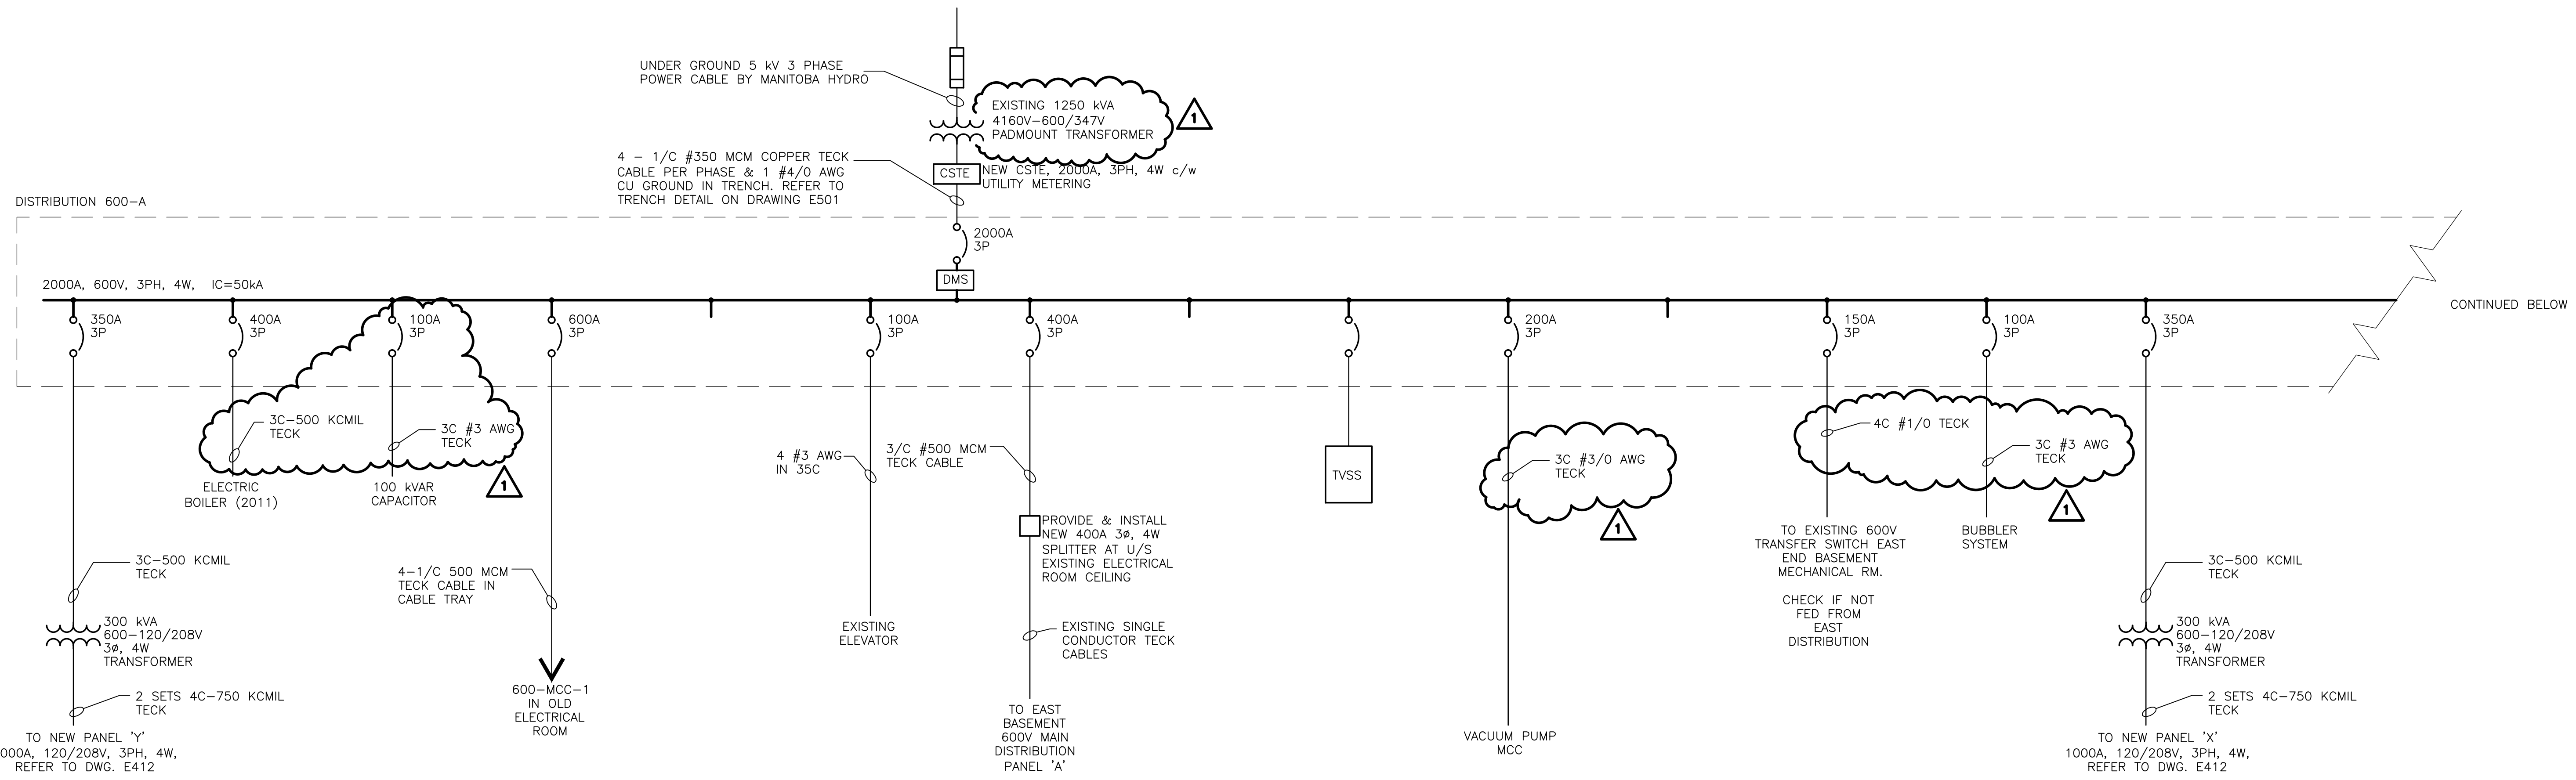

No.	ISSUED FOR	DATE	BY
1	ISSUED FOR ADDENDUM No.1	13-12-10	SCK
0	ISSUED FOR BID OPPORTUNITY NUMBER 850-2013	13-11-20	SCK

DESIGN	REVIEWED BY
DRAWN	CHECKED BY
DATE	FEB. 12, 2013
SCALE	N.T.S.

PAN AM POOL ELECTRICAL UPGRADE

PROJECT NO. 137300

ELECTRICAL SINGLE LINE DIAGRAM 1 OF 2

SHEET NO.

**E411**

F:\Home\g\cad\137300\constr\form\electrical\sl1.dwg