

1 SITE PLAN  
SCALE: 1"=60'

**DRAWING LIST:**

**ARCHITECTURAL :**

- A0.1 SITE PLAN
- A2.1 FLOOR PLAN, ELEVATIONS & SECTIONS

**STRUCTURAL :**



- S1 GENERAL NOTES
- S2 MAIN FLR & FOUNDATION PARTIAL PLANS
- S3 SECTIONS & DETAILS-1
- S4 SECTIONS & DETAILS-2
- S5 SECTIONS & DETAILS-3

**MECHANICAL :**

- M101 LEGEND, GENERAL NOTES & SCHEDULES
- M201 DEMOLITION PLANS
- M202 VENTILATION PLANS
- M203 PLUMBING PLANS
- M204 FIRE PROTECTION PLANS

**ELECTRICAL :**

- E201 BASEMENT LEVEL-WEST
- E202 BASEMENT LEVEL-BOILER ROOM
- E203 BASEMENT LEVEL-EAST
- E204 MAIN LEVEL-WEST & ELECT ROOM
- E205 MAIN LEVEL EAST
- E206 UPPER LEVEL-WEST & SECTION
- E207 LEGEND, SCHEDULE & DETAILS
- E401 DEMOLITION SINGLE LINE DIAGRAM 1 OF 2
- E402 DEMOLITION SINGLE LINE DIAGRAM 2 OF 2
- E411 SINGLE LINE DIAGRAM 1 OF 2
- E412 SINGLE LINE DIAGRAM 2 OF 2
- E413 120 VOLT MOTOR STARTERS
- E414 MOTOR CONTROL CENTER-1
- E421 PANEL SCHEDULES 1 OF 4
- E422 PANEL SCHEDULES 2 OF 4
- E423 PANEL SCHEDULES 3 OF 4
- E424 PANEL SCHEDULES 4 OF 4
- E601 LIGHTING-LIGHTING CONTROL DIAGRAM
- E602 LIGHTING-LIGHTING CONTROL PANEL 1 OF 2
- E603 LIGHTING-LIGHTING CONTROL PANEL 2 OF 2
- ED01 DEMOLITION BASEMENT-PARTIAL FLR PLAN
- ED02 DEMOLITION BASEMENT LEVEL-WEST
- ED03 DEMOLITION BASEMENT LEVEL -EAST
- ED04 DEMOLITION MAIN LEVEL-WEST
- ED05 DEMOLITION MAIN LEVEL-EAST
- ED06 DEMOLITION UPPER LEVEL-WEST

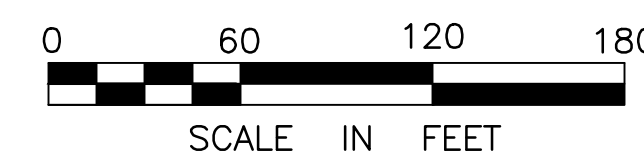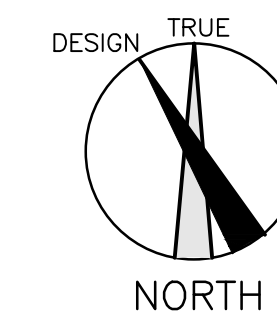

REV	DESCRIPTION	DATE	BY
1	ISSUED FOR BID OPP #850-2013	20 NOV 2013	AL
0	ISSUED FOR 90% REVIEW	21 JUN 2013	AL



THIS DRAWING MUST NOT BE SCALED.  
THE GENERAL CONTRACTOR SHALL VERIFY ALL DIMENSIONS, DATUMS AND LEVELS PRIOR TO COMMENCEMENT OF WORK AND IS HELD RESPONSIBLE FOR REPORTING ANY DISCREPANCY OR OMISSION TO NEIL COOPER ARCHITECT INC IMMEDIATELY.  
THIS DRAWING IS THE EXCLUSIVE PROPERTY OF NEIL COOPER ARCHITECT INC AND CAN BE REPRODUCED ONLY WITH THE PERMISSION OF NEIL COOPER ARCHITECT INC, IN WHICH CASE THE REPRODUCTION MUST BEAR THEIR NAME AS THE ARCHITECTURAL FIRM.

DRAWING:  
**SITE PLAN**

PROJECT:  
**PAN AM POOL ELECTRICAL UPGRADE**  
25 POSEIDON BAY, WINNIPEG MB.

**Neil Cooper Architect Inc.**  
10-395 Berry Street, Winnipeg, Manitoba R3J 1N6

DRAWN BY: AL	CHECKED BY: INC	SHEET NO: <b>A0.1R1</b>	REV NO:
DATE: 21 FEB 2013	SCALE: AS SHOWN	FILE: 12137/Cont Doc/Cont Dwgs/Arch/A0.1 R0.dwg	