



DILLON CONSULTING LIMITED 485 RICHMOND STREET, LONDON, ONTARIO, CANADA N6A 5A9. PHONE (519) 438-6192, FAX (519) 672-8209

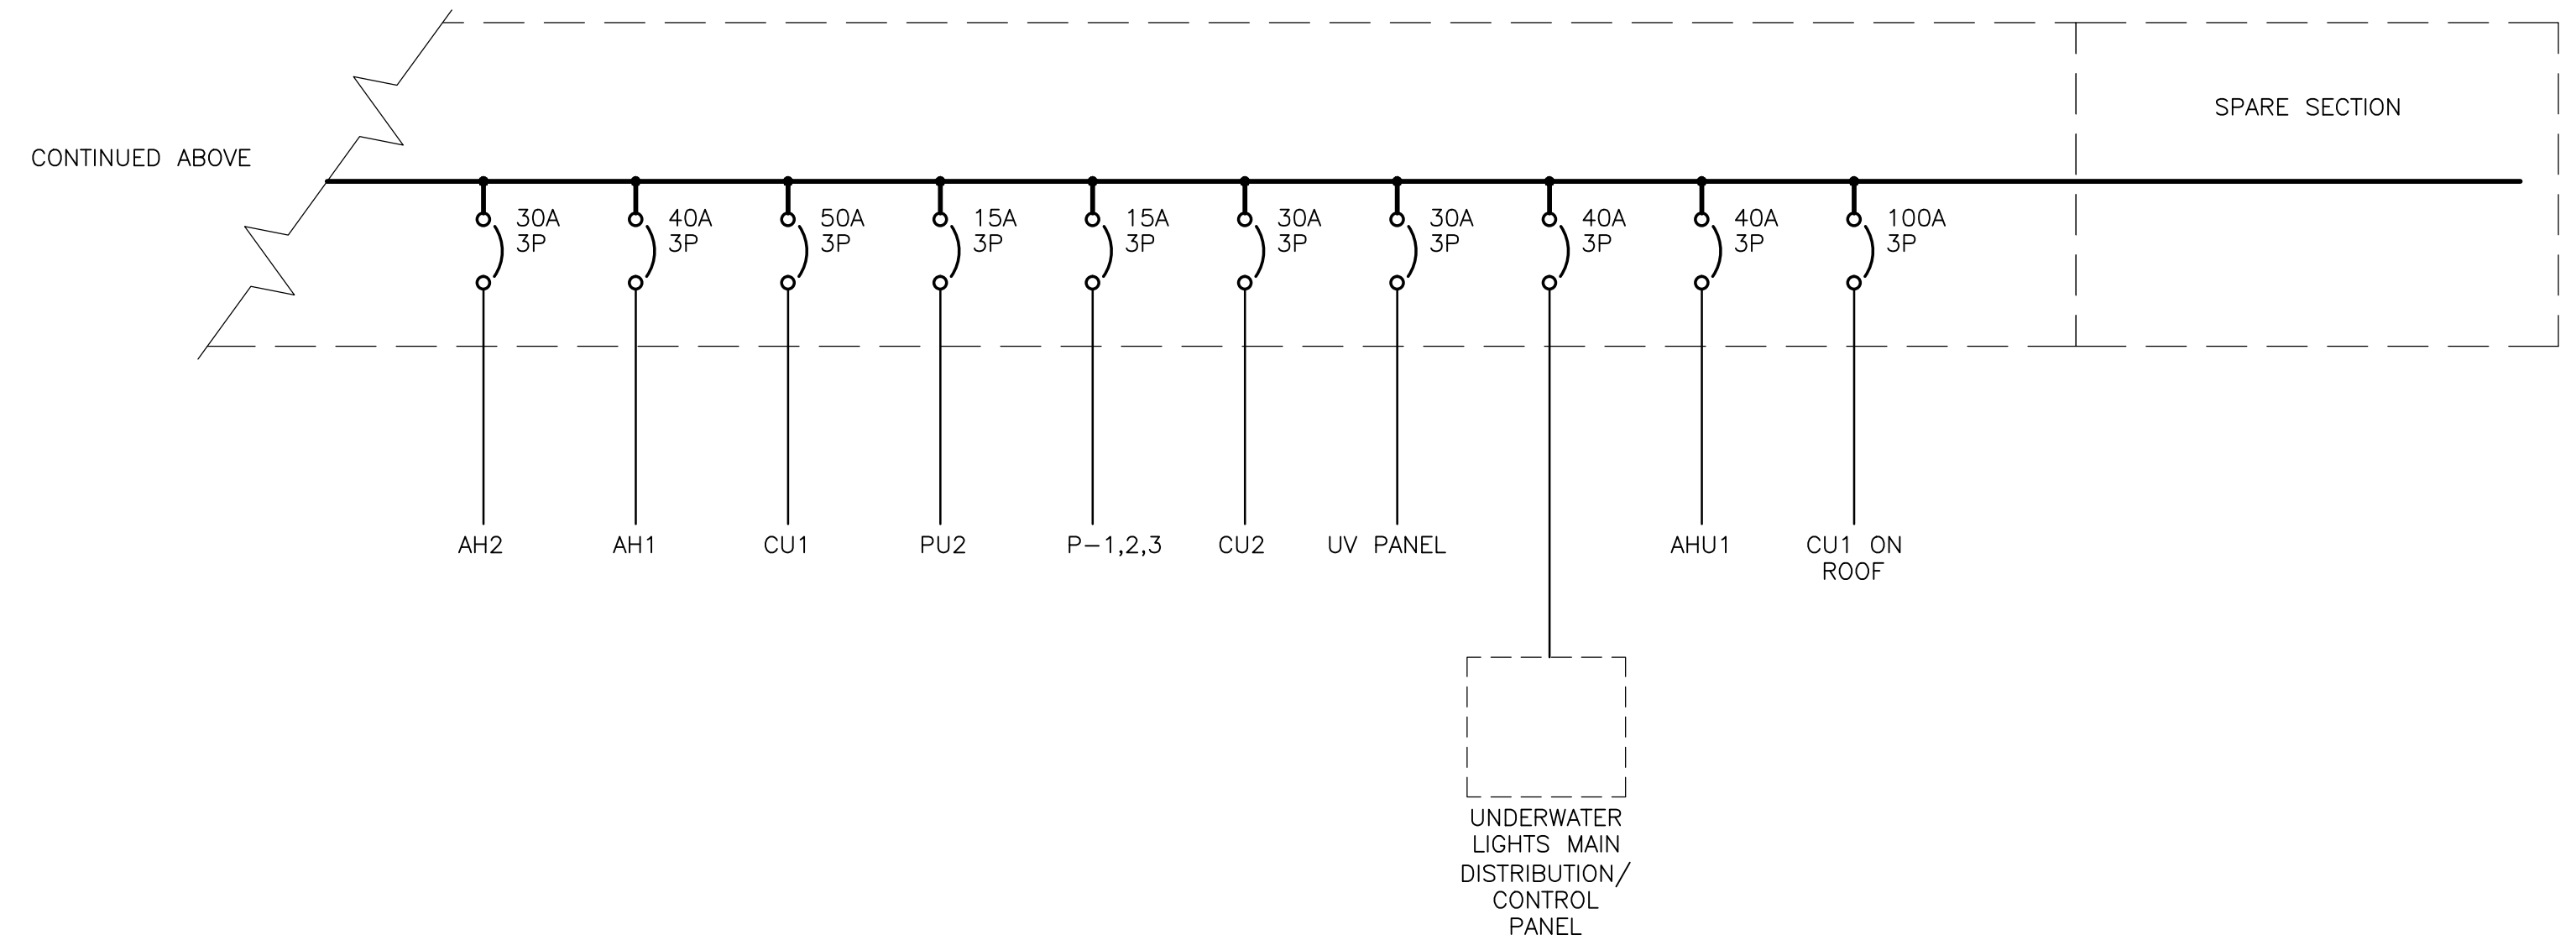

**Conditions of Use**  
 Verify elevations and/or dimensions on drawing prior to use. Report any discrepancies to Dillon Consulting Limited.  
 Do not scale dimensions from drawing.  
 Do not modify drawing, re-use it, or use it for purposes other than those intended at the time of its preparation without prior written permission from Dillon Consulting Limited.

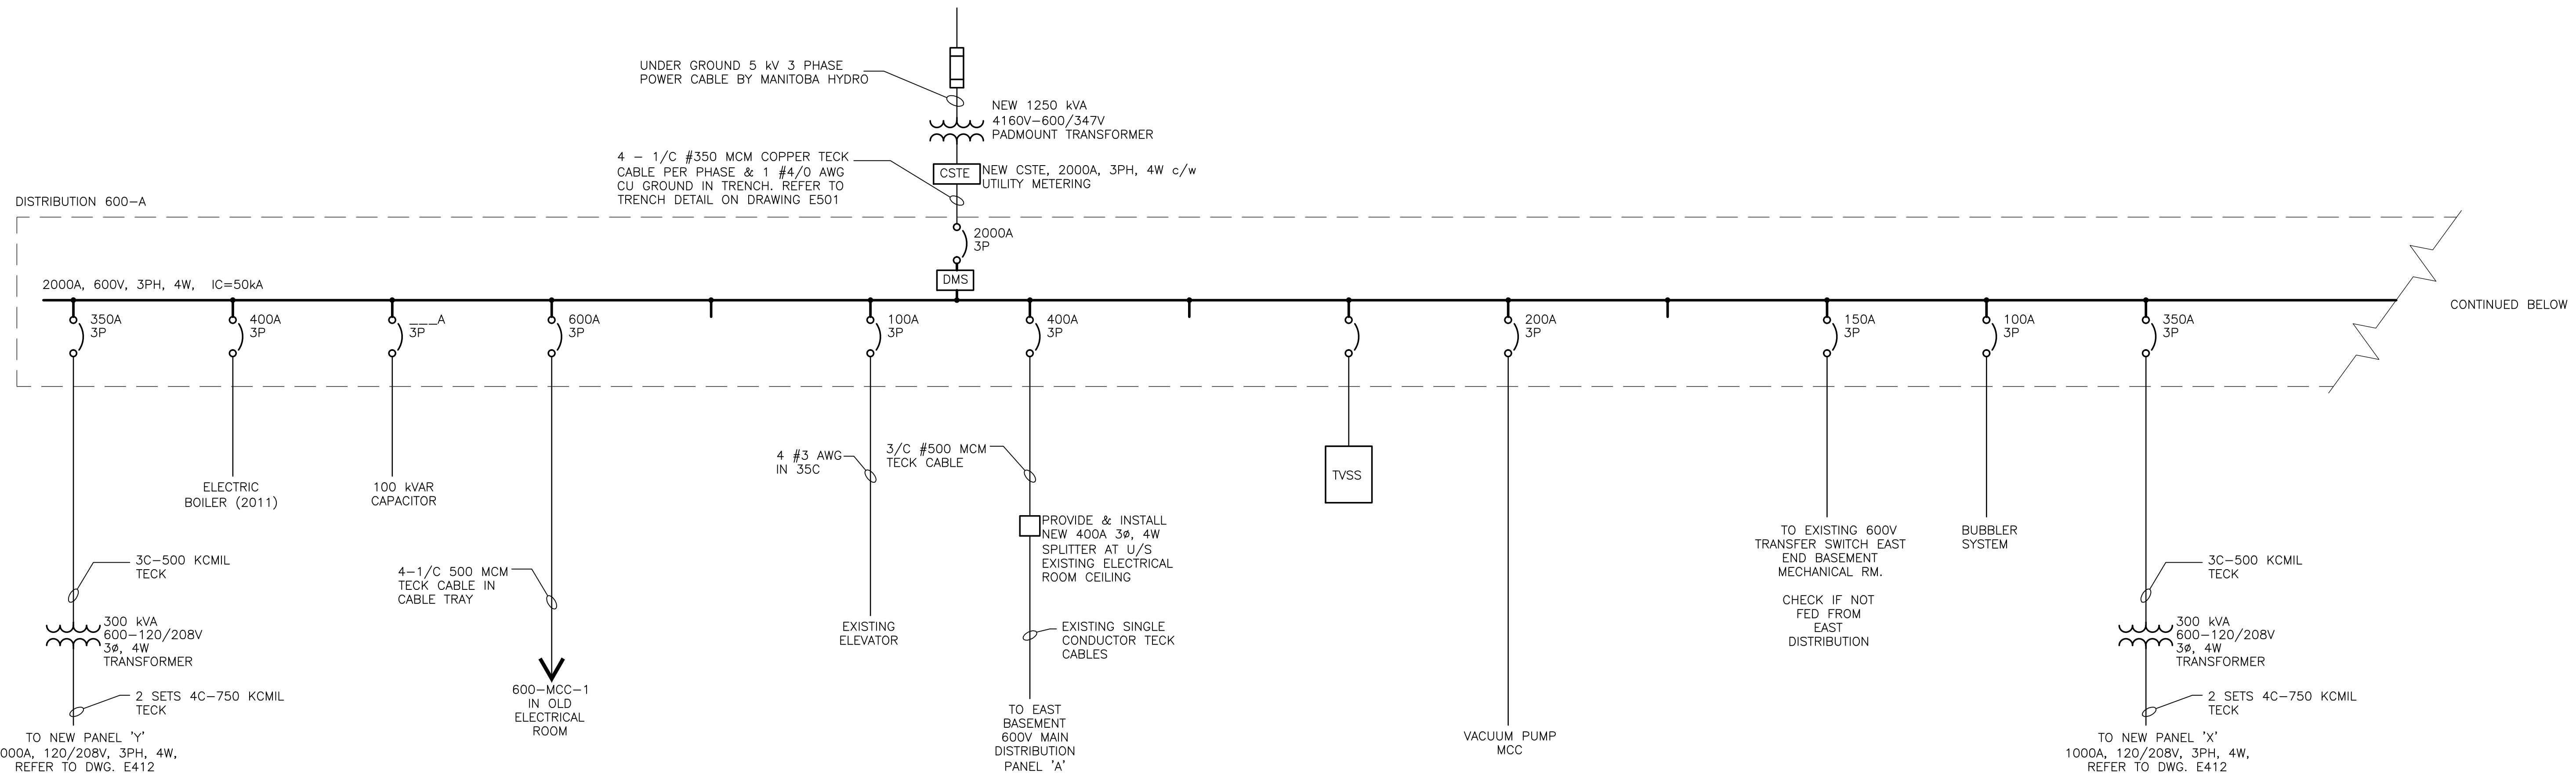

DESIGN	REVIEWED BY
DRAWN	CHECKED BY
DATE	FEB. 12, 2013
SCALE	N.T.S.
ISSUED FOR BID OPPORTUNITY NUMBER 850-2013	13-11-20 SCK
No.	ISSUED FOR
DATE	BY

**PAN AM POOL ELECTRICAL UPGRADE**

**ELECTRICAL SINGLE LINE DIAGRAM 1 OF 2**

PROJECT NO. 137300

SHEET NO. **E411**

F:\Name\g\cad\137300\contract\form\electrical\sl1.dwg