



1 PLAN
1:150



SEE WX-M0111 FOR CONTINUATION

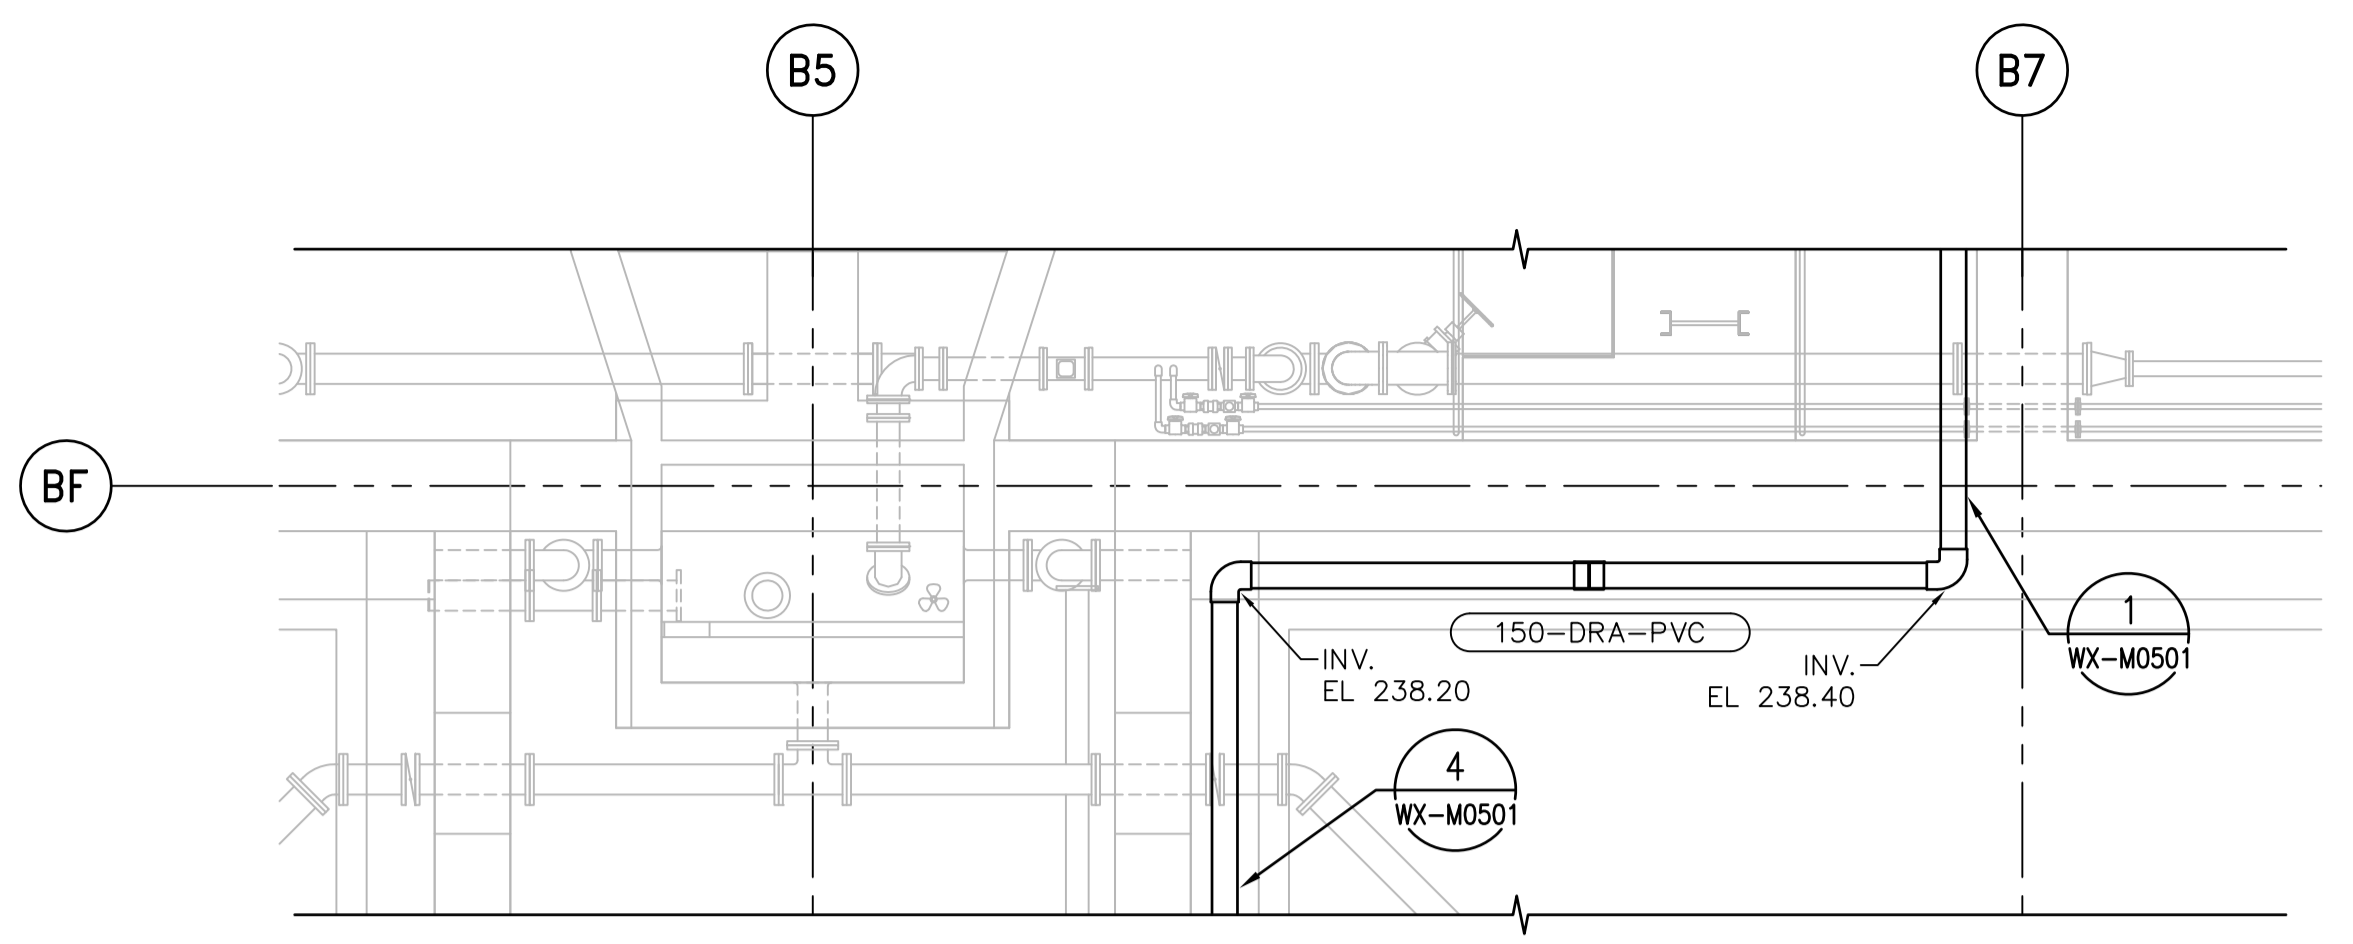

2 PARTIAL PLAN
1:50

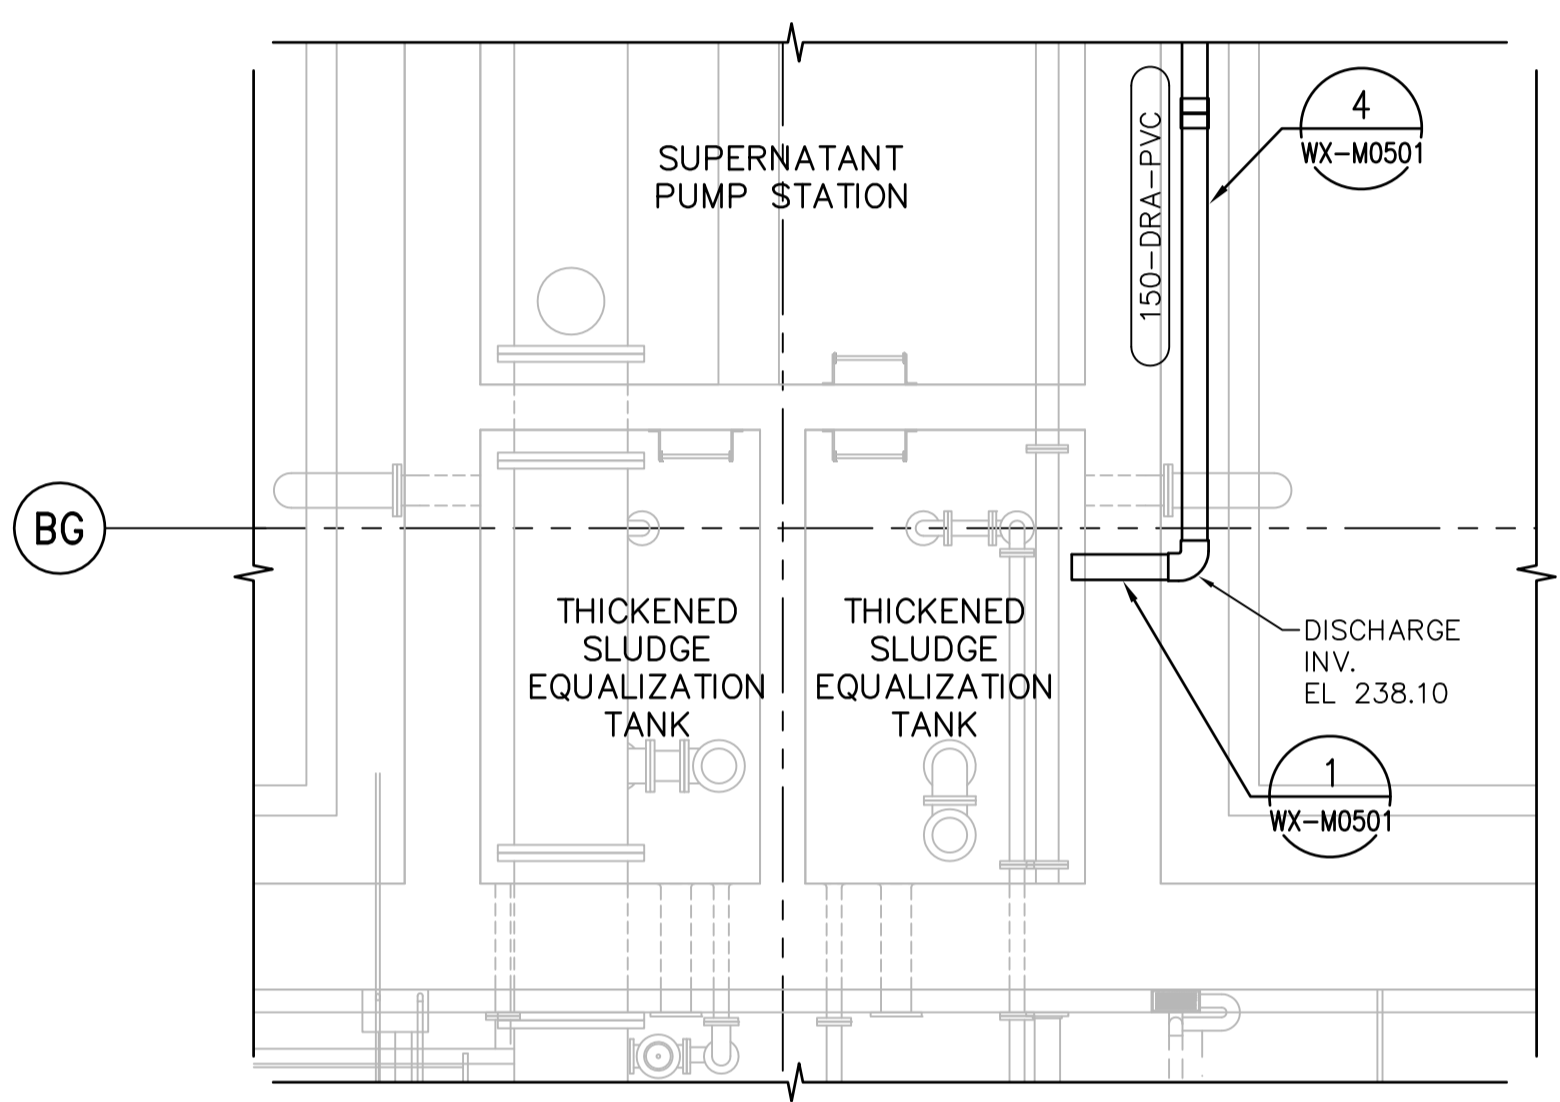

3 PARTIAL PLAN
1:50

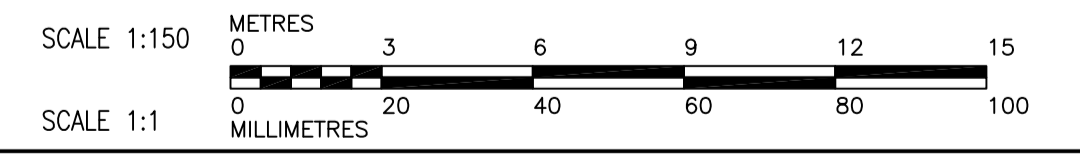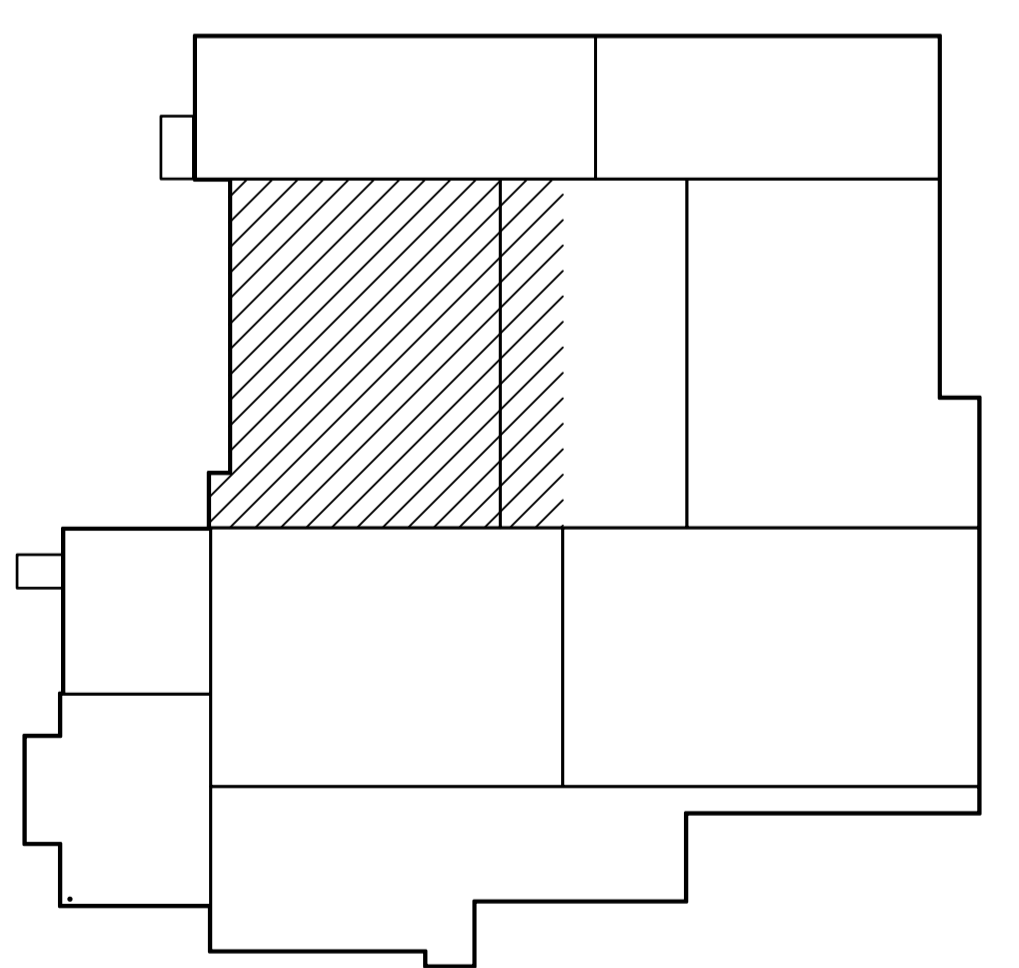

REFERENCE DRAWINGS:


- 1-0601R-H0003-001-03 PLUMBING FIRST FLOOR PLAN
- 1-0601R-M0002-001-02 PROCESS MECHANICAL FIRST FLOOR PLAN



B.M. ELEV.			
CONSTRUCTION COMPLETION DATE: YYYY MM DD			
DESIGNED BY	KG	CHECKED BY	BW
DRAWN BY	JBC	APPROVED BY	BW
SCALE:	1:150		
HORIZONTAL	1:150		
VERTICAL	-		
DATE	2014 06 13	RELEASED FOR CONSTRUCTION	DATE
NO.	REVISIONS	DATE	BY

CH2MHILL

DESIGNED BY: KG, CHECKED BY: BW
 DRAWN BY: JBC, APPROVED BY: BW
 SCALE: HORIZONTAL 1:150, VERTICAL -
 DATE: 2014 06 13

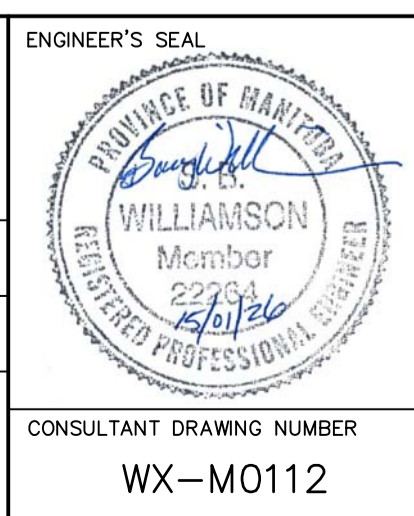

THE CITY OF WINNIPEG
 WATER AND WASTE DEPARTMENT
 ENGINEERING DIVISION

Winnipeg

CITY OF WINNIPEG WATER TREATMENT RESEARCH AND PROCESS OPTIMIZATION FACILITY
 PROCESS MECHANICAL
 RAW WATER SUPPLY TO PILOT PLANT/
 RESIDUALS DRAIN TO TSET

ENGINEER'S SEAL
 WILLIAMSON
 Member
 22284
 REGISTERED PROFESSIONAL ENGINEER

CONSULTANT DRAWING NUMBER
WX-M0112

SHEET X OF X
 CITY DRAWING NUMBER
 1-0601X-M0002-001-01