
 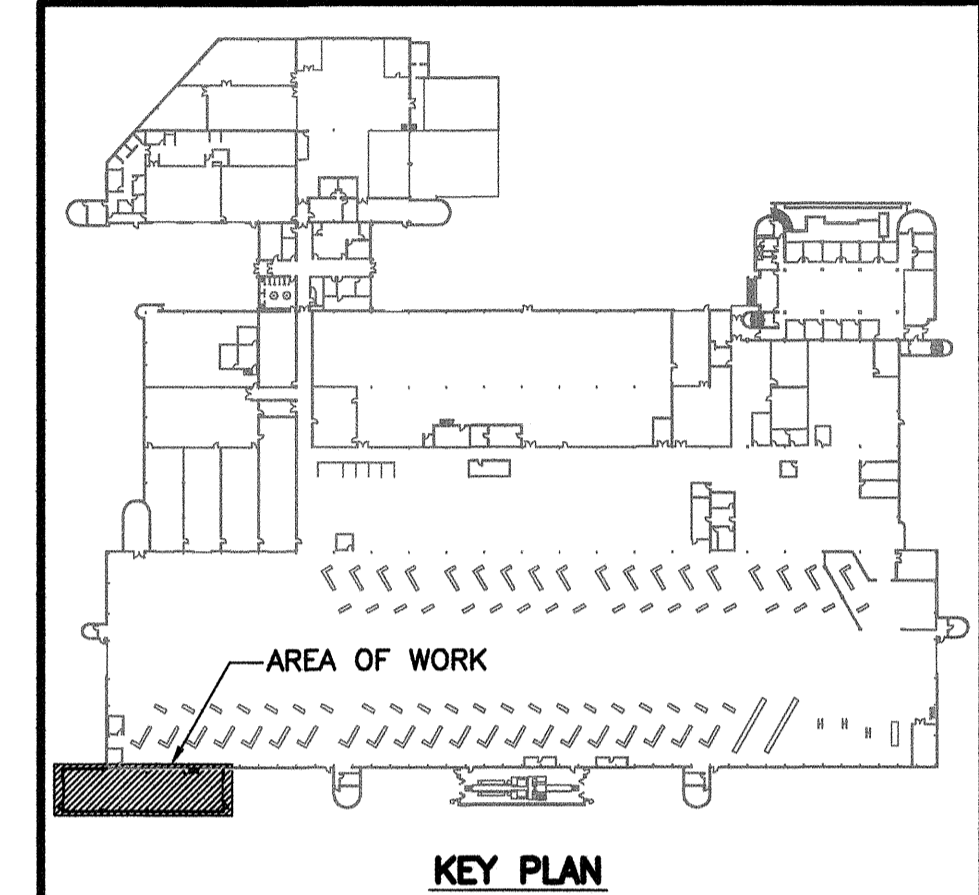


REFERENCE DRAWINGS	
NO.	DESCRIPTION

NOTES:

1. LOCATIONS OF MAU-1 AND F-1 ARE APPROXIMATE. COORDINATE EXACT LOCATION ON SITE WITH ALL SUBTRADES.
2. REFER TO DWG. 1329720500-DWG-M0007 FOR MECHANICAL SCHEDULES.
3. REFER TO DWG. 1329720500-DWG-S0003 FOR MAIN FLOOR STRUCTURAL DETAILS.
4. REFER TO DWG. 1329720500-DWG-B0002 FOR MAIN FLOOR BUILDING DETAILS.
5. REFER TO DRAWING 1329720500-DWG-M0004 FOR LEGEND.



NO.	DATE	DESCRIPTION	PREPARED	REVIEW	DESIGN	AUTHORIZED
00	14.01.17	ISSUED FOR CONSTRUCTION	DD	JS	TS	TS

REGISTERED PROFESSIONAL ENGINEER

DESIGNED BY:	PREPARED BY:	REVIEWED BY:
TS	EV	JS
AUTHORIZED BY:	DATE:	SCALE:
	13.11.20	AS NOTED

THE CONTENT OF THIS DOCUMENT IS NOT INTENDED FOR THE USE OF, NOR IS IT INTENDED TO BE RELIED UPON BY ANY PERSON, FIRM OR CORPORATION OTHER THAN THE CLIENT AND TETRA TECH WEI INC. (Tetra Tech). TETRA TECH WEI INC. (Tetra Tech) DENIES ANY LIABILITY WHATSOEVER TO OTHER PARTIES FOR DAMAGES OR INJURY SUFFERED BY SUCH THIRD PARTY ARISING FROM THE USE OF THIS DOCUMENT BY THEM, WITHOUT THE EXPRESSED WRITTEN AUTHORITY OF TETRA TECH WEI INC. (Tetra Tech) AND OUR CLIENT. THIS DOCUMENT IS SUBJECT TO FURTHER RESTRICTIONS IMPOSED BY THE CONTRACT BETWEEN THE CLIENT AND TETRA TECH WEI INC. (Tetra Tech) AND THESE PARTIES' PERMISSION MUST BE SOUGHT REGARDING THIS DOCUMENT IN ALL OTHER CIRCUMSTANCES.

SUB-CONSULTANTS:



CLIENT: CITY OF WINNIPEG
TRANSIT DEPARTMENT

TETRA TECH

PROJECT NAME:
CITY OF WINNIPEG TRANSIT - FORT ROUGE GARAGE
BUS MAINTENANCE ADDITION

DRAWING DESCRIPTION:
ROOF PLAN - HVAC

DRAWING NO. 1329720500-DWG-M0005	REV: 00
-------------------------------------	------------

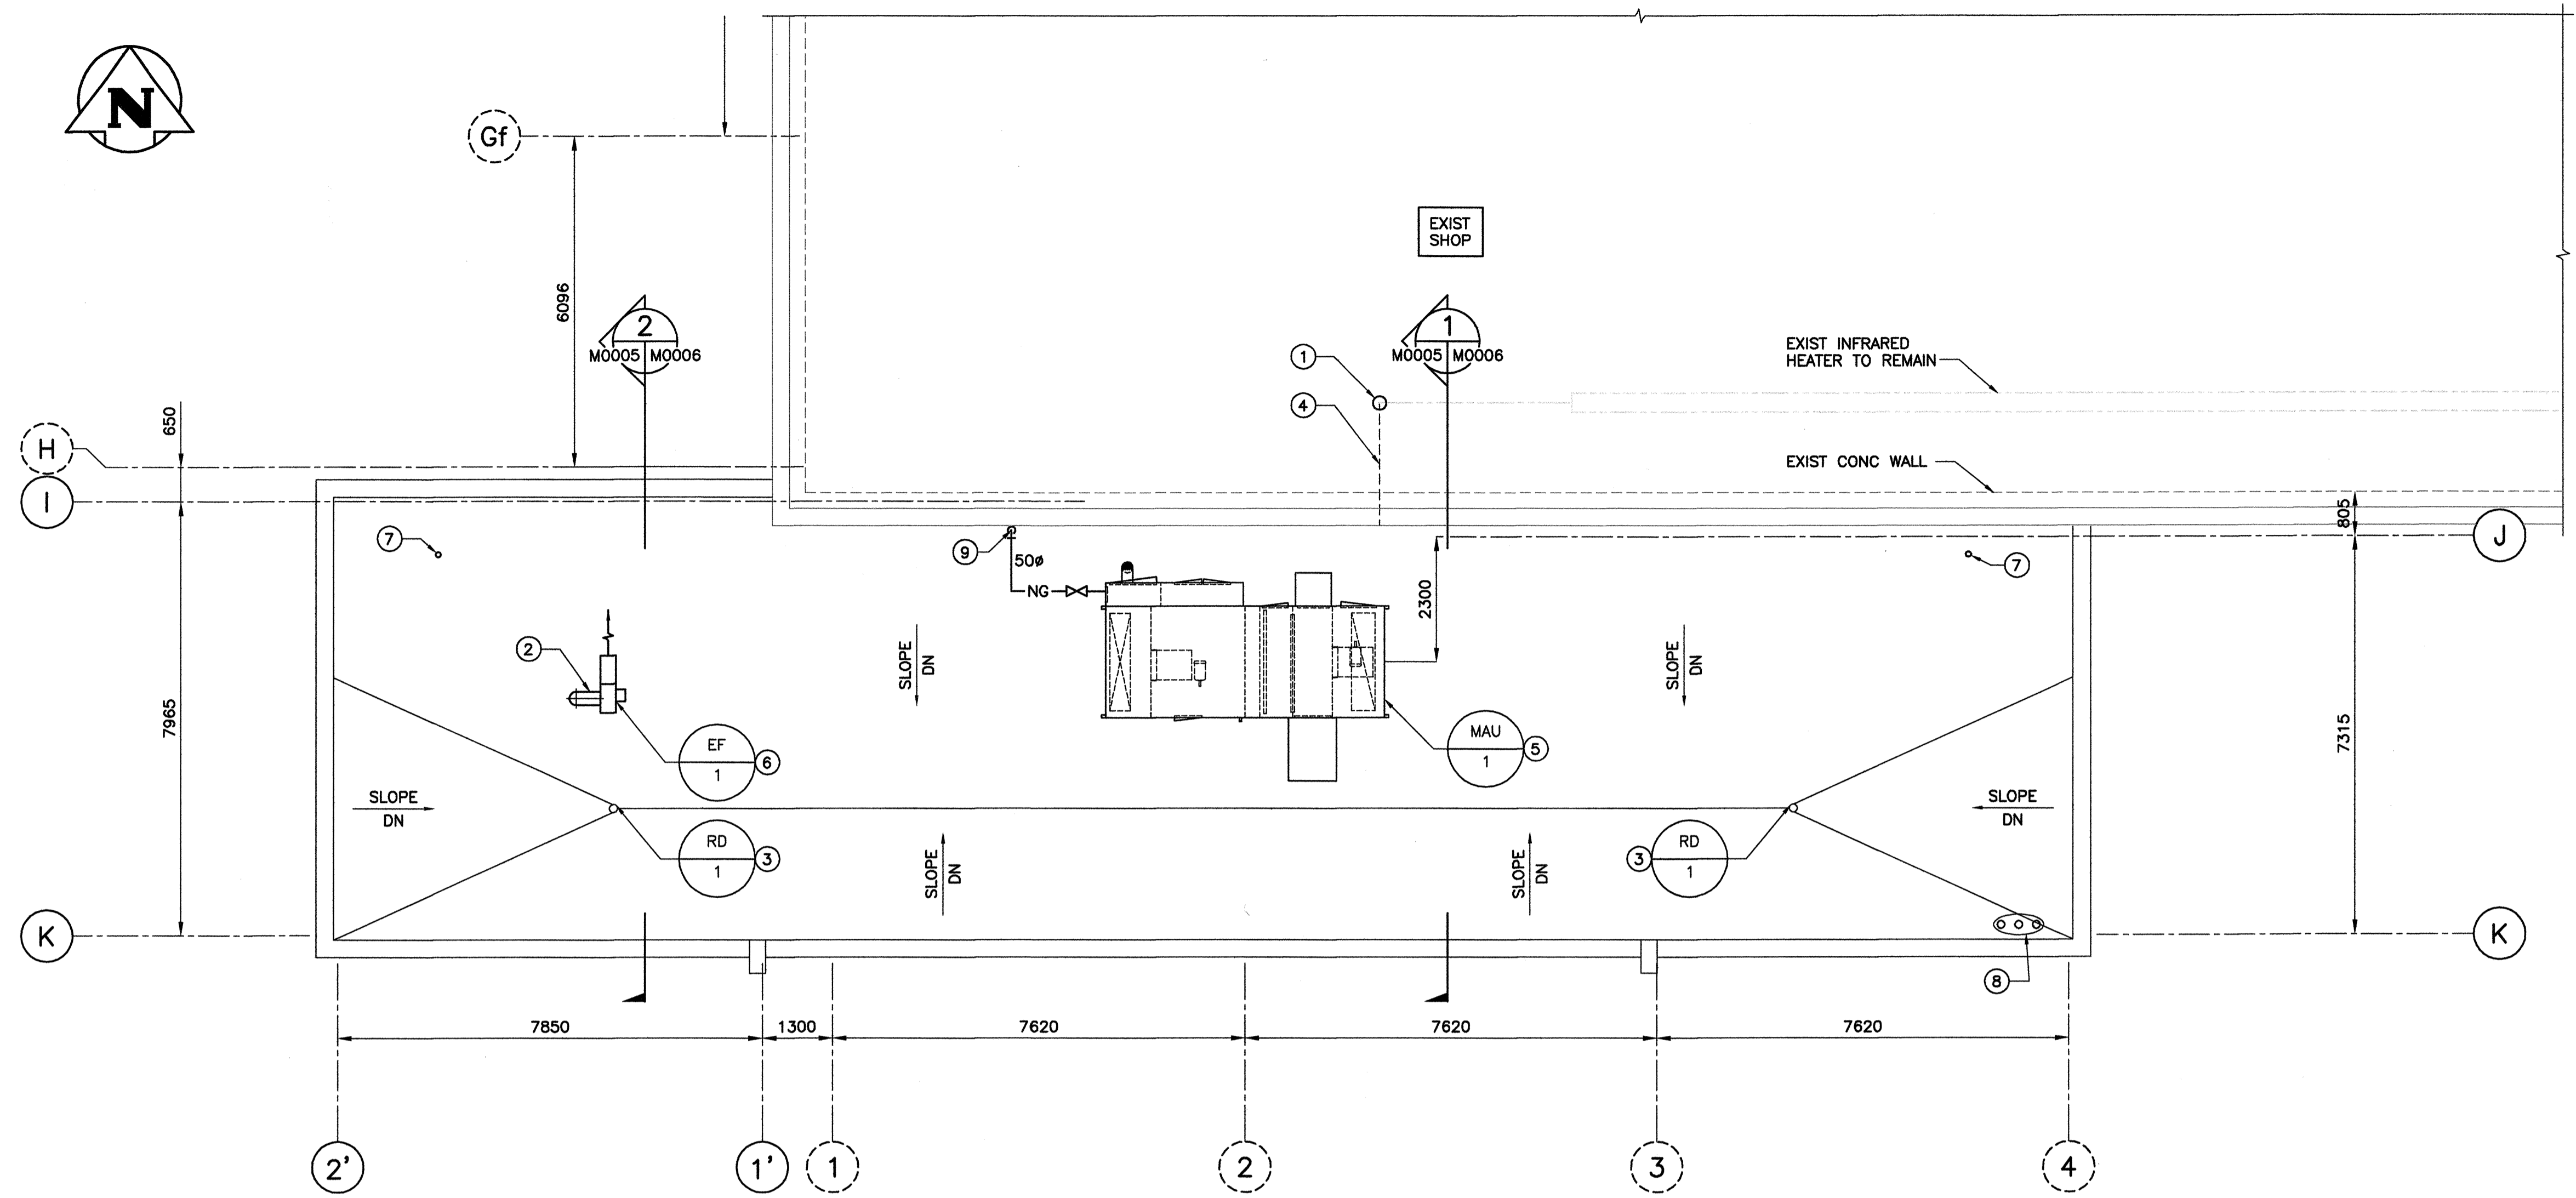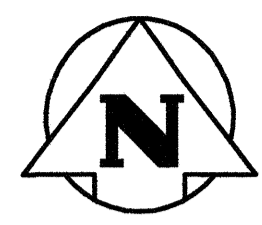

1 ROOF PLAN - MECHANICAL
1 : 75

DRAWING NOTES:

- 1 PROVIDE TYPE "B" VENT THROUGH EXISTING ROOF AS PER CSA GAS CODE AND MANUFACTURERS INSTRUCTION.
- 2 200Ø BUS TAIL PIPE EXHAUST AIR DUCTWORK THROUGH ROOF.
- 3 CONTROL FLOW ROOF DRAIN.
- 4 EXIST INFRARED HEATER VENT DUCTWORK TO BE REMOVED.
- 5 NEW GAS FIRED MAKEUP AIR UNIT MOUNTED ON CURB. COORDINATE WITH STRUCTURAL DRAWINGS FOR EXACT LOCATION.
- 6 ROOF MOUNTED EXHAUST FAN C/W WEATHER HOOD.
- 7 GAS FIRED UNIT HEATER VENT THROUGH ROOF.
- 8 SANITARY VENT THROUGH ROOF.
- 9 NATURAL GAS LINE UP FROM LINE BELOW. PROVIDE "C-PORT" SUPPORT AS REQUIRED.