


DEMOLITION REFLECTED CEILING PLAN

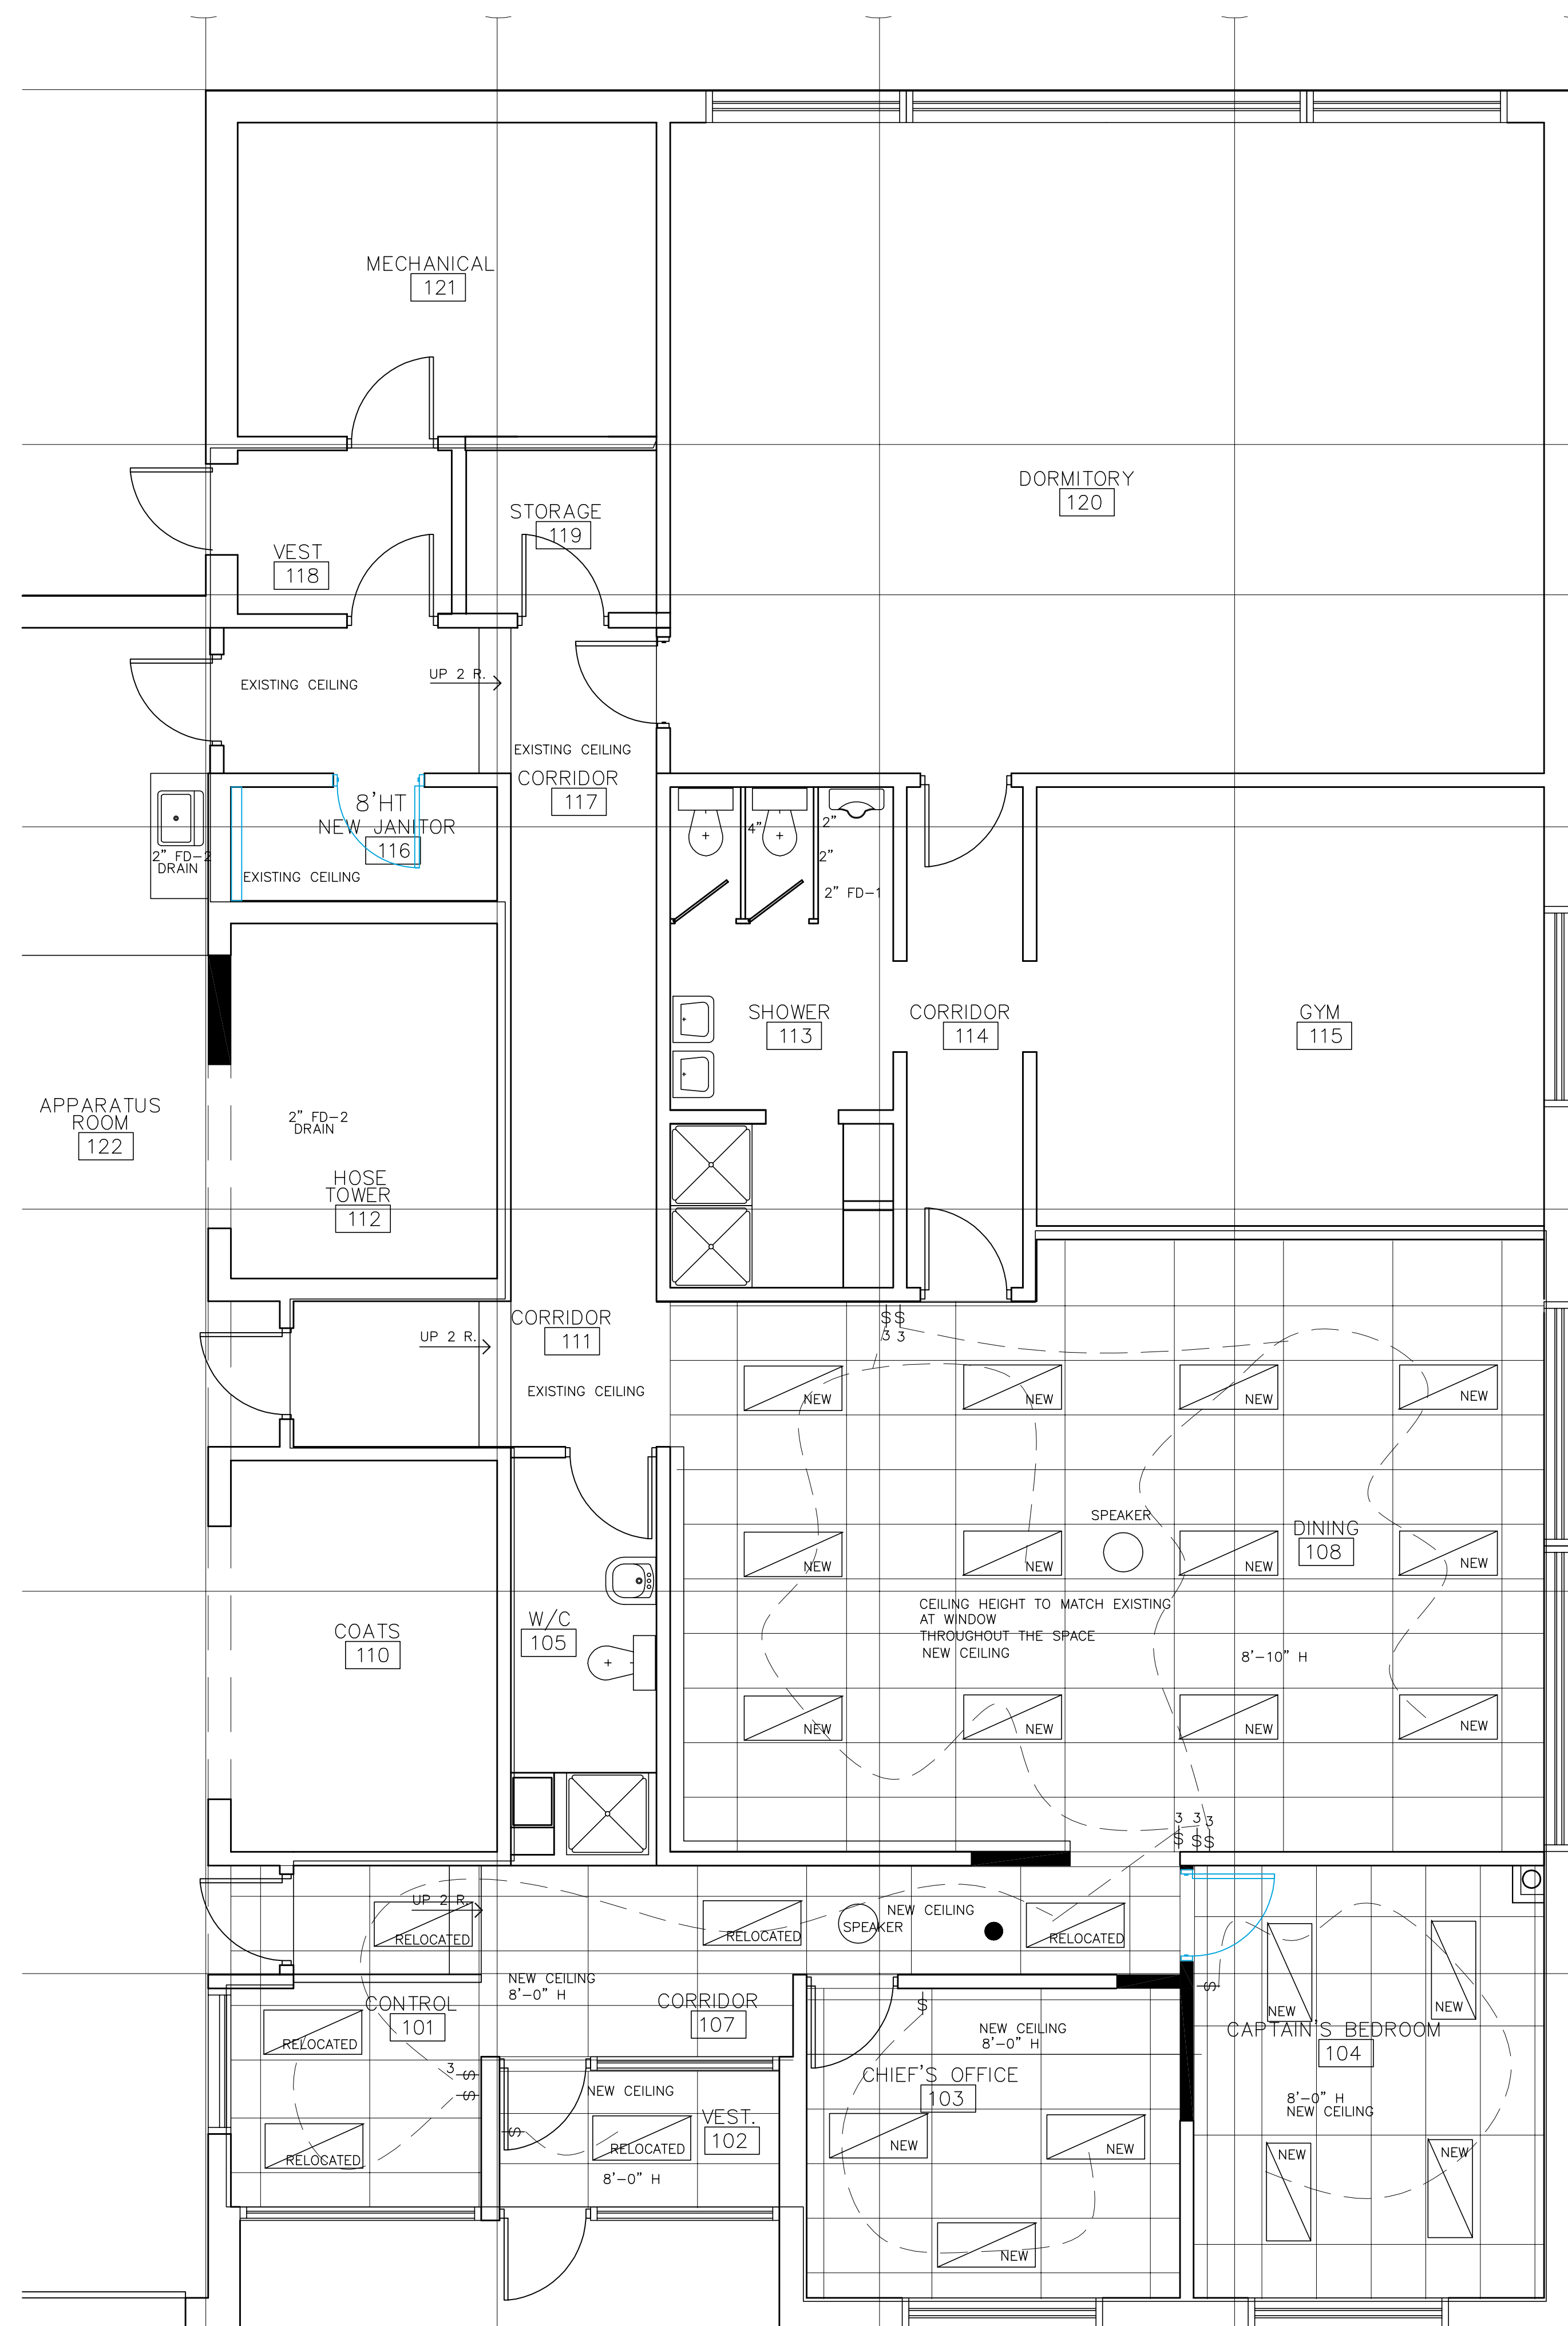

REFLECTED CEILING PLAN

LIGHTING LEGEND

- SPEAKER
- EXISTING LIGHT FIXTURE
NEW TO MATCH EXISTING
- AIR RETURN
- RELOCATE EXISTING
DIFFUSERS AS NOTED
- NEW AIR RETURN
AS PER CODE
- SWITCH - BLACK WITH STAINLESS STEEL
COVER PLATES
- T-BAR
ARMSTRONG
PRELUDE XL WHITE ALUMINUM
2' X 4'
- 1/2" EXPOSED TEE SYSTEM
ACOUSTIC CEILING TILES
ARMSTRONG
CIRRUS, ANGLED TEGULAR
2' X 4' X 3/4"
- 1/2" EXPOSED TEE SYSTEM
WHITE

REUSE 6 EXISTING 2 X 4
FLUORESCENT LIGHTS

NEW CEILING GRID & TILES AS
SHOWN, SEE SPECIFICATIONS

REINSTALL SPEAKERS AT EXISTING
LOCATION

NO.	DATE	DESCRIPTION	BY
1	DEC 2015	ADDENDUM	M.G.
0	JULY 2014	TENDER	M.G.

PRINTING DATE

DRAWINGS & SPECIFICATIONS, AS INSTRUMENTS OF SERVICE ARE THE PROPERTY OF THE CITY OF WINNIPEG, THE COPYRIGHT IN THE SAME BEING RESERVED TO THEM. NO REPRODUCTION MAY BE MADE WITHOUT THE PERMISSION OF THE CITY OF WINNIPEG. ALL PRINTS TO BE RETURNED. THE CONTRACTOR IS TO VERIFY DIMENSIONS & DATA NOTED HEREIN WITH CONDITIONS ON THE SITE & IS HELD RESPONSIBLE FOR REPORTING ANY DISCREPANCY FOR ADJUSTMENT.



SYNERGY INTERIOR DESIGN INC
13 Rosewarne, Avenue WINNIPEG, MB Canada R2M 0V8
204 233 9159
malvine@synergyinteriors.com

DATE MARCH 2013 SCALE 1/4" = 1'-0" REVISIONS
DRAWN BY M.G. CHECKED BY

STATION 10, 1354 BORDER ST. WINNIPEG,
CITY OF WINNIPEG

AUTOCAD NUMBER

DWG. A4-R1

1119-2014_Addendum_1-Drawing_A4-R1