


**NORTH ELEVATION**


SCALE: 1:40

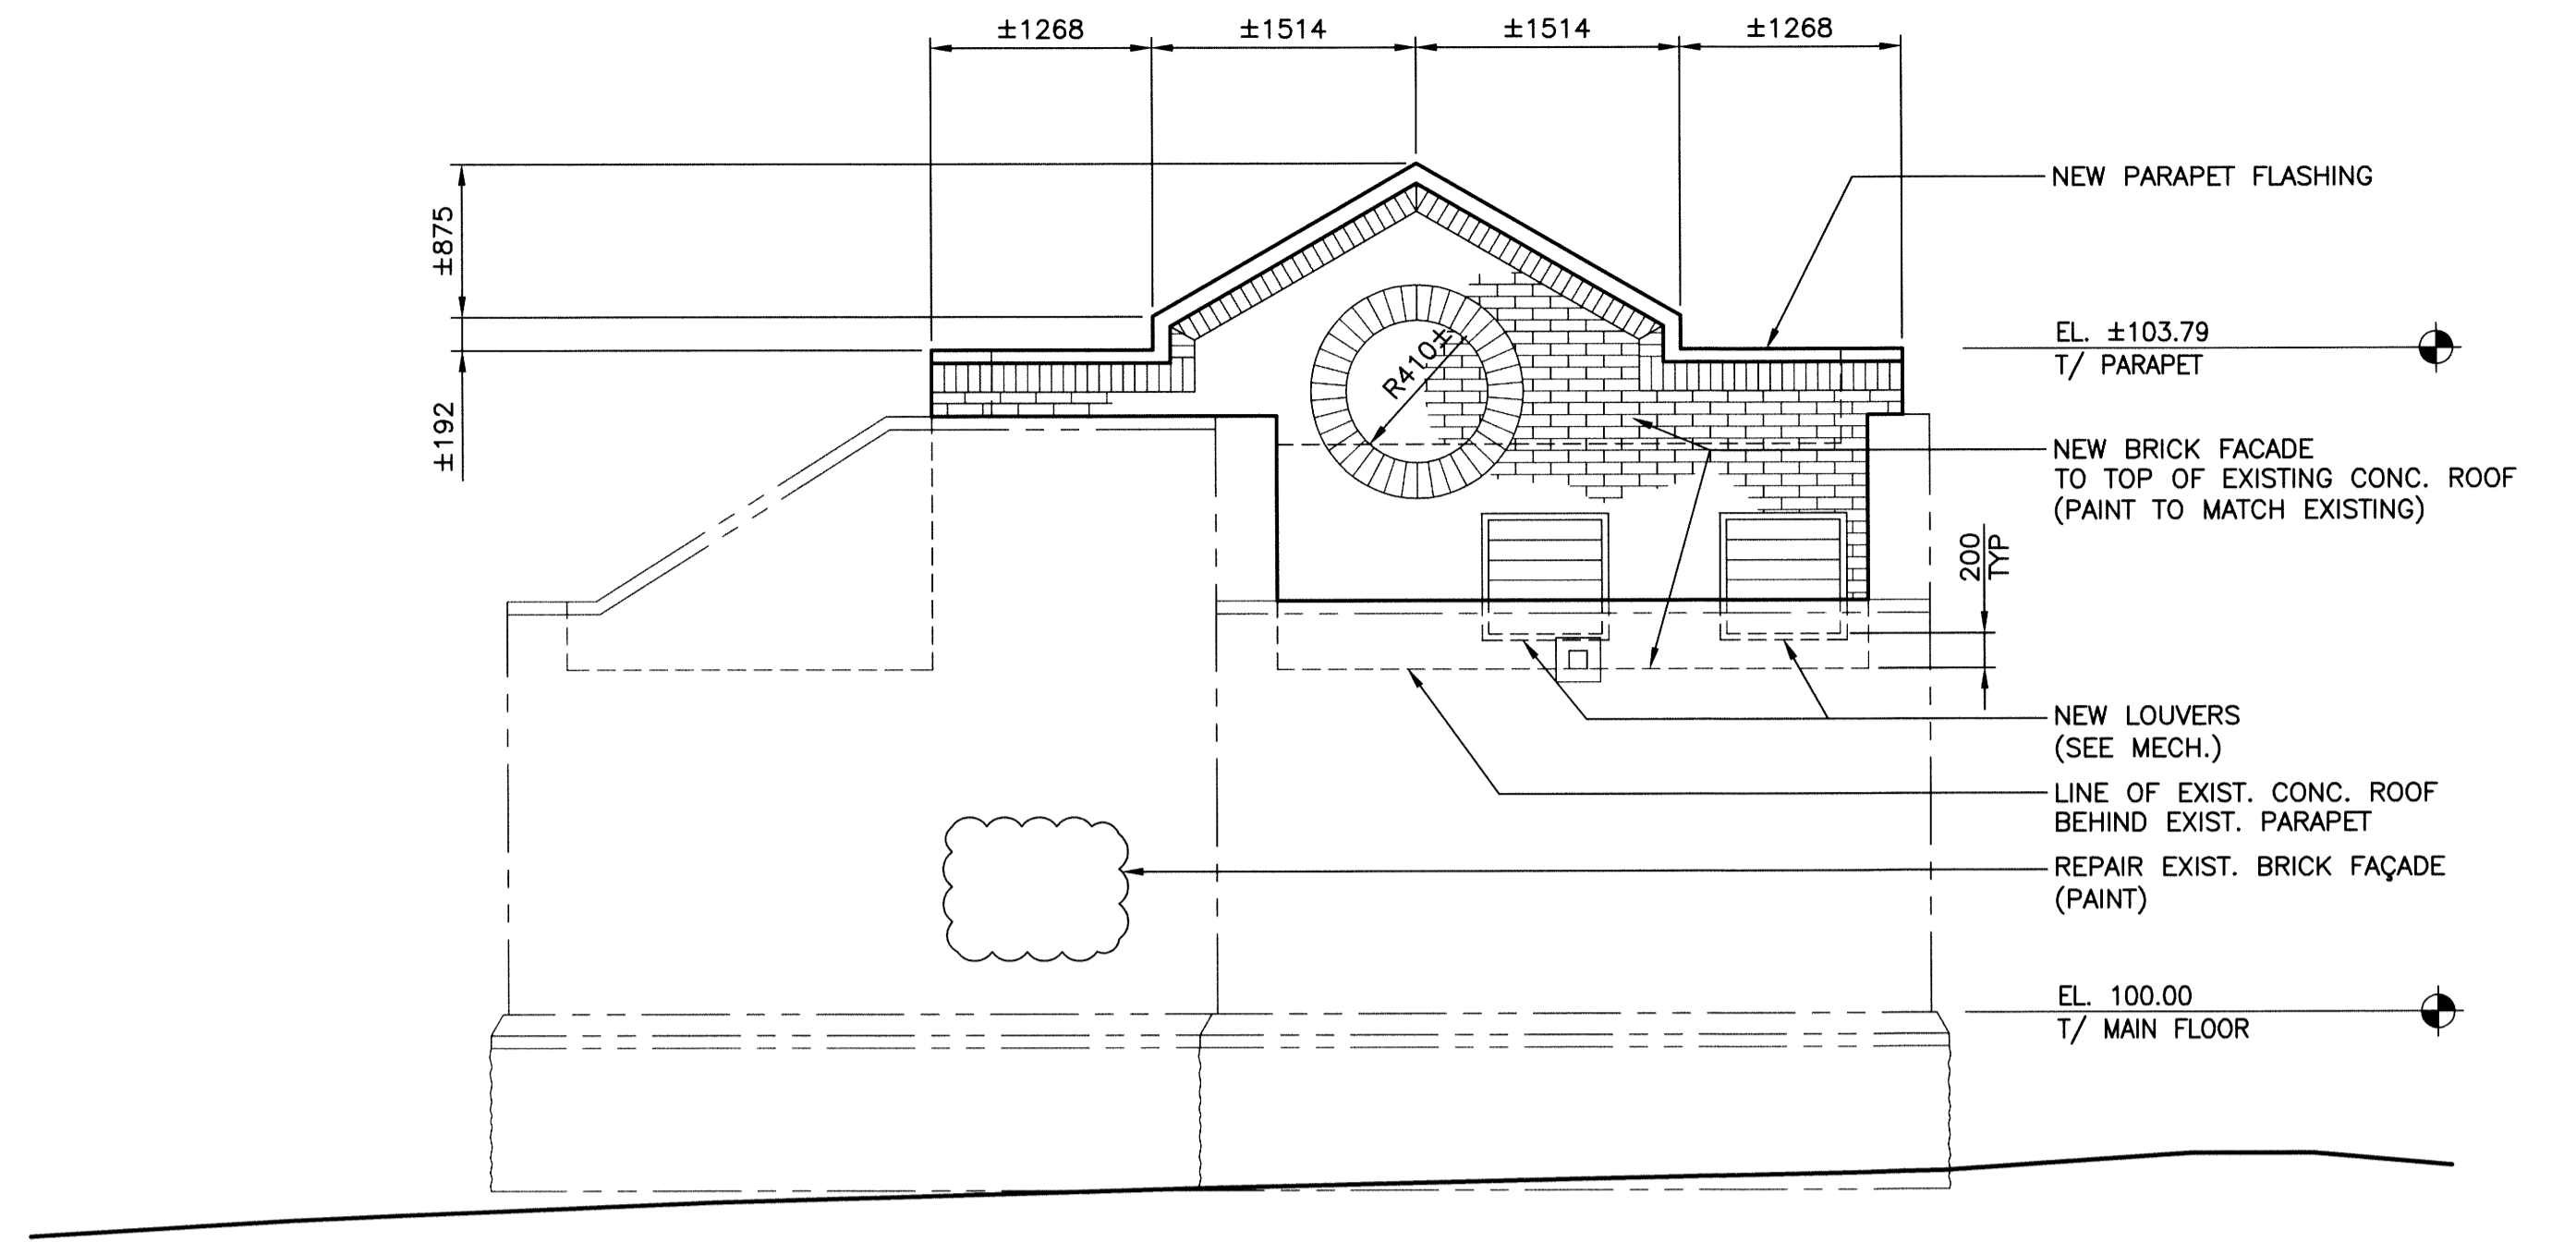

**SOUTH ELEVATION**


SCALE: 1:40

NOTE:  
PAINT COMPLETE FACE OF EXTERIOR WALL WHERE NEW BRICK IS INSTALLED

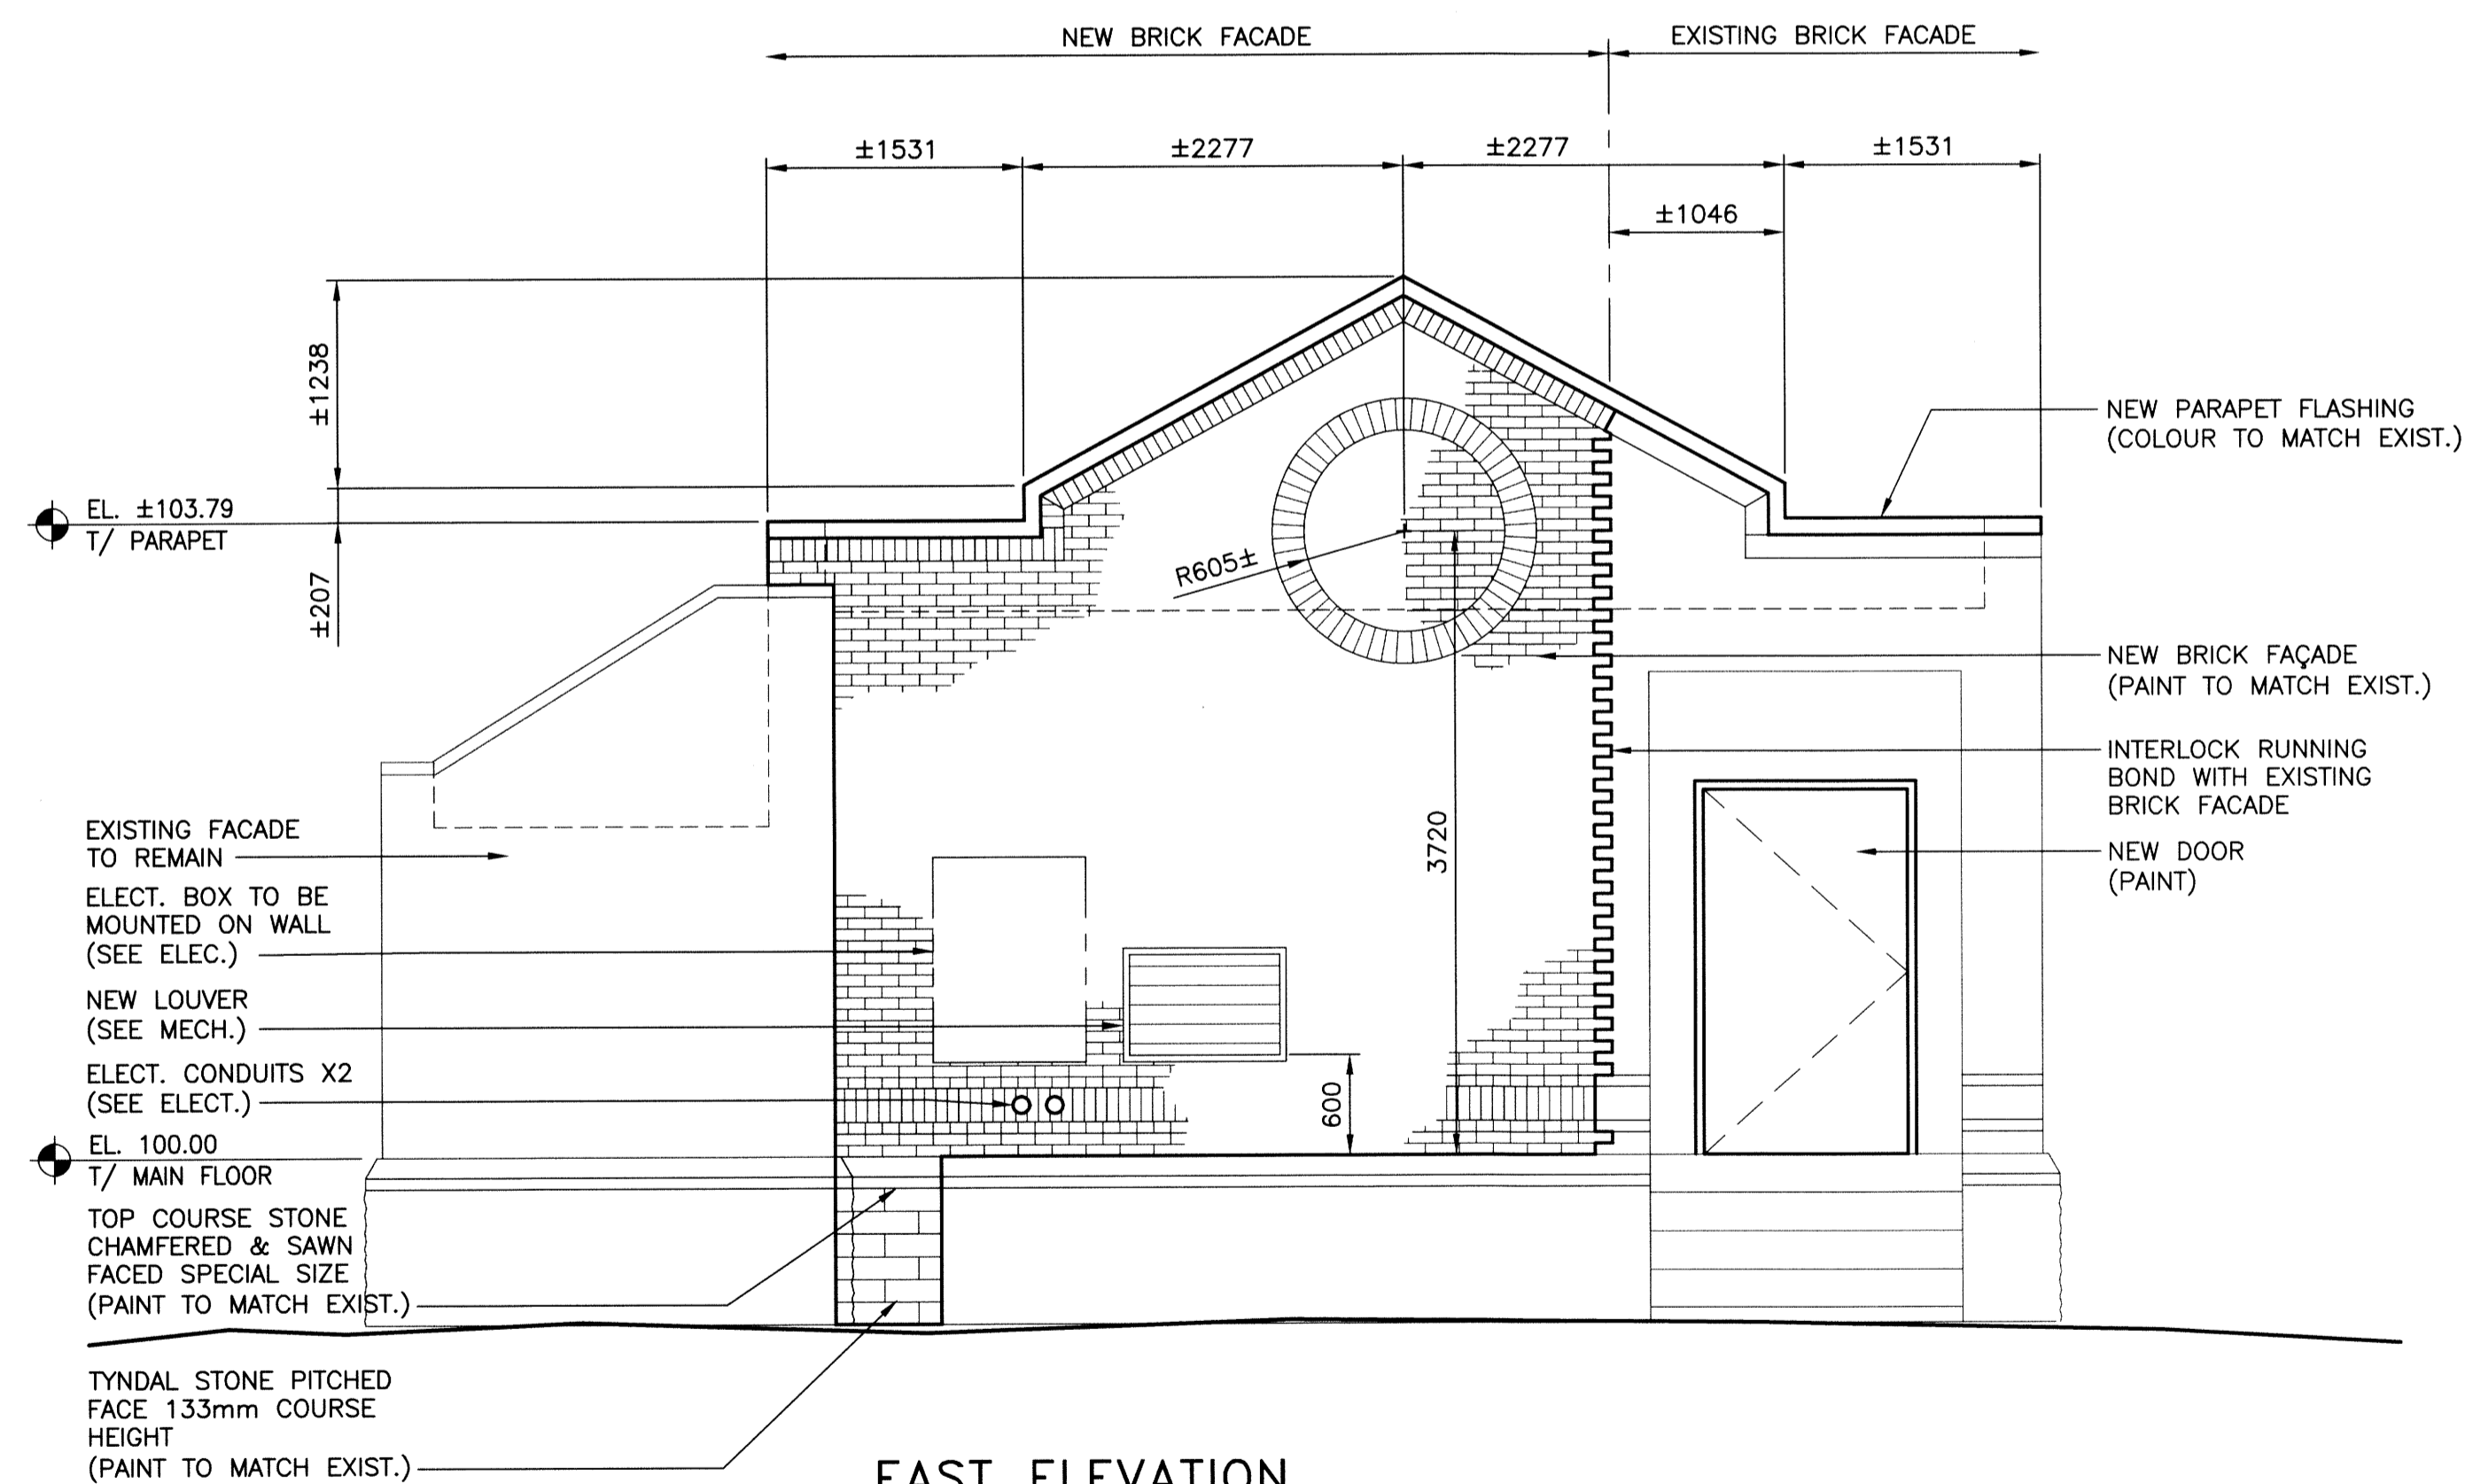

**EAST ELEVATION**

SCALE: 1:40

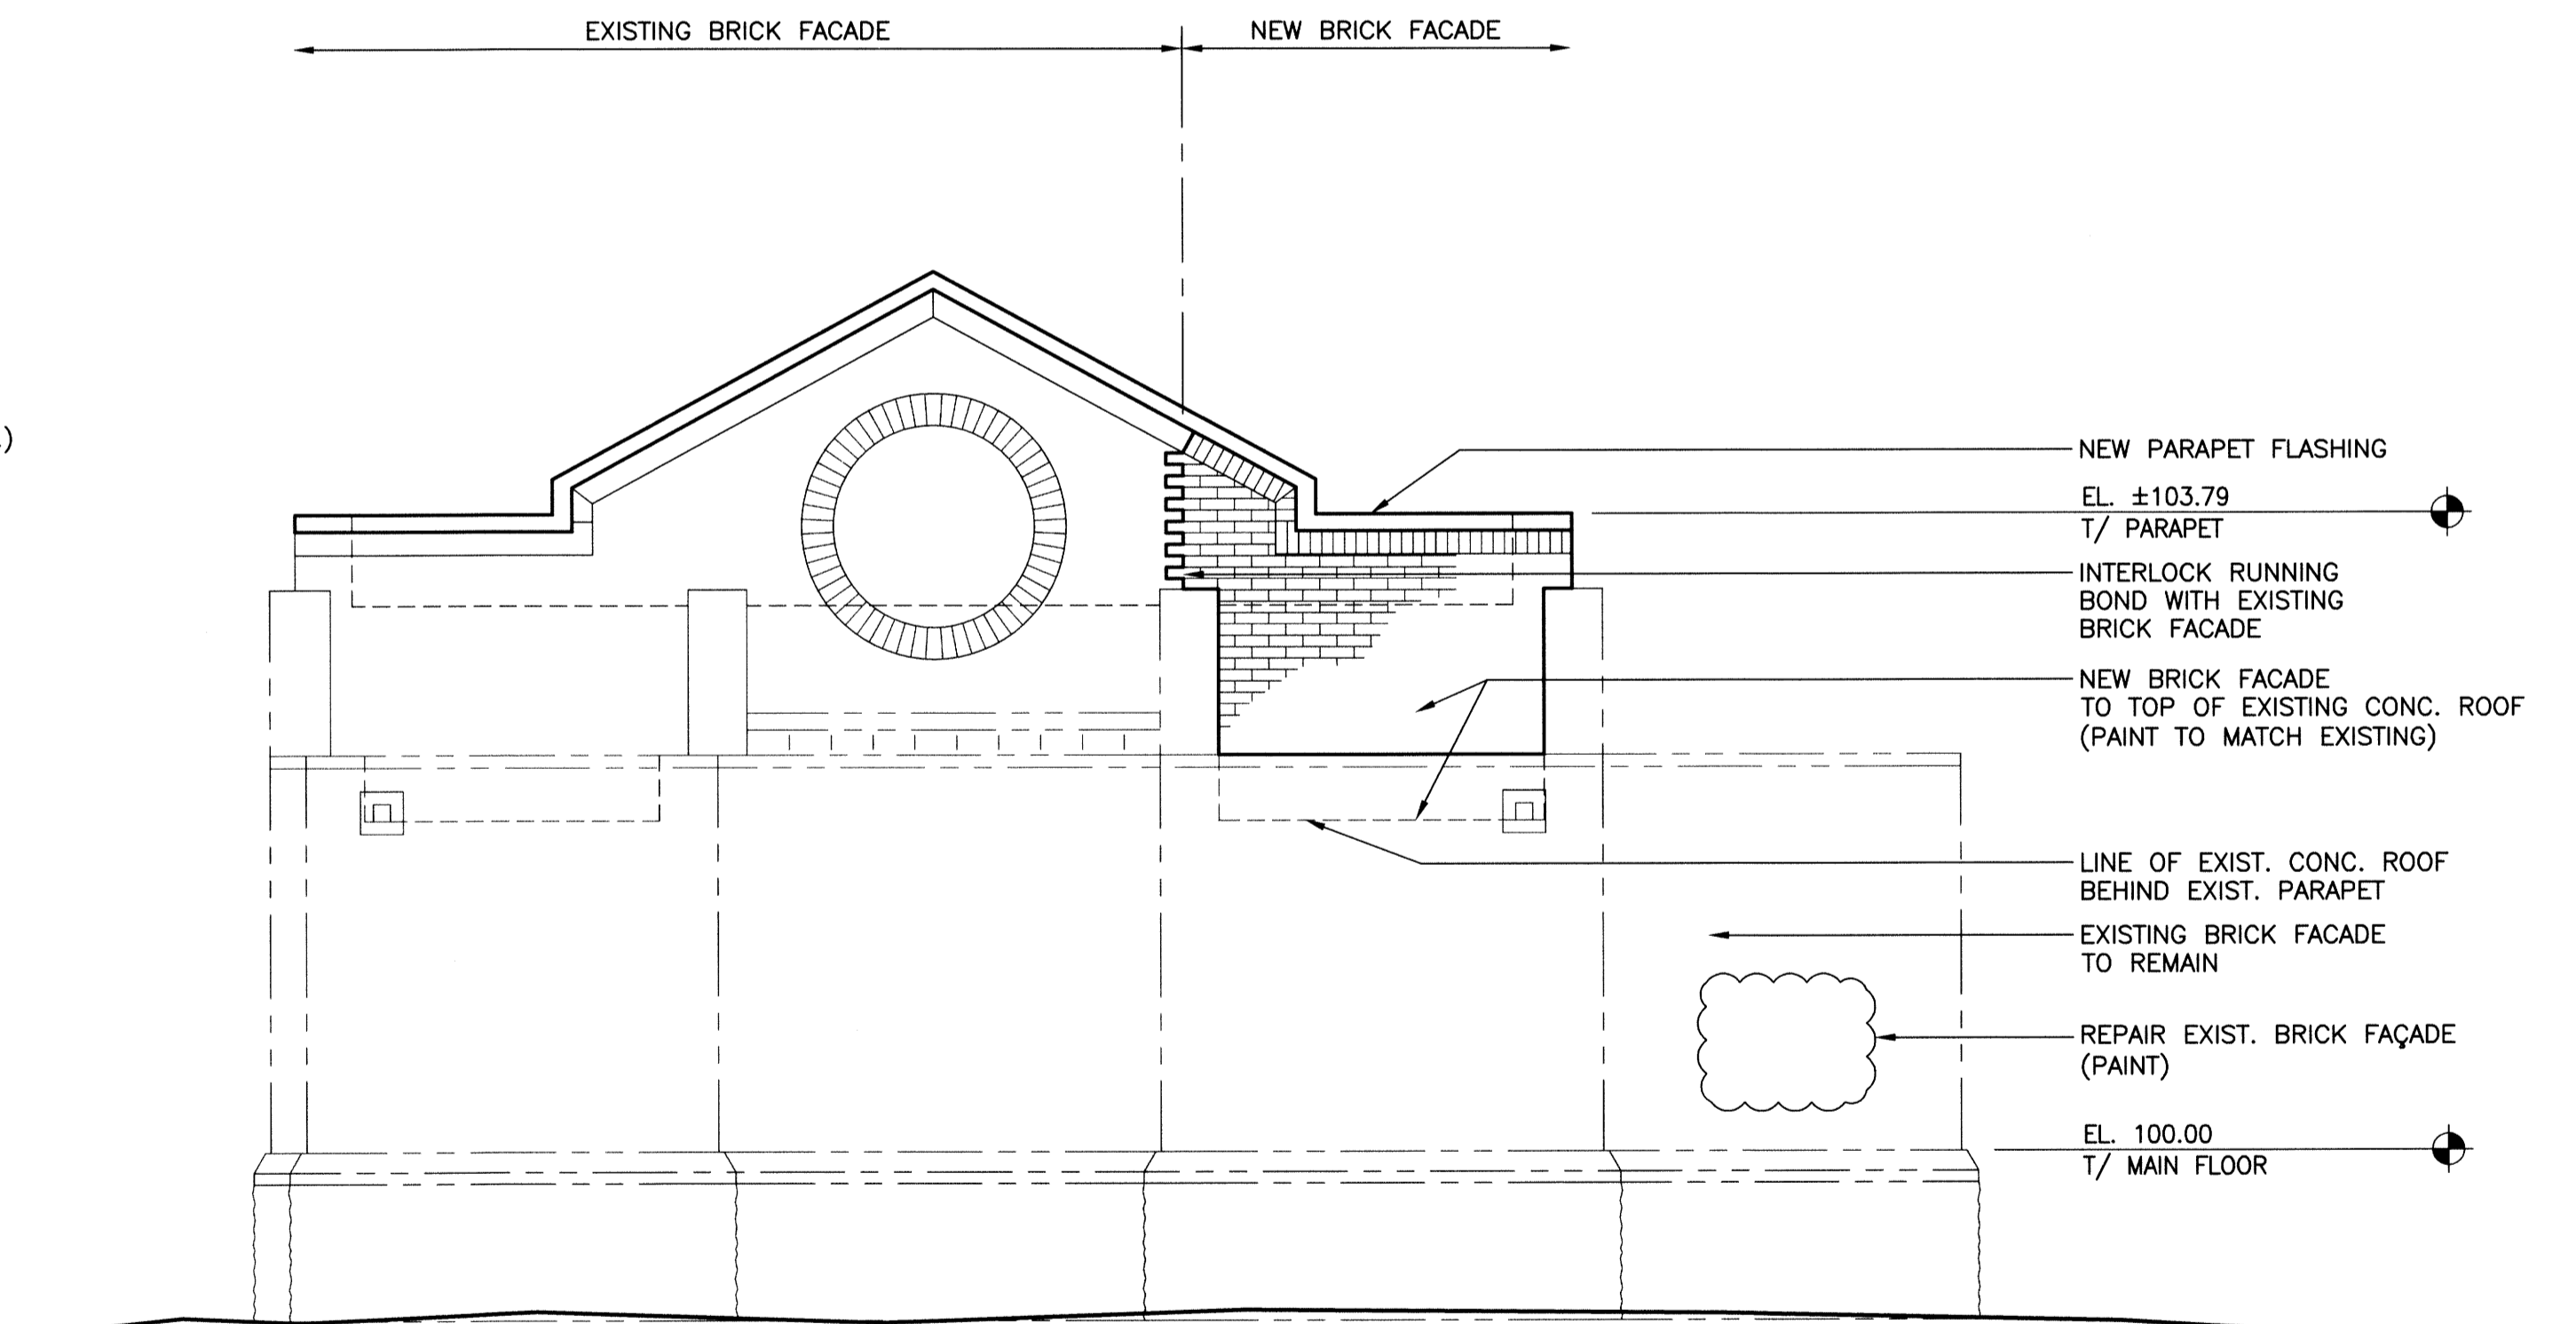

**WEST ELEVATION**


SCALE: 1:40

File Name: P:\Projects\2013\13-0107-026\Draw\Struct\13-0107-026\_D-B02.dwg - Tab: D-S01 Plotted By: dderoche 12/17/2014 [Wed 10:46am]



NO.	REVISIONS	DATE	BY	DATE
0	ISSUED FOR CONSTRUCTION	14/12/17	CMS	

DESIGNED BY CMS		CHECKED BY JMW	
DRAWN BY JAR		APPROVED BY	
HOR. SCALE AS NOTED		RELEASED FOR CONSTRUCTION	
VERTICAL AS NOTED		2014-11-24	

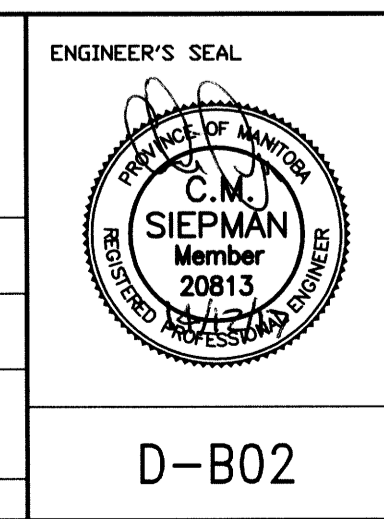

**THE CITY OF WINNIPEG**  
WATER AND WASTE DEPARTMENT

FLOOD PUMPING STATION UPGRADES  
DUMOULIN STATION

**BUILDING ELEVATIONS**

SHEET 1 OF 1  
CITY DRAWING NUMBER  
1-0139F-B0002-001

D-B02