


DEMOLITION PLAN
SCALE 1/8"=1'-0"

GENERAL NOTES

CONTRACTORS AND SUB CONTRACTORS SHALL VERIFY ALL JOB SITE DIMENSIONS, ALL DRAWINGS, DETAILS, AND SPECIFICATIONS, AND REPORT ANY DISCREPANCIES TO THE CONTRACT ADMINISTRATOR

CONTRACTORS TO FAMILIARIZE THEMSELVES WITH THE BUILDING REGULATIONS AND ADHERE TO THE REGULATIONS SET FORTH BEFORE PROCEEDING WITH CONSTRUCTION. THE CONTRACTOR TO ENSURE CONTINUOUS MAINTENANCE OF SITE DURING CONSTRUCTION OR PROTECTION OF ALL MATERIALS AND WORK DONE TO DATE.

REFERENCE SYMBOLS

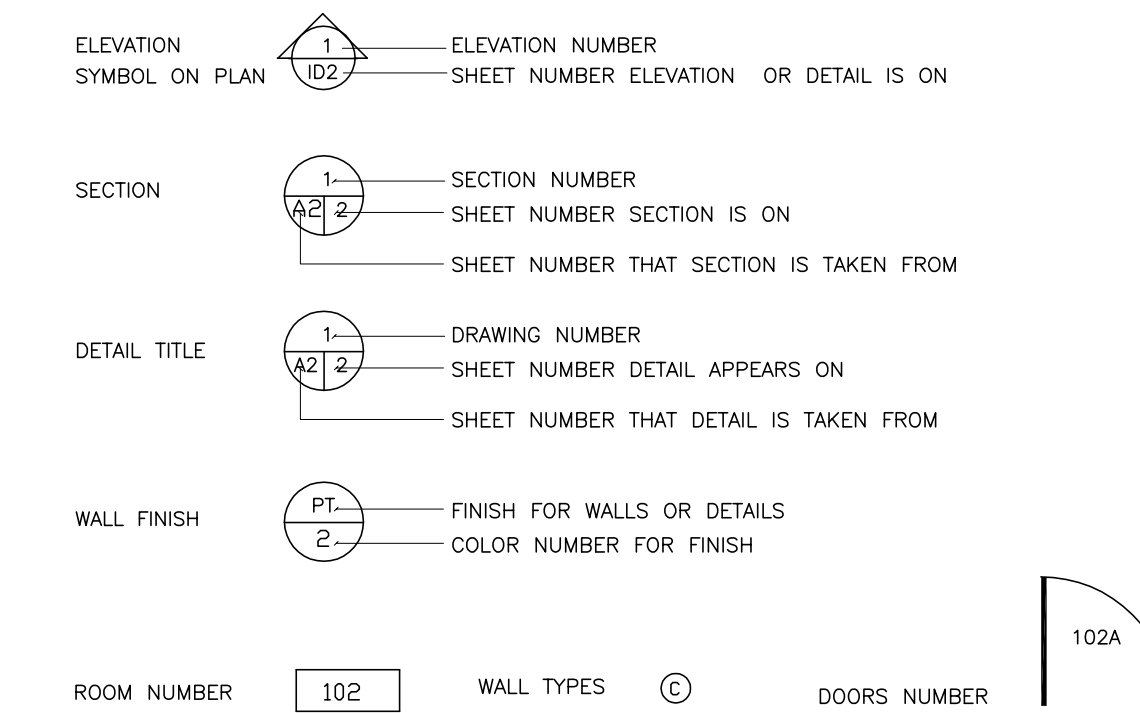

DO NOT SCALE DRAWINGS


CONTRACTOR SHALL FIELD VERIFY ALL JOB CONDITIONS AND DIMENSIONS. VARIATIONS THEREOF FROM THE DRAWINGS MUST BE REPORTED TO THE CONTRACT ADMINISTRATOR. ALL ELECTRICAL, MECHANICAL, STRUCTURAL DRAWINGS ARE SUBJECT TO VERIFICATION BY PROFESSIONAL ENGINEERS AND OR QUALIFIED TRADESMEN (AS APPROPRIATE). ENGINEERS SHOULD VERIFY THAT SPECIFICATION DO NOT VIOLATE NATIONAL OR LOCAL BUILDING, FIRE AND ELECTRICAL CODES, SUBJECT TO THE APPROVAL OF THE LOCAL AUTHORITY HAVING JURISDICTION OVER INTERPRETATION OF THE ABOVE NOTED CODES.

THE INTENT OF THE DRAWINGS IS TO INCLUDE ALL MATERIAL, LABOR, EQUIPMENT AND SERVICES NECESSARY FOR THE COMPLETION OF ALL WORK SHOWN, DESCRIBED OR REASONABLY IMPLIED.

DESIGN TEAM: MALVINE GIESBRECHT.

DRAWING INDEX

- A-1 DEMOLITION PLAN, MAIN FLOOR,, BASEMENT PLAN FOR REFERENCE ONLY
- A-2 FLOOR PLAN ELECTRICAL LAYOUT, FURNITURE PLAN
- A-3 MILLWORK PLAN, ELEVATION, HARDWARE SPECIFICATIONS,
- A-4 MILLWORK ELEVATIONS, SECTIONS, DETAILS,
- A-5 FINISH PLAN, MATERIAL LIST, ROOM FINISH SCHEDULE, DOOR SCHEDULE

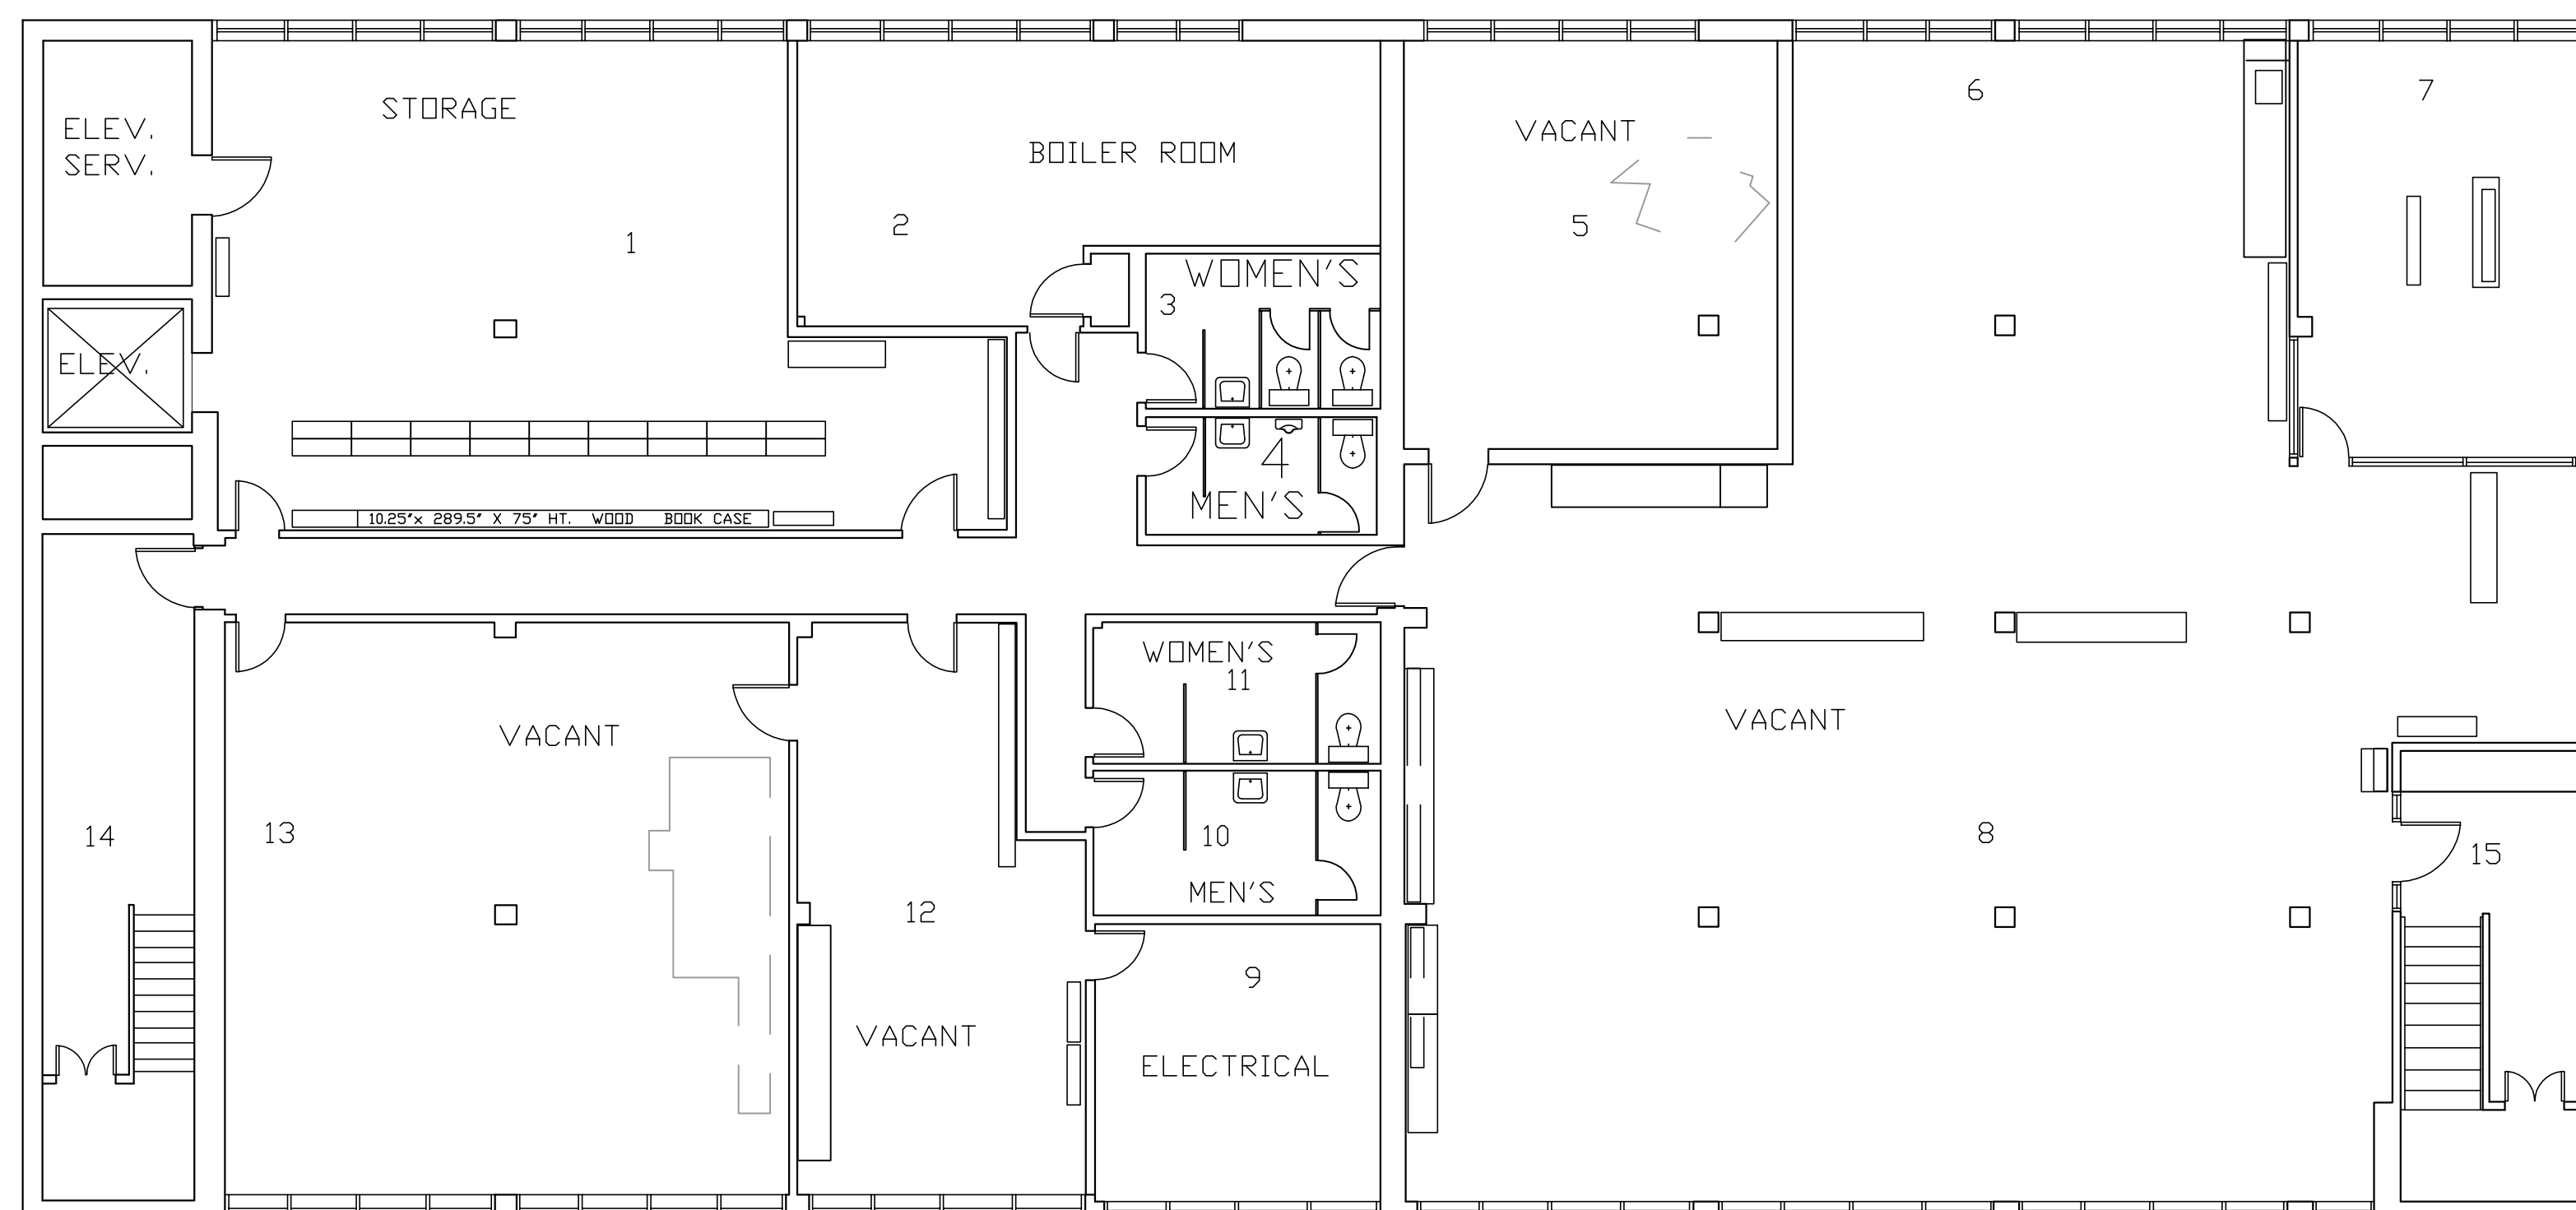

BASEMENT PLAN FOR ELECTRICAL REFERENCE ONLY
SCALE 1/8"=1'-0"



1	JAN, 13, 2014	TENDER SET	M.G.
---	---------------	------------	------

NO.	DATE	DESCRIPTION	BY

DRAWN BY
PRINTING DATE



DRAWINGS & SPECIFICATIONS, AS INSTRUMENTS OF SERVICES ARE THE PROPERTY OF SYNERGY INTERIOR DESIGN INC., THE COPYRIGHT IN THE SAME BEING RESERVED TO THEM. NO REPRODUCTION MAY BE MADE WITHOUT THE PERMISSION OF SYNERGY INTERIOR DESIGN INC. ALL PRINTS TO BE RETURNED. THE CONTRACTOR IS TO VERIFY DIMENSIONS & DATA NOTED HEREIN WITH CONDITIONS THE SITE & IS HELD RESPONSIBLE FOR REPORTING ANY DISCREPANCY.

SYNERGY INTERIOR DESIGN INC

13 Rosewarne, Avenue WINNIPEG, MB Canada R2M 0V8
204 233 9159
malvine@synergyinteriors.com

DATE OCTOBER 2013 SCALE 1/8"=1'-0" REVISIONS

DRAWN BY M.G. CHECKED BY

ST JAMES-ASSINIBOIA LIBRARY

1910 PORTAGE AVE. WINNIPEG
CITY OF WINNIPEG

AUTOCAD NUMBER

DWG. A-1