


LEGEND	EXISTING
SEWER	—
SEWER MH	○
SEWER PLUG	⊥
SEWER CB	□
SEWER STRUCT	⊞
WM	—
WM VALVE	⊗
WM HYDRANT	⊕
GAS	—
HYDRO	—
HYDRO POLE	•HP
HYDRO STR	⊞
HYDRO POLE	•H
STREET LIGHT	•
HYDRO TRANSFORMER	⊞
BOLLARD	⊗
TREE	○
SHRUBS/BUSH	⊞
CULVERT	—
DITCH	—
ROAD	—
FENCE	—
LEASED LAND	—
UNDER CULTIVATION	—
HILL CONTOURS	— 234.0

NOTE:  
HORIZONTAL DATUM: NAD83 ZONE 14 CGVD28

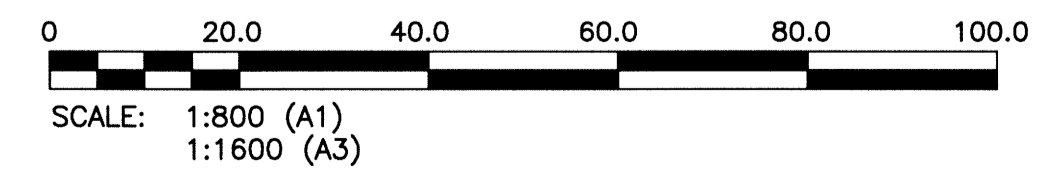

NOTE:  
1. ALL WORK SHALL BE PERFORMED IN ACCORDANCE WITH THE CITY OF WINNIPEG STANDARD CONSTRUCTION SPECIFICATIONS




B.M. BRASS PLATE LOCATED IN GRADE BEAM OF ADMINISTRATION BUILDING ELEV. 234.059	
00	ISSUED FOR TENDER
NO.	REVISIONS
DATE	DESIGN/CHECK

**CH2MHILL**  
SNC-LAVALIN GROUP

DESIGNED BY: EMS	CHECKED BY: BJM
DRAWN BY: DMW	APPROVED BY: RJH
SCALE: AS NOTED	RELEASED FOR CONSTRUCTION BY:
DATE: 2014/06/27	DATE:

CONSULTANT NO.: 13-0338-002

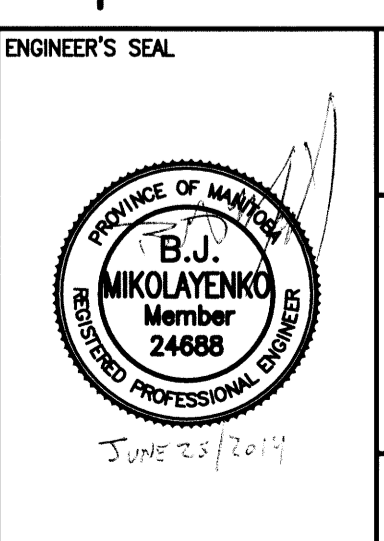

**THE CITY OF WINNIPEG**  
Winnipeg WATER AND WASTE DEPARTMENT

SOUTH END WATER POLLUTION CONTROL CENTRE  
SEWPPC UPGRADE/EXPANSION PROJECT  
CIVIL  
EXISTING SITE PLAN

CITY DRAWING NUMBER	SHEET	REV.	SIZE
1-0102-CGAD-A001	001	00	A1