


**LEGEND**

	EXISTING	NEW
SEWER	—	—
SEWER MH	○	●
SEWER PLUG	⊥	—
SEWER CB	□	—
SEWER STRUCT	□	□
WM	—	—
WM VALVE	⊗	⊗
WM HYDRANT	⊕	⊕
GAS	—	—
HYDRO	—	—
HYDRO POLE	●HP	●HP
HYDRO STR	□	□
HYDRO POLE	●H	●H
STREET LIGHT	⊙	⊙
HYDRO TRANSFORMER	⊠	⊠
BOLLARD	⊙	⊙
TREE	⊙	⊙
SHRUBS/BUSH	⊙	⊙
CULVERT	—	—
DITCH	—	—
ROAD	—	—
FENCE	—	—
LEASED LAND UNDER CULTIVATION	—	—
EXIST. STRUCTURE TO BE MODIFIED	▨	▨
NEW STRUCTURE	▨	▨
NEW ROAD	▨	▨

**NOTE:**  
1. ALL WORK SHALL BE PERFORMED IN ACCORDANCE WITH THE CITY OF WINNIPEG STANDARD CONSTRUCTION SPECIFICATIONS

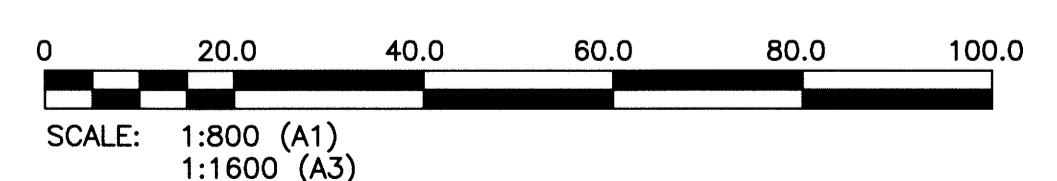

**APEGN**  
Certificate of Authorization  
KGS Group  
No. 245

B.M. BRASS PLATE LOCATED IN GRADE BEAM OF ADMINSTRATON BUILDING  
ELEV. 234.059

00	ISSUED FOR TENDER	06/2014	EMS
NO.	REVISIONS	DATE	DESIGN CHECK

**CH2MHILL.**

DESIGNED BY: EMS  
DRAWN BY: DMW  
SCALE: AS NOTED  
DATE: 2014/06/27

CHECKED BY: BJM  
APPROVED BY: RJH  
RELEASED FOR CONSTRUCTION BY:  
DATE:

CONSULTANT NO.: 13-0338-002

ENGINEER'S SEAL

**B.J. MIKOLAYENKO**  
Member 24688  
PROFESSIONAL ENGINEER

June 23/2014

**THE CITY OF WINNIPEG**  
Winnipeg WATER AND WASTE DEPARTMENT

SOUTH END WATER POLLUTION CONTROL CENTRE  
SEWPC UPGRADE/EXPANSION PROJECT  
CIVIL  
SITE PLAN NORTH

CITY DRAWING NUMBER	SHEET	REV.	SIZE
1-0102-CGAD-A002	001	00	A1