


LEGEND	EXISTING	NEW
SEWER	○	●
SEWER MH	○	●
SEWER PLUG	⊥	⊥
SEWER CB	□	□
SEWER STRUCT	□	□
WM	—	—
WM VALVE	⊕	⊕
WM HYDRANT	⊕	⊕
GAS	—	—
HYDRO	—	—
HYDRO POLE	●HP	●HP
HYDRO STR	□	□
HYDRO POLE	●H	●H
STREET LIGHT	●	●
HYDRO TRANSFORMER	⊗	⊗
BOLLARD	⊙	⊙
TREE	○	○
SHRUBS/BUSH	○	○
CULVERT	—	—
DITCH	—	—
ROAD	—	—
FENCE	—	—
LEASED LAND UNDER CULTIVATION	—	—
EXIST STRUCTURE TO BE MODIFIED	▨	▨
NEW STRUCTURE	▨	▨
NEW ROAD	▨	▨

NOTE:  
1. ALL WORK SHALL BE PERFORMED IN ACCORDANCE WITH THE CITY OF WINNIPEG STANDARD CONSTRUCTION SPECIFICATIONS

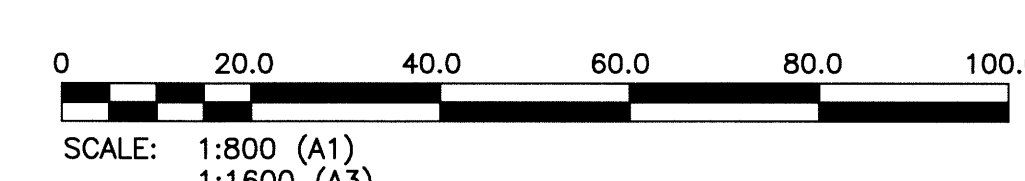


**APEGM**  
Certificate of Authorization  
KGS Group  
No. 245

B.M. BRASS PLATE LOCATED IN GRADE BEAM OF ADMINISTRATION BUILDING ELEV. 234.059			
00	ISSUED FOR TENDER	06/2014	BJM
NO.	REVISIONS	DATE	DESIGN/CHECK

**CH2MHILL.**  
SNC-LAVALIN  
DESIGNED BY: EMS  
DRAWN BY: DMW  
SCALE: AS NOTED  
DATE: 2014/06/27  
CONSULTANT NO.: 13-0338-002

**KGS GROUP**  
CHECKED BY: BJM  
APPROVED BY: RJH  
RELEASED FOR CONSTRUCTION BY:  
DATE:

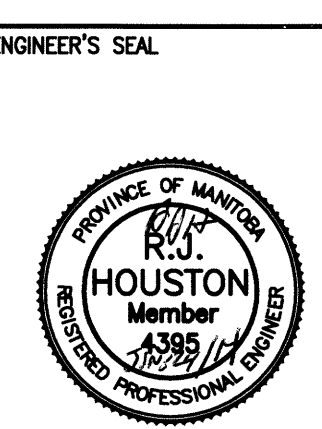

**THE CITY OF WINNIPEG**  
WATER AND WASTE DEPARTMENT

**SOUTH END WATER POLLUTION CONTROL CENTRE  
SEWPPC UPGRADE/EXPANSION PROJECT  
CIVIL  
SITE PLAN SOUTH**

CITY DRAWING NUMBER	SHEET	REV.	SIZE
1-0102-CGAD-A002	002	00	A1