


PILING PLAN
1:100


NOTES:

1. REFER TO DWG 1-0102-SGAD-A001 FOR GENERAL NOTES.
2. REFER TO DWG 1-0102-SGAD-A002 FOR OVERALL SITE PLAN AND SEQUENCING.
3. PILE DIAMETER (D) = 400mm
4. PILES CUT-OFF ELEVATION = 228.625 UNLESS NOTED OTHERWISE.
5. ESTIMATED PILE REFUSAL EL 212.000

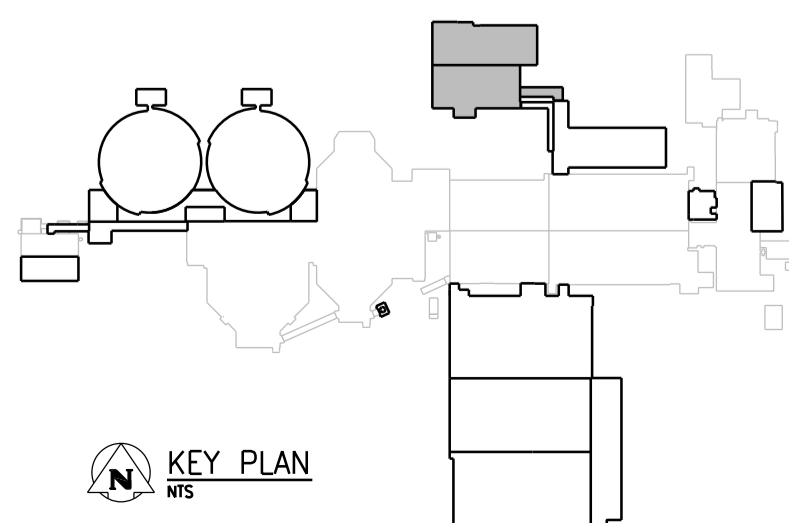

00	ISSUED FOR TENDER	06/2014	G.O.	B.W.
NO.	REVISIONS	DATE	DESIGN	CHECK

CH2MHILL		ENGINEER'S SEAL	
SNC-LAVALIN		KCS GROUP	
DESIGNED BY: E. LUI	CHECKED BY: B. WILLIAMSON		
DRAWN BY: G. OMORI	APPROVED BY: E. LUI		
SCALE: 1:100	ISSUED FOR CONSTRUCTION BY:		
DATE: 2014/06/27	DATE:		
CONSULTANT NO.: 474248		JUNE 27, 2014	

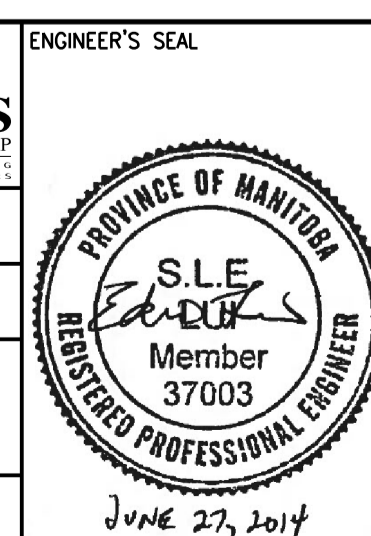

THE CITY OF WINNIPEG WATER AND WASTE DEPARTMENT		
SOUTH END WATER POLLUTION CONTROL CENTRE SEWPC UPGRADING/EXPANSION PROJECT STRUCTURAL CHEMICAL/GENERATOR BUILDING PILING PLAN		
CITY DRAWING NUMBER 1-0102-SFDW-C001	SHEET 001	REV. 00
SIZE A1		