


OVERALL PILING PLAN
1:200

- NOTES:**
- REFER TO DWG 1-0102-SGAD-A001 FOR GENERAL NOTES.
 - REFER TO DWG 1-0102-SGAD-A002 FOR OVERALL SITE PLAN AND SEQUENCING.
 - PILE DIAMETER (D) = 400mm
 - ESTIMATED PILE REFUSAL EL 210.000

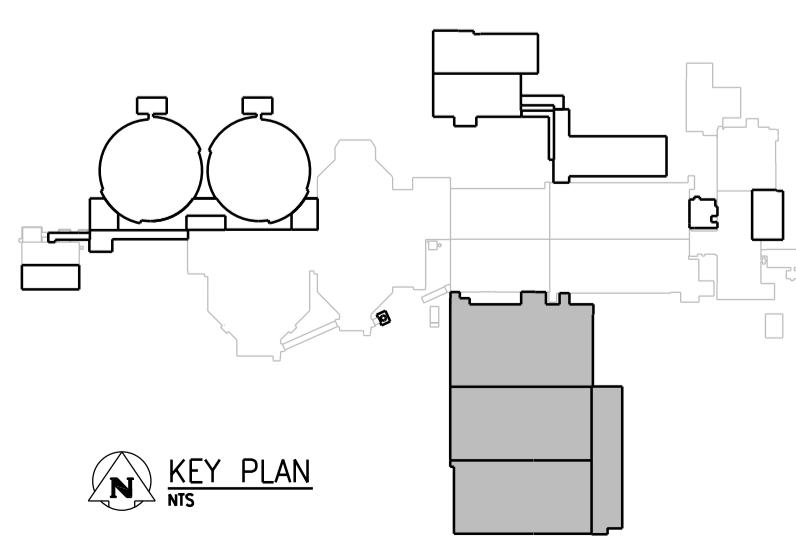

NO.	REVISIONS	DATE	DESIGN	CHECK
00	ISSUED FOR TENDER	06/2014	G.O.	B.W.

CH2MHILL		ENGINEER'S SEAL	
SNC-LAVALIN		KCS GROUP CONSULTING ENGINEERS	
DESIGNED BY: E. LUI	CHECKED BY: B. WILLIAMSON		
DRAWN BY: G. OMORI	APPROVED BY: E. LUI		
SCALE: 1:200	ISSUED FOR CONSTRUCTION BY:		
DATE: 2014/06/27	DATE:		
CONSULTANT NO.: 474248		JUNE 27, 2014	

<p>THE CITY OF WINNIPEG WATER AND WASTE DEPARTMENT</p>		
<p>SOUTH END WATER POLLUTION CONTROL CENTRE SEWPPC UPGRADING/EXPANSION PROJECT STRUCTURAL BIOREACTORS/BLOWER BUILDING OVERALL PILING PLAN</p>		
CITY DRAWING NUMBER 1-0102-SFDW-R001	SHEET 001	REV. SIZE 00 A1