


PART PILING PLAN

1:125


NOTES:

1. REFER TO DWG 1-0102-SGAD-A001 FOR GENERAL NOTES.
2. REFER TO DWG 1-0102-SGAD-A002 FOR OVERALL SITE PLAN AND SEQUENCING.
3. PILE DIAMETER (D) = 400mm
4. PILE CUT-OFF ELEVATION = 225.525 UNLESS NOTED OTHERWISE.
5. ESTIMATED PILE REFUSAL EL 210.000

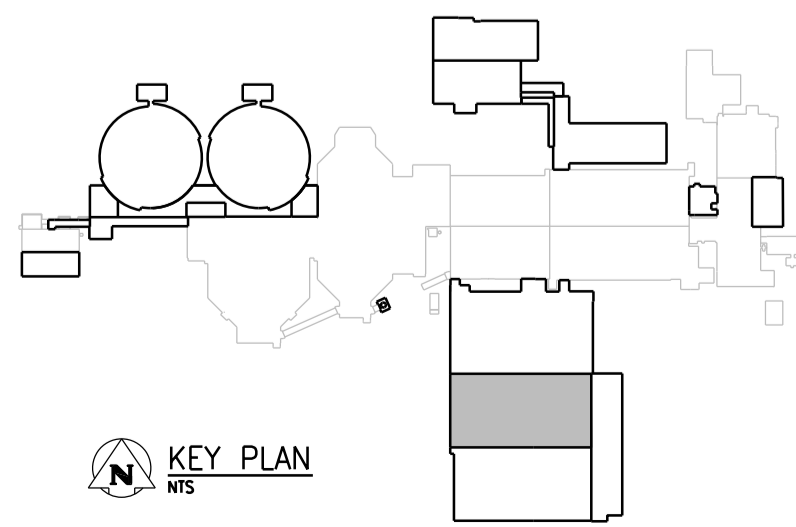

NO.	REVISIONS	DATE	DESIGN	CHECK
00	ISSUED FOR TENDER	06/2014	G.O. B.W.	

CH2MHILL		KCS GROUP	
DESIGNED BY: E. LUI	CHECKED BY: B. WILLIAMSON		
DRAWN BY: G. OMORI	APPROVED BY: E. LUI		
SCALE: 1:125	ISSUED FOR CONSTRUCTION DATE:		
DATE: 2014/06/27	DATE:		
CONSULTANT NO.: 474248			

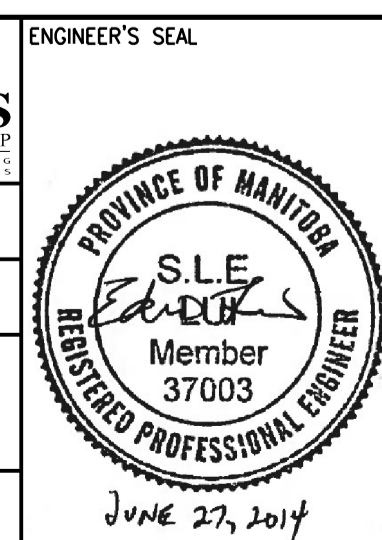

THE CITY OF WINNIPEG
Winnipeg WATER AND WASTE DEPARTMENT

SOUTH END WATER POLLUTION CONTROL CENTRE
SEWPPC UPGRADING/EXPANSION PROJECT

STRUCTURAL
BIOREACTORS/BLOWER BUILDING
PART PILING PLAN (2)

CITY DRAWING NUMBER: 1-0102-SFDW-R003
SHEET: 001
REV: 00
SIZE: A1