


PART PILING PLAN
1:125

- NOTES:**
- REFER TO DWG 1-0102-SGD-A001 FOR GENERAL NOTES.
 - REFER TO DWG 1-0102-SGD-A002 FOR OVERALL SITE PLAN AND SEQUENCING.
 - PILE DIAMETER (D) = 400mm
 - PILE CUT-OFF ELEVATION = 225.525 UNLESS NOTED OTHERWISE.
 - ESTIMATED PILE REFUSAL EL 210.000

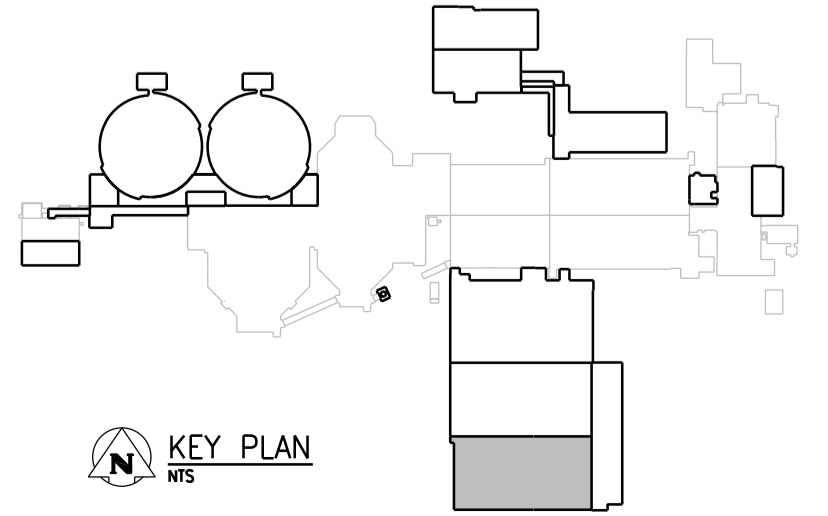

 SNC-LAVALIN DESIGNED BY: E. LUI DRAWN BY: G. OMORI SCALE: 1:125 DATE: 2014/06/27 CONSULTANT NO.: 474248		ENGINEER'S SEAL 		 WATER AND WASTE DEPARTMENT SOUTH END WATER POLLUTION CONTROL CENTRE SEWPCC UPGRADING/EXPANSION PROJECT STRUCTURAL BIOREACTORS/BLOWER BUILDING PART PILING PLAN (3)
		CHECKED BY: B. WILLIAMSON APPROVED BY: E. LUI ISSUED FOR CONSTRUCTION BY: DATE:		
00 ISSUED FOR TENDER NO. REVISIONS	06/2014 DATE	G.O. B.W. DESIGN CHECK	CITY DRAWING NUMBER 1-0102-SFDW-R004	
			SHEET 001	REV. 00
			SIZE A1	

FILE NAME: 1-0102-SFDW-R004.dgn