


PILING PLAN
1:50




NOTES:

1. REFER TO DWG 1-0102-SGAD-A001 FOR GENERAL NOTES.
2. REFER TO DWG 1-0102-SGAD-A002 FOR OVERALL SITE PLAN AND SEQUENCING.
3. PILE DIAMETER (D) = 400mm
4. ESTIMATED PILE REFUSAL EL 211.000

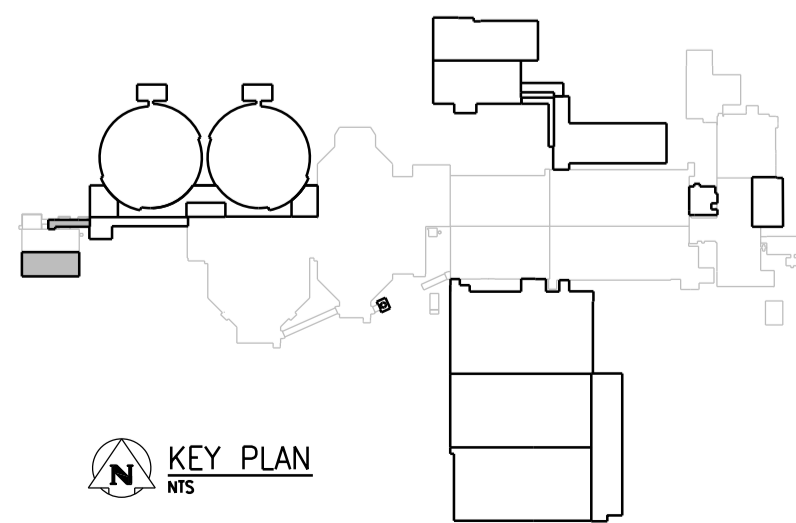

NO.	REVISIONS	DATE	DESIGN	CHECK
00	ISSUED FOR TENDER	06/2014	G.O.	B.W.

CH2MHILL		KCS GROUP	
SNC-LAVALIN		ENGINEERING CONSULTANTS	
DESIGNED BY: E. LUI	CHECKED BY: B. WILLIAMSON	APPROVED BY: E. LUI	
DRAWN BY: G. OMORI		ISSUED FOR CONSTRUCTION	
SCALE: 1:50		DATE: 2014/06/27	
CONSULTANT NO.: 474248		DATE:	

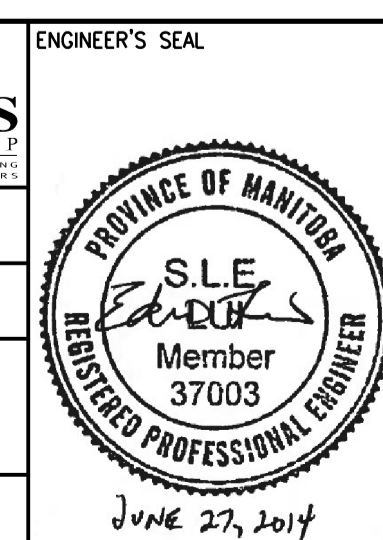

THE CITY OF WINNIPEG
Winnipeg WATER AND WASTE DEPARTMENT

SOUTH END WATER POLLUTION CONTROL CENTRE
SEWPCU UPGRADING/EXPANSION PROJECT
STRUCTURAL
UV DISINFECTION FACILITY
PILING PLAN

CITY DRAWING NUMBER: 1-0102-SFDW-U001 | SHEET: 001 | REV: 00 | SIZE: A1