
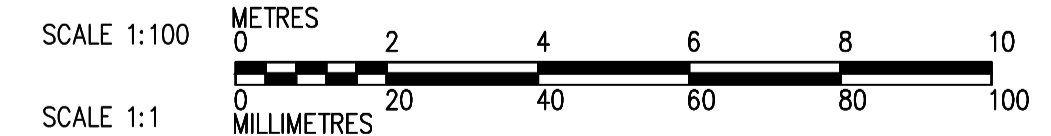


- NOTES:**
- SEE CONSULTANT DRAWING No. WB-E0512 MCC #1A & #1B SINGLE LINE DIAGRAM FOR 600V POWER DISTRIBUTION.
 - ALL 120V AND 208V LOADS ARE FED FROM LP-M11.
 - PROVIDE TRANSFORMER GROUNDING TO THE REQUIREMENT OF MANITOBA HYDRO. REFER TO DETAIL WB-E0456 FOR MINIMUM REQUIREMENT.
 - SEE CBD-M-4 FOR MISCELLANEOUS COMMUNICATION NET WORK WIRING BETWEEN SWITCHGEAR, MCC'S, AND LCP'S.

FIRST FLOOR PROCESS PLAN

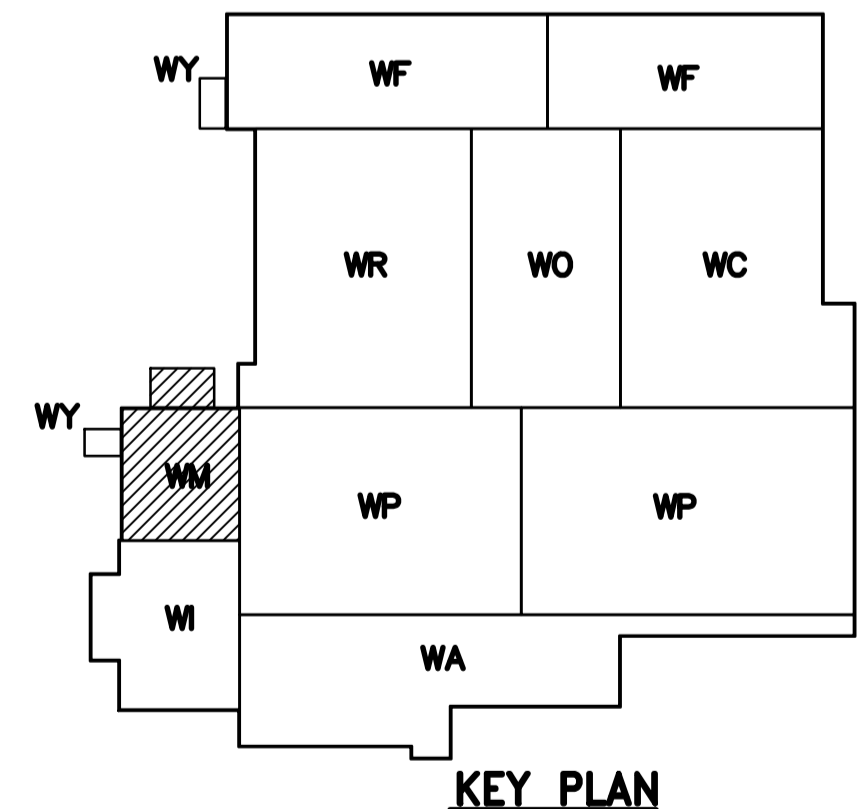

<p>Certificate of Authorization Dillon Consulting Limited (MB) No. 1789 Date: 2014-06-13</p>	<table border="1"> <tr> <th>B.M. ELEV.</th> <th>DATE</th> <th>BY</th> </tr> <tr> <td> </td> <td> </td> <td> </td> </tr> </table>		B.M. ELEV.	DATE	BY							<p>THE CITY OF WINNIPEG WATER AND WASTE DEPARTMENT ENGINEERING DIVISION</p>		<p>CITY FILE NUMBER</p>																					
	B.M. ELEV.	DATE	BY																																
<table border="1"> <tr> <th>NO.</th> <th>REVISIONS</th> <th>DATE</th> <th>BY</th> </tr> <tr> <td>05</td> <td>ISSUED FOR TENDER</td> <td>14/06/13</td> <td>BLM</td> </tr> <tr> <td>04</td> <td>AS CONSTRUCTED</td> <td>09/11/04</td> <td>ACL</td> </tr> <tr> <td>03</td> <td>ISSUED FOR CONSTRUCTION</td> <td>06/07/28</td> <td>LL</td> </tr> <tr> <td>02</td> <td>742-2005 ADDENDUM 4</td> <td>06/05/12</td> <td>LL</td> </tr> <tr> <td>01</td> <td>742-2005-ADDENDUM 3</td> <td>06/05/05</td> <td>LL</td> </tr> <tr> <td>00</td> <td>ISSUED FOR TENDER</td> <td>06/03/28</td> <td>LL</td> </tr> </table>			NO.	REVISIONS	DATE	BY	05	ISSUED FOR TENDER	14/06/13	BLM	04	AS CONSTRUCTED	09/11/04	ACL	03	ISSUED FOR CONSTRUCTION	06/07/28	LL	02	742-2005 ADDENDUM 4	06/05/12	LL	01	742-2005-ADDENDUM 3	06/05/05	LL	00	ISSUED FOR TENDER	06/03/28	LL	<p>DESIGNED BY: JT</p> <p>DRAWN BY: KJ</p> <p>SCALE: 1:100</p> <p>DATE: 2005/06/30</p>	<p>CHECKED BY: ND</p> <p>APPROVED BY:</p> <p>RELEASED FOR CONSTRUCTION BY:</p> <p>DATE:</p>	<p>CONSULTANT DRAWING NO. WM-E0112</p>	<p>WATER TREATMENT PLANT GENERAL PLANT SERVICES/MISCELLANEOUS MECHANICAL AND ELECTRICAL</p>	<p>SHEET OF</p> <p>CITY DRAWING NUMBER 1-0601M-ED019-001-05</p>
NO.	REVISIONS	DATE	BY																																
05	ISSUED FOR TENDER	14/06/13	BLM																																
04	AS CONSTRUCTED	09/11/04	ACL																																
03	ISSUED FOR CONSTRUCTION	06/07/28	LL																																
02	742-2005 ADDENDUM 4	06/05/12	LL																																
01	742-2005-ADDENDUM 3	06/05/05	LL																																
00	ISSUED FOR TENDER	06/03/28	LL																																