




1 PARTIAL PLAN AT 245.00  
1:50

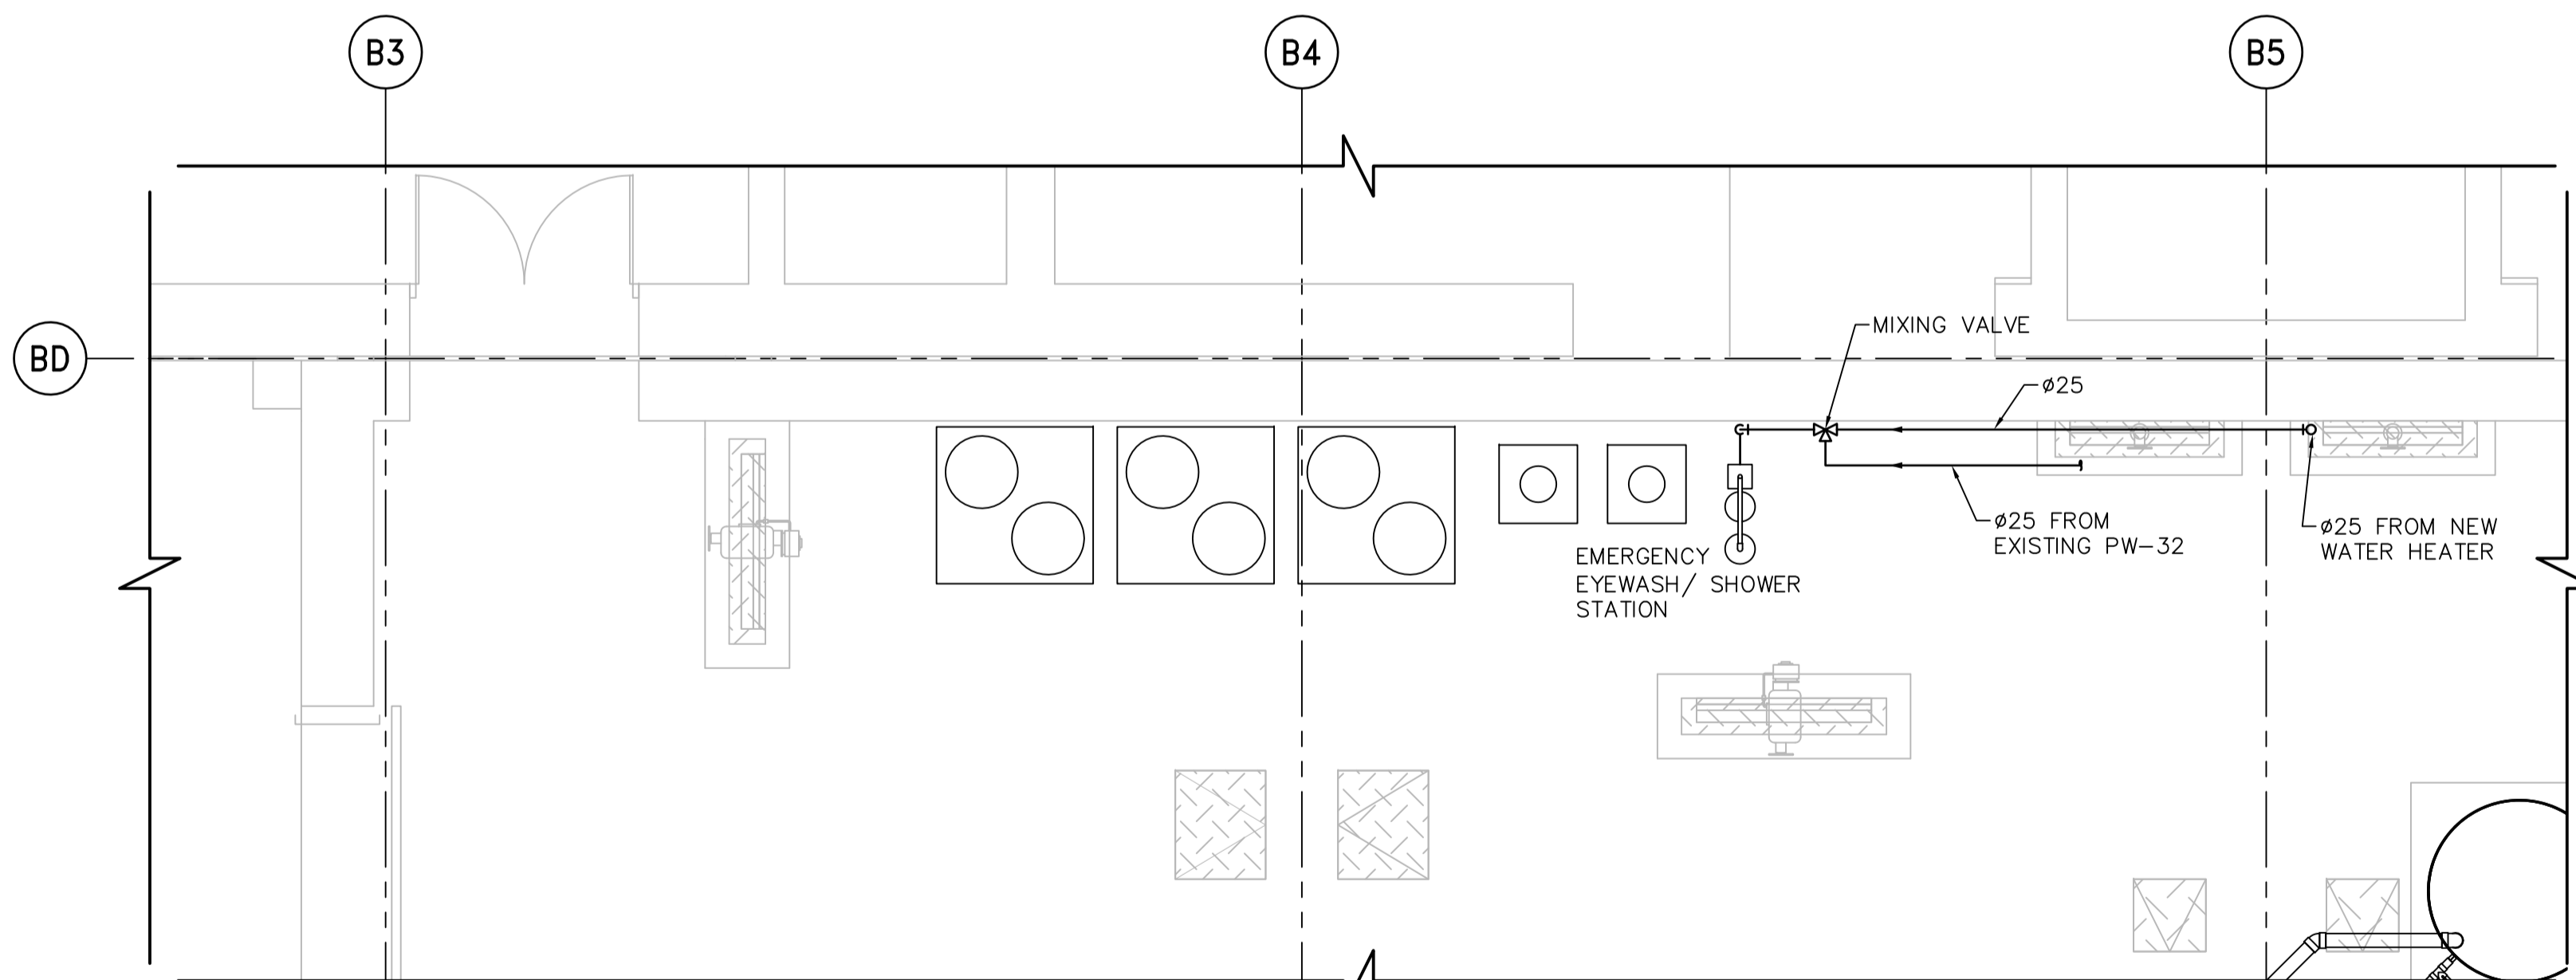

2 PARTIAL PLAN AT 239.410  
1:50

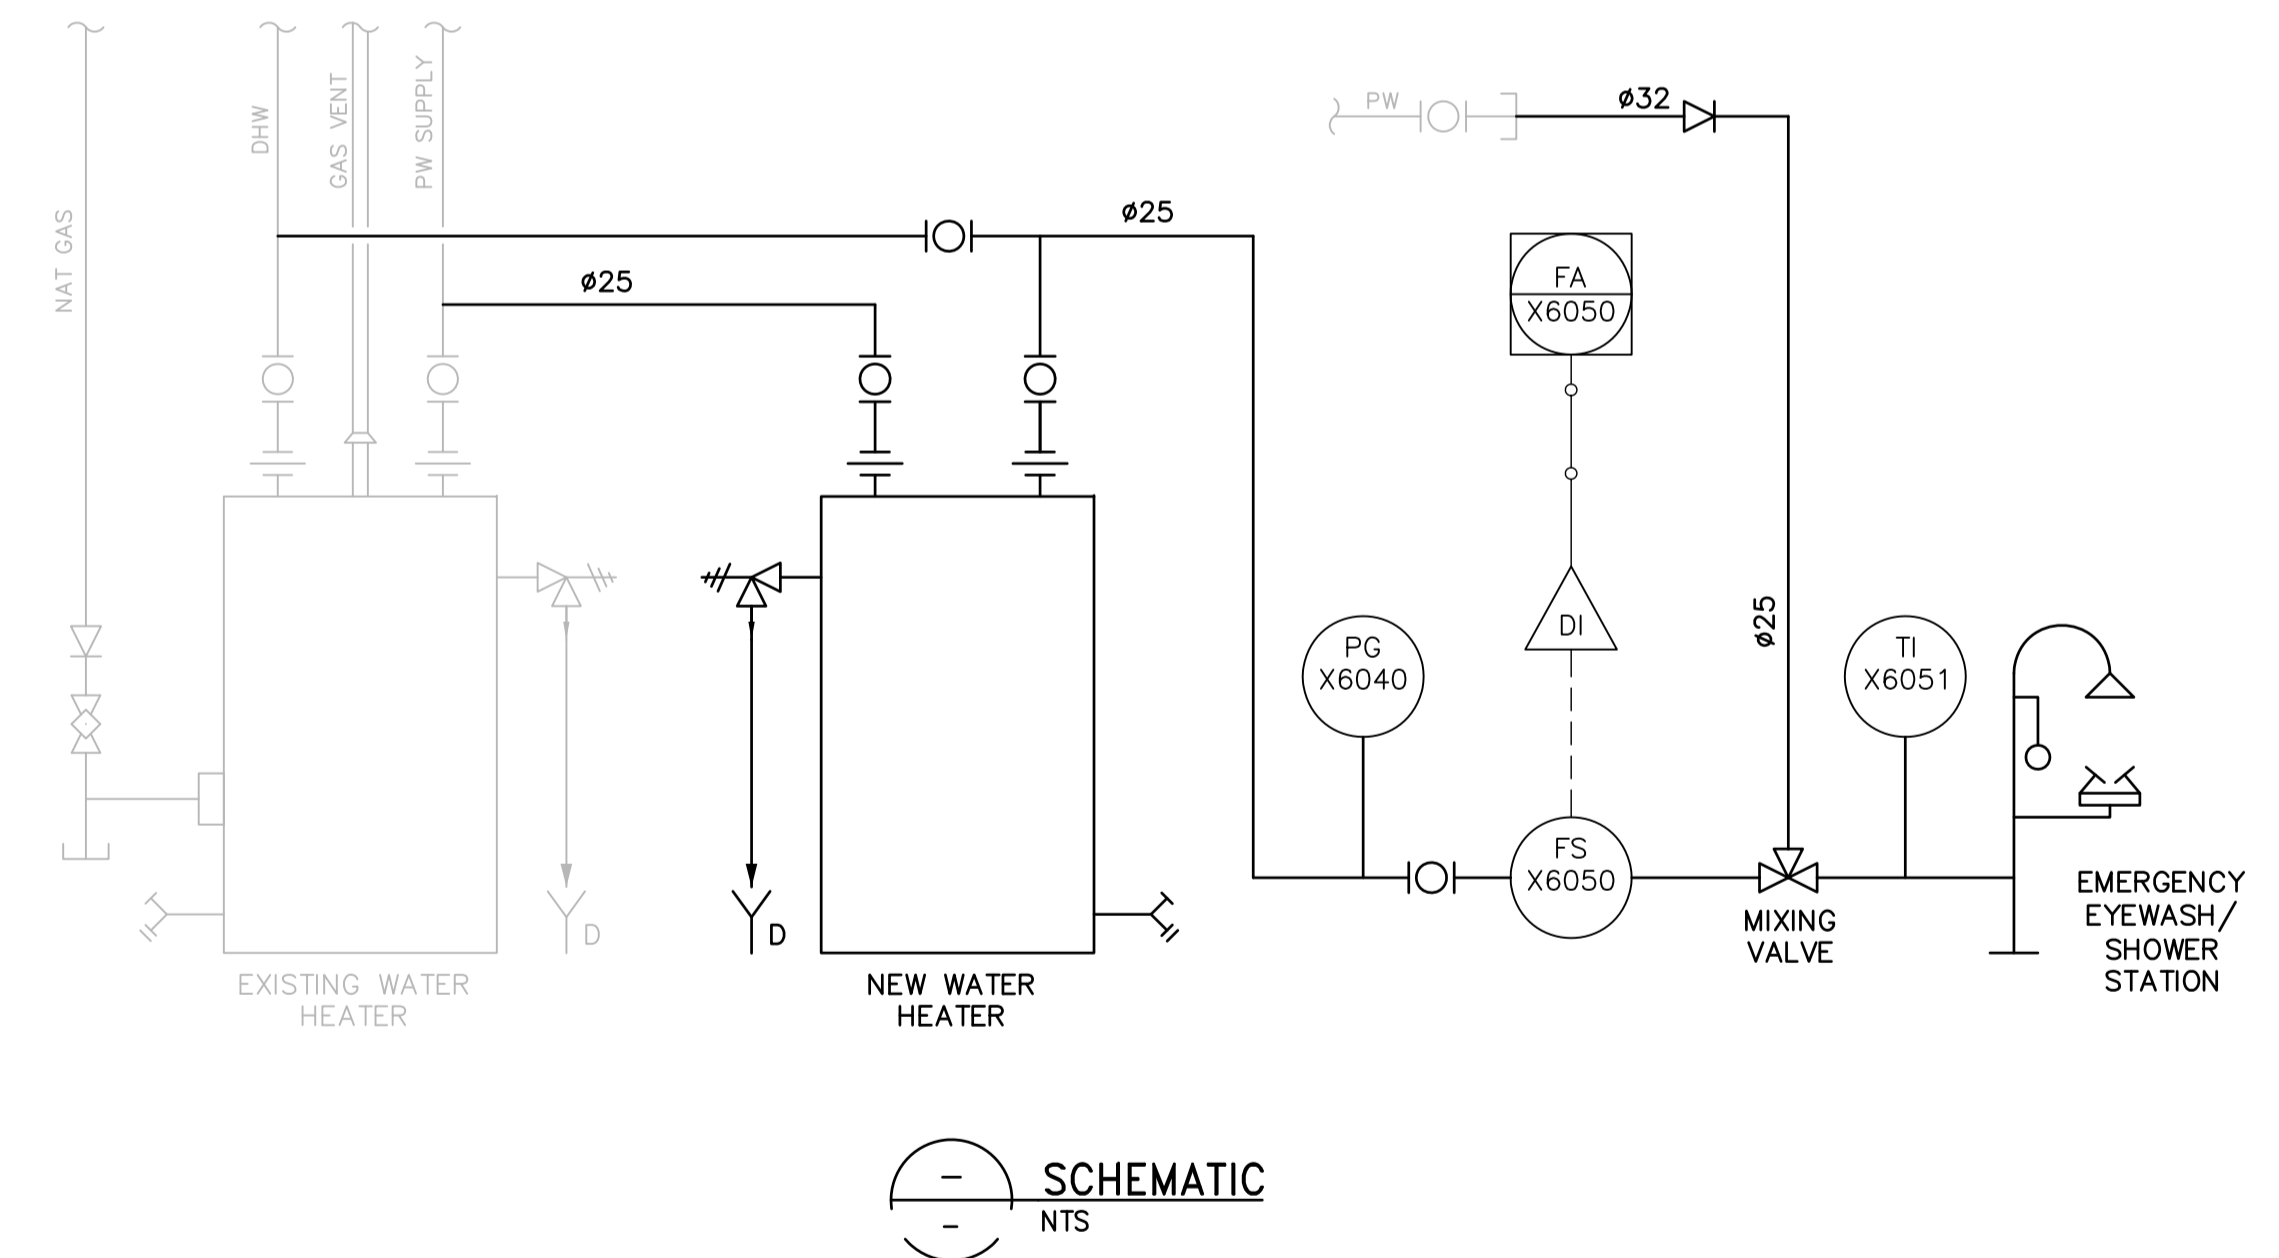

SCHEMATIC  
NTS

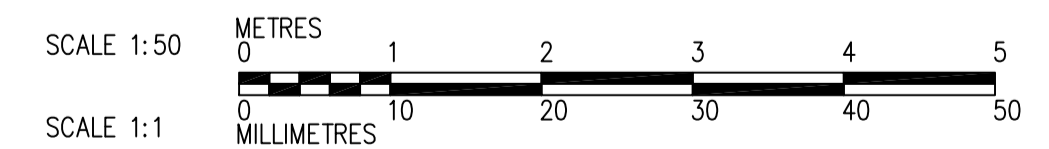

REFERENCE DRAWINGS:

1-0601R-H0005-001-03 PLUMBING RESIDUALS AREA THIRD FLOOR PLAN

B.M. ELEV.			
CONSTRUCTION COMPLETION DATE: YYYY MM DD			
DESIGNED BY	KG	CHECKED BY	BW
DRAWN BY	JBC	APPROVED BY	BW
SCALE: HORIZONTAL	1:50	RELEASED FOR CONSTRUCTION	
SCALE: VERTICAL	-	DATE	2014 06 13
ISSUED FOR TENDER	14/06/13	JBC	
NO.	REVISIONS	DATE	BY



DESIGNED BY	KG	CHECKED BY	BW
DRAWN BY	JBC	APPROVED BY	BW
SCALE: HORIZONTAL	1:50	RELEASED FOR CONSTRUCTION	
SCALE: VERTICAL	-	DATE	2014 06 13

ENGINEER'S SEAL

CONSULTANT DRAWING NUMBER  
WX-H0122

THE CITY OF WINNIPEG  
WATER AND WASTE DEPARTMENT  
ENGINEERING DIVISION

CITY OF WINNIPEG WATER TREATMENT RESEARCH AND PROCESS OPTIMIZATION FACILITY  
PLUMBING  
PLANS AND SCHEMATIC

SHEET X OF X  
CITY DRAWING NUMBER  
1-0601X-H0003-001-00

BID OPPORTUNITY: 355-2014

FILE PATH: \\WINNIPEG\Pro\WinnipegCityof\462784\Waterworks\DMS\DLV\462784-H-0122.dwg