



THE CITY OF WINNIPEG

WATER AND WASTE DEPARTMENT

4R WINNIPEG DEPOT - BRADY ROAD RESOURCE MANAGEMENT FACILITY


BID OPPORTUNITY 559-2014

DRAWING LIST

SHEET No.	TITLE	CITY DWG No.
C0	COVER SHEET	1-0400A-D0001-001
C1	HORIZONTAL GEOMETRY	1-0400A-C0001-001
C2	ROADWORKS PLAN	1-0400A-C0002-001
C3	ROADWORKS PROFILE	1-0400A-C0003-001
C4	ROADWORKS CROSS SECTIONS	1-0400A-C0004-001
C5	ROADWORKS DETAILS	1-0400A-C0005-001
C6	SIGNAGE AND LINE PAINTING	1-0400A-C0006-001
S1	GENERAL ARRANGEMENT OF STRUCTURES	1-0400A-S0001-001
S2	RETAINING WALL DETAILS 1 OF 3	1-0400A-S0002-001
S3	RETAINING WALL DETAILS 2 OF 3	1-0400A-S0002-002
S4	RETAINING WALL DETAILS 3 OF 3	1-0400A-S0002-003
S5	YARD WASTE BUNKERS AND LIGHT STANDARD BASE DETAILS	1-0400A-S0003-001
S6	SCALE FOUNDATIONS PLAN AND DETAILS	1-0400A-S0004-001
S7	SCALE HOUSE FOUNDATIONS PLAN	1-0400A-S0005-001
S8	SCALE HOUSE FOUNDATIONS SECTIONS	1-0400A-S0006-001
S9	PRE-FABRICATED KIOSK BUILDING FOUNDATION PLAN AND DETAILS	1-0400A-S0007-001
S10	CARDBOARD DISPOSAL SLAB PLAN AND DETAILS	1-0400A-S0008-001
A1	SCALE HOUSE PLAN, SCHEDULES AND MILLWORK	1-0400A-A0001-001
A2	SCALE HOUSE CROSS SECTIONS, DOOR SCHEDULE AND DETAILS	1-0400A-A0002-001
A3	SCALE HOUSE ELEVATIONS	1-0400A-A0003-001
A4	SCALE HOUSE WALL SECTIONS AND PLAN DETAILS	1-0400A-A0004-001
A5	PRE-FABRICATED KIOSK BUILDING	1-0400A-A0005-001
L1	LANDSCAPING PLAN	1-0400A-C0007-001

DRAWING LIST

SHEET No.	TITLE	CITY DWG No.
M1	SCALE HOUSE - MECHANICAL PLAN AND SECTION	1-0400A-M0001-001
M2	SCALE HOUSE - MECHANICAL SCHEDULES	1-0400A-M0002-001
E1	ONE LINE DIAGRAM	1-0400A-E0001-001
E2	SCALE HOUSE POWER PLAN	1-0400A-E0002-001
E3	SCALE HOUSE LIGHTING PLAN	1-0400A-E0003-001
E4	PRE-FABRICATED KIOSK BUILDING - POWER & LIGHTING PLAN	1-0400A-E0004-001
E5	ELECTRICAL PANEL SCHEDULES	1-0400A-E0005-001
E6	SITE PLAN LIGHTING LAYOUT	1-0400A-E0006-001
E7	SITE PLAN SECURITY CAMERAS LAYOUT	1-0400A-E0007-001
E8	SITE - ELECTRICAL DETAILS	1-0400A-E0008-001
E9	CAMERA SCALE HOUSE	1-0400A-E0009-001
E10	CAMERA PRE-FABRICATED KIOSK BUILDING	1-0400A-E0010-001

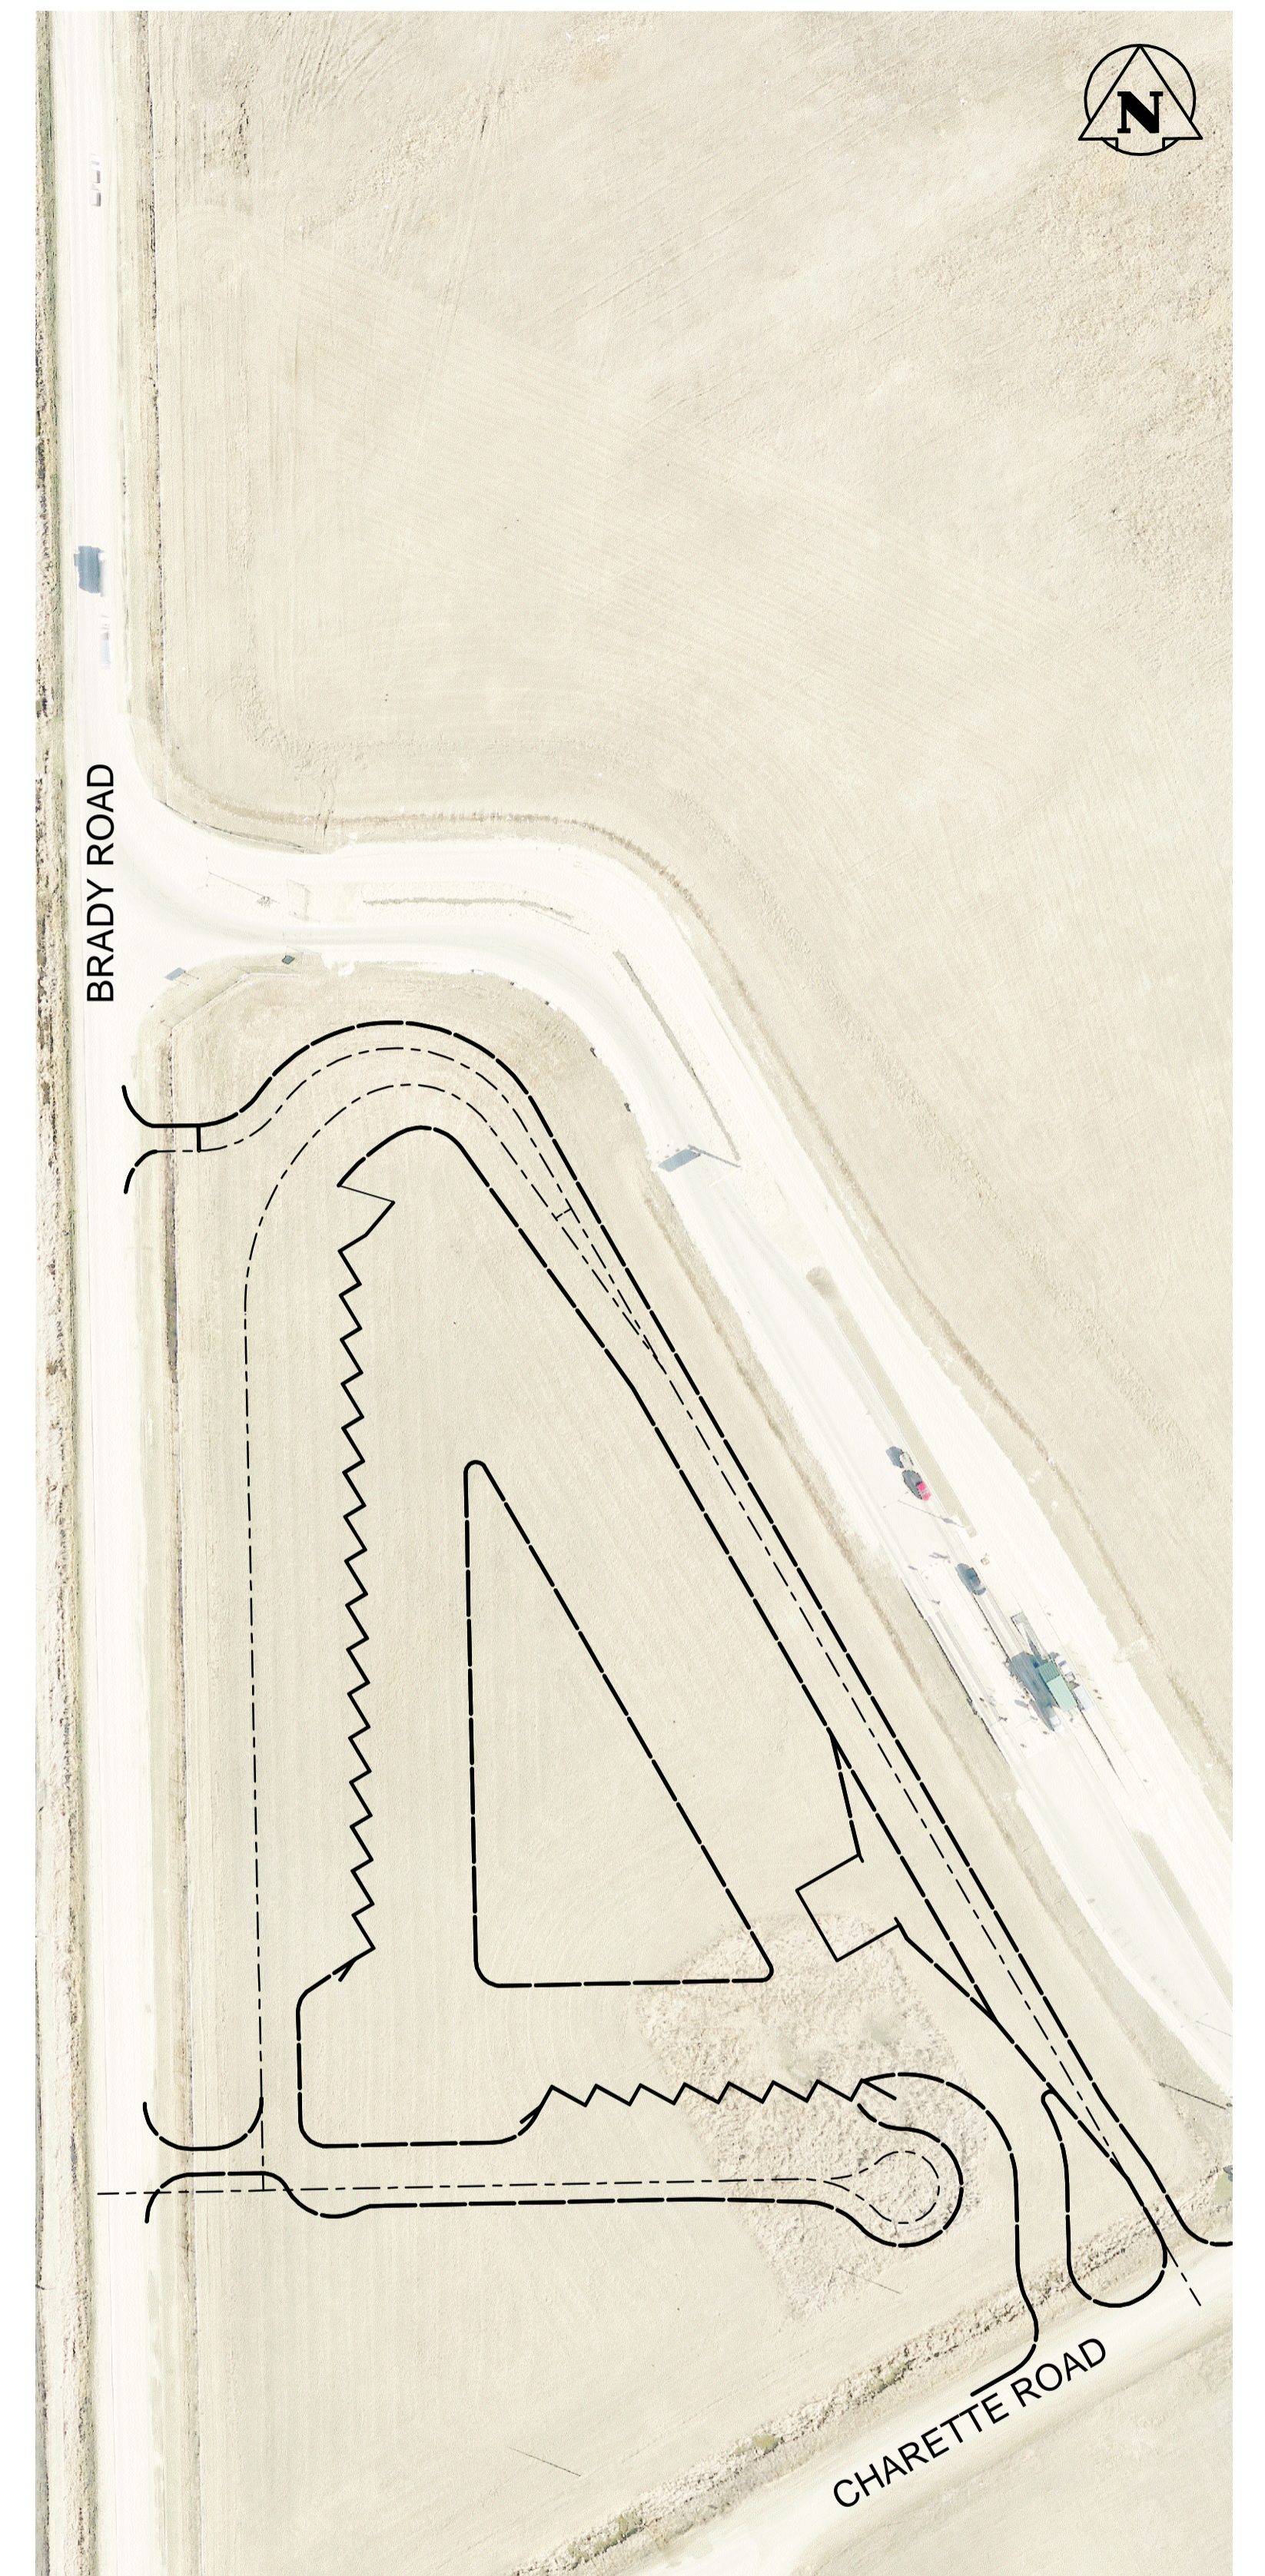

RELEASED FOR CONSTRUCTION BY:

DATE:



CONSULTANT DRAWING No. CITY DRAWING No. SHEET OF SHEET
C0 1-0400A-D0001-001 1 35