


- PARTIAL BASEMENT PLUMBING DEMOLITION NOTES:**
 ALSO SEE MECHANICAL DWG.
 ——— EXISTING TO REMAIN
 - - - - - TO BE DEMOLISHED
 ALL EXISTING DOMESTIC SUPPLY LINES, THAT ARE NOT INDICATED TO BE DEMOLISHED, SHALL BE MODIFIED, RE-PLUMBED & RE-PIPED TO ACCOMMODATE NEW & RELOCATED PLUMBING & BOILER COMPONENTS / EQUIPMENT. ALL EXISTING REDUNDANT SUPPLY BRANCHES LINES & RISERS TO BE REMOVED AND CAPPED AT SOURCE.
- 1 REMOVE & DISCARD HOT & COLD DOMESTIC WATER SUPPLY LINES & SHUT-OFF VALVES AND CAP AT MAIN SUPPLY LINES.
 - 2 REMOVE, DISCARD & REPLACE (3) ABOVE FLOOR 3" PVC DRAIN PIPES, RISERS & FITTINGS FROM MAIN FLOOR AMBULANCE & MUSEUM VEHICLE BAYS TO BASEMENT SEDIMENT TRAP/ HOLDING TANK. REMOVE & DISCARD ALL EXISTING PIPE SUPPORT HANGERS & CONCRETE SHIELD ANCHORS. ALSO SEE MAIN FLOOR PLAN - PLUMBING DEMOLITION DWG.
 - 3 REMOVE & DISCARD ABANDONED 1/2" DOMESTIC COLD WATER COPPER PIPE RISER & BALL VALVE.
 - 4 DISCONNECT, REMOVE & RETAIN EXISTING ELECTRIC HOT WATER TANK FOR REINSTALLATION AS SHOWN.
 - 5 EXISTING 1/2" HOT & COLD DOMESTIC WATER SUPPLY LINES SERVING MAIN FLOOR TO REMAIN.

1 PARTIAL CRAWLSPACE & BASEMENT FLOOR PLAN - PLUMBING DEMOLITION
 M3 M3 SCALE: 1/4"=1'-0"

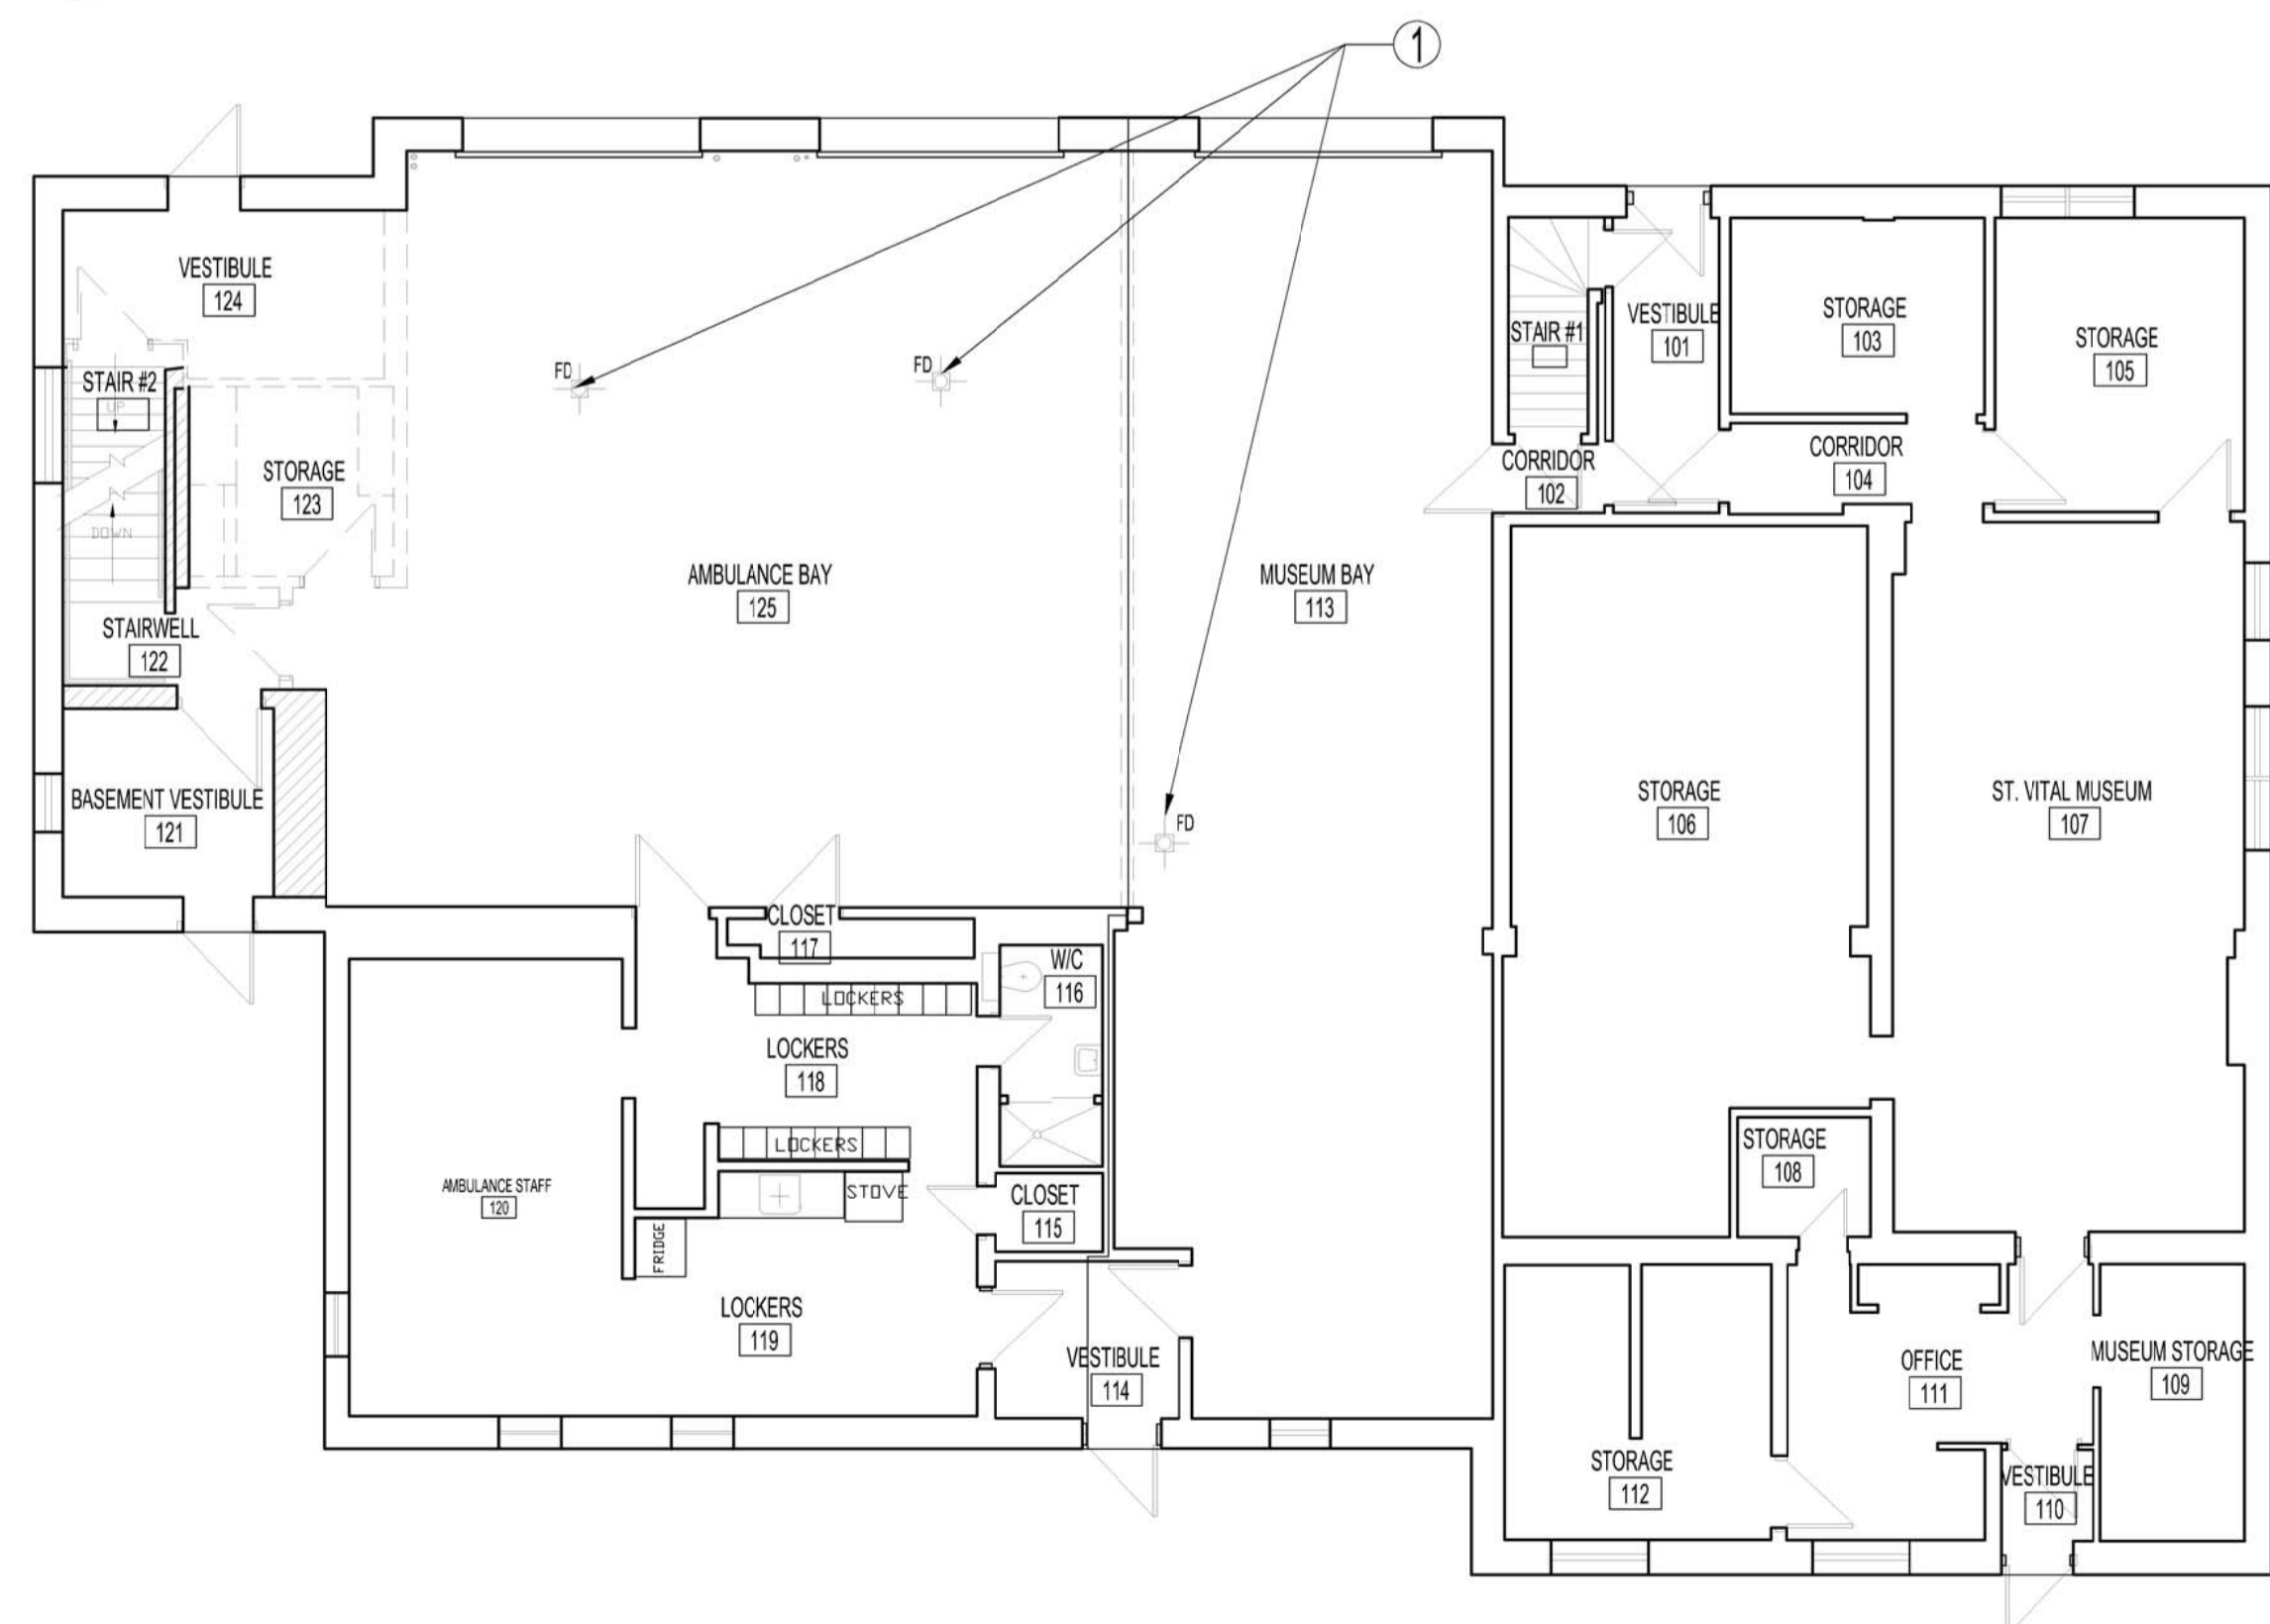

- MAIN FLOOR PLUMBING DEMOLITION NOTES:**
 ALSO SEE PARTIAL CRAWLSPACE & BASEMENT PLUMBING RENOVATION DWG
- 1 REMOVE, DISCARD & REPLACE (2) AMBULANCE BAY & (1) MUSEUM VEHICLE BAY FLOOR DRAINS COMPLETE WITH PIPING, FITTINGS & SUPPORT HANGERS.

2 MAIN FLOOR PLAN - PLUMBING DEMOLITION
 M3 M3 SCALE: 1/8"=1'-0"

PLUMBING SYMBOLS	
SYMBOL	DESCRIPTION
EX	SHUT-OFF VALVE (EXISTING TO REMAIN)
D	SHUT-OFF VALVE (REMOVE & DISCARD)
N	SHUT-OFF VALVE (SUPPLY & INSTALL)
CW	COLD WATER LINE
HW	HOT WATER LINE
STOR	ABOVE FLOOR DRAIN LINE
DHW	DOMESTIC HOT WATER TANK (REMOVE AND RETAIN)
C.B.	FLOOR DRAIN & CATCH BASIN (EXISTING TO REMAIN)
S.T.	ABOVE FLOOR SEDIMENT TRAP / HOLDING TANK (EXISTING TO REMAIN)
C/O	CLEAN-OUT
B.W.V.	IN-LINE AUTOMATIC BACK WATER VALVE & PIT
+	WATER SPIGOT
FD	FLOOR DRAINS
---	NEW WALLS - SEE WALL TYPES
- - - - -	NEW WALLS - 1 HOUR FIRE RATED - SEE A1

PLUMBING EQUIPMENT SCHEDULE		
TAG	TYPE	DESCRIPTION
P-1		FLOOR DRAIN: ZURN FD-2330 HEAVY DUTY ADJUSTABLE COMPLETE WITH FITTINGS AND 3" PVC HUB

NOTES:

ORIGINAL SEALED BY:
 D.A. Paley P. Eng.
 Date: JULY 16, 2014

No.	REVISION/DESCRIPTION	BY	DATE

DRAWN	CHECKED	DESIGNED	APPROVED
JAW/RCP			
DATE: 2014.07.14	USER APPROVAL		

THE CITY OF WINNIPEG
 PLANNING, PROPERTY AND DEVELOPMENT DEPARTMENT
 MUNICIPAL ACCOMMODATIONS DIVISION
 3-65 GARRY STREET, R3C 4K4

PROJECT
 AMBULANCE STATION #3
 STRUCTURAL & OCCUPANCY UPGRADES
 DESIGN OF STRUCTURAL UPGRADES
 598 ST. MARY'S ROAD

SHEET TITLE
 BASEMENT FLOOR PLAN
 PLUMBING
 DEMOLITION

SCALE	PROJECT No:	SHEET No:
AS SHOWN	2013-047	M3

DRAWING SHEET SIZE: A1 (841mm x 594mm) PLOT 1:1