


DONALD STREET

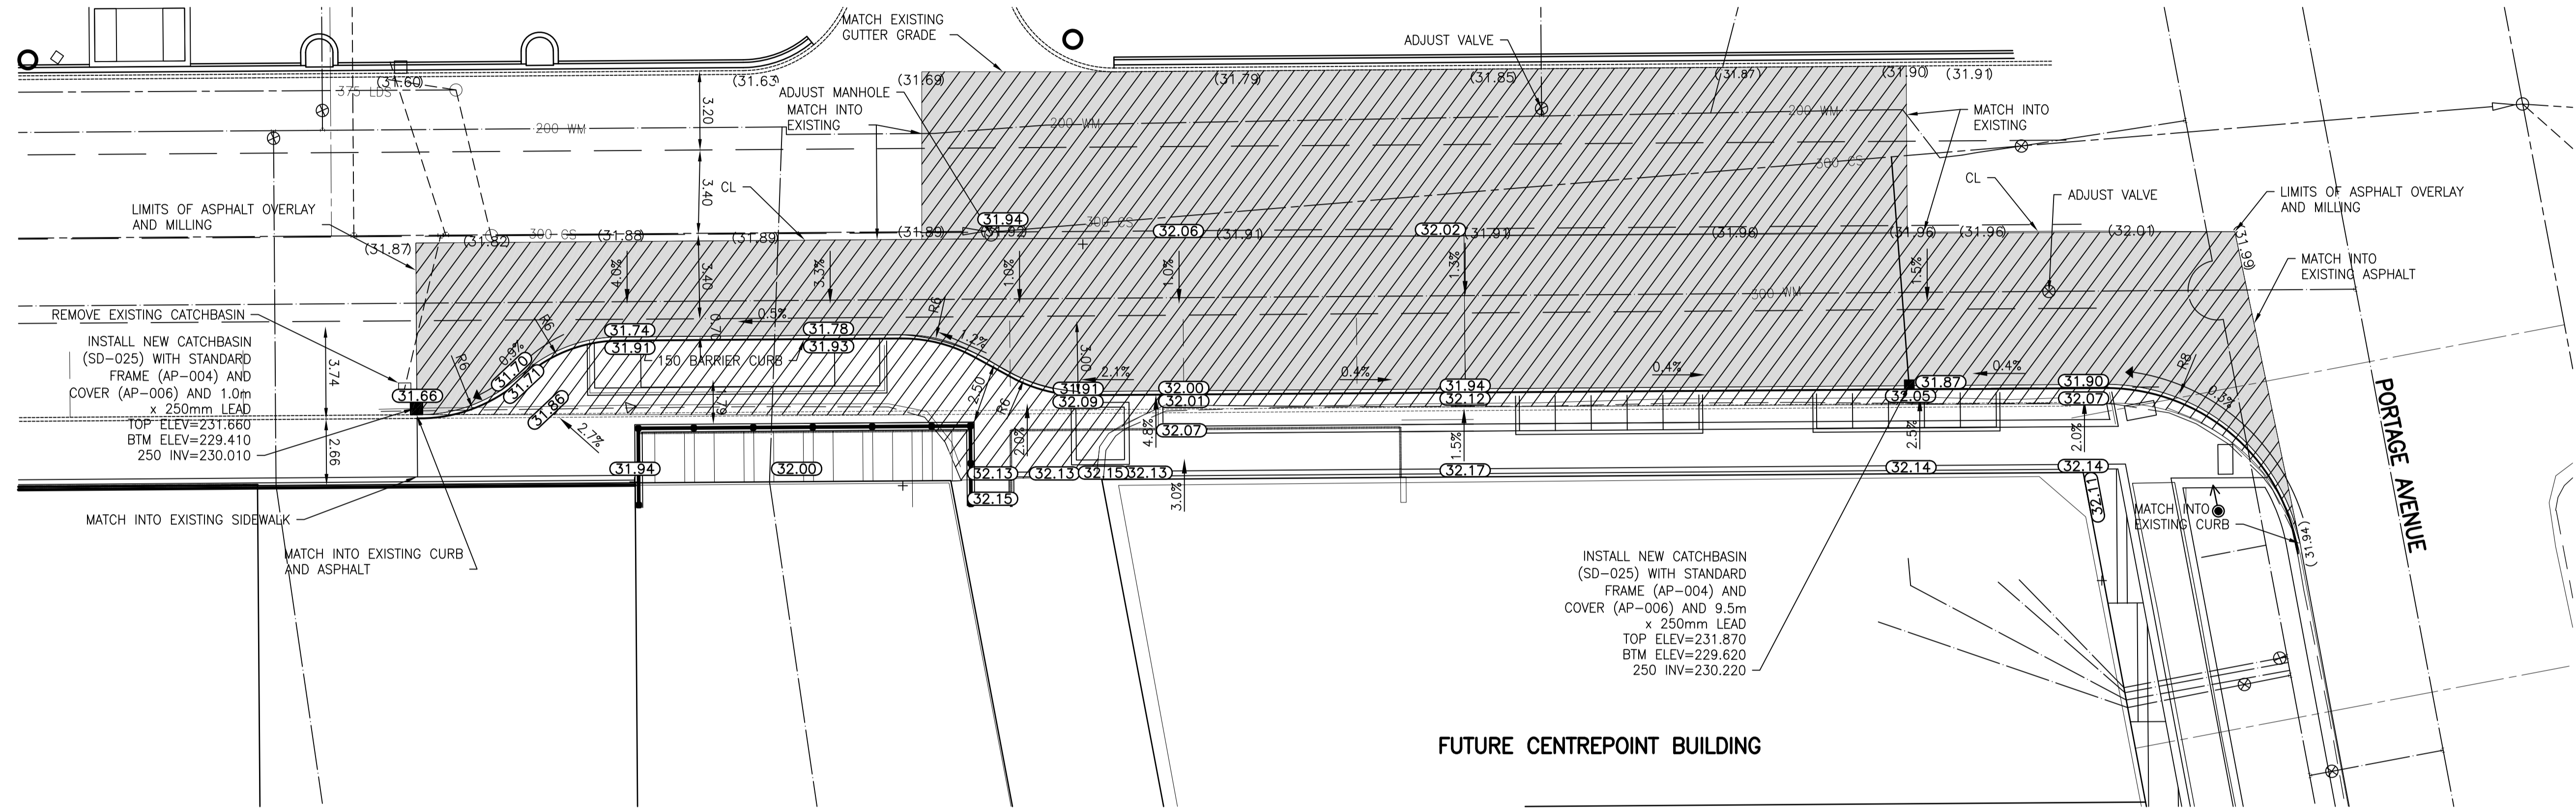

NOTE:
 1. ALL HYDRO, MTS, AND OTHER MANHOLE AND WATERVALVES TO BE ADJUSTED TO DESIGN ELEVATIONS
 2. REFERENCE THE LANDSCAPE DRAWING FOR SIDEWALK AND LANDSCAPE DETAILS
 3. ALL SIGNS, POLES AND PARKING METERS TO BE RELOCATED AS PER LANDSCAPING DRAWINGS
 4. 180 BARRIER CURB EXCEPT WHERE DIRECTED

WARNING

IF POWER EQUIPMENT OR EXPLOSIVES ARE TO BE USED FOR EXCAVATION ON THIS PROJECT THE CONTRACTOR MUST:
 1) NOTIFY THE GAS COMPANY OF THE PROPOSED LOCATION OF EXCAVATION.
 2) TAKE PRECAUTION TO AVOID DAMAGE TO GAS COMPANY INSTALLATIONS.
 SEE PROVINCIAL REGULATION 140/92 FOR DETAILS

METRIC

WHOLE NUMBERS INDICATE MILLIMETRES
 DECIMALIZED NUMBERS INDICATE METRES



150 WM	WATERMAIN	150 WM	HYDRO	150 WM	WATERMAIN	150 WM	WATERMAIN
+	HYDRANT	+	M.T.S.	+	HYDRANT, VALVE	+	HYDRANT, VALVE
⊙	VALVE	⊙	CONCRETE	⊙	LAND DRAINAGE SEWER	⊙	LAND DRAINAGE SEWER
---	LAND DRAINAGE SEWER	---	ASPHALT	---	WASTE WATER SEWER	---	WASTE WATER SEWER
---	WASTE WATER SEWER	---	MILLING	---	⊙ PROFILE	---	⊙ PROFILE
○	MANHOLE	○	PROPERTY LINE	□	NORTH OR WEST GUTTER	□	NORTH OR WEST GUTTER
□	CATCH BASIN	□	SURVEY BAR	○	SOUTH OR EAST GUTTER	○	SOUTH OR EAST GUTTER
▽	CURB INLET	▽	DITCH	◇	NORTH OR WEST DITCH	◇	NORTH OR WEST DITCH
+	JUNCTIONS	+	ELEVATION	○	SOUTH OR EAST DITCH	○	SOUTH OR EAST DITCH
---	CULVERT	---	SIDEWALK RAMP	△	NORTH OR WEST DITCH	△	NORTH OR WEST DITCH
---	GAS	---		▽	SOUTH OR EAST DITCH	▽	SOUTH OR EAST DITCH
---	EXISTING	---	EXISTING	---	EXISTING	---	EXISTING
---	LEGEND-PLAN	---	LEGEND-PLAN	---	LEGEND-PROFILE	---	LEGEND-PROFILE
---	PROPOSED	---	PROPOSED	---	PROPOSED	---	PROPOSED

LOCATION APPROVED UNDERGROUND STRUCTURES
 SUPV. U/G STRUCTURES COMMITTEE DATE
 NOTE:
 LOCATION OF UNDERGROUND STRUCTURES AS SHOWN ARE BASED ON THE BEST INFORMATION AVAILABLE BUT NO GUARANTEE IS GIVEN THAT ALL EXISTING UTILITIES ARE SHOWN OR THAT THE GIVEN LOCATIONS ARE EXACT. CONFIRMATION OF EXISTENCE AND EXACT LOCATION OF ALL SERVICES MUST BE OBTAINED FROM THE INDIVIDUAL UTILITIES BEFORE PROCEEDING WITH CONSTRUCTION.

B.M. ELEV.	NO.	REVISIONS	DATE	BY
	1	ISSUED FOR REVIEW	14.06.13	W.K.B.

Stantec Consulting Ltd.
 905 Waverley Street, Winnipeg, Manitoba
 Tel 204-489-5900 Fax 204-453-9012

DESIGNED BY	P.D.	CHECKED BY	W.K.B.
DRAWN BY	P.D.	APPROVED BY	W.K.B.
HOR. SCALE:	1:150	RELEASED FOR CONSTRUCTION:	
VERTICAL:		DATE	2014.06.05

PRELIMINARY DRAWING
 NOT TO BE USED FOR CONSTRUCTION
 CONSULTANT DRAWING NO. C-102

THE CITY OF WINNIPEG
 PUBLIC WORKS DEPARTMENT
 ENGINEERING DIVISION

DONALD STREET
 PORTAGE AVE - 75m NORTH OF PORTAGE AVE
 PORTAGE NORTH CURB LINE TO 75m NORTH
 CIVIL WORKS GRADING PLAN

SHEET	2	OF	5
CAD FILE DRAWING NUMBER	06400c-101-xxx		
CITY DRAWING NUMBER			

V:\1137\civ\113706400\warning\02_design\sheet_101.dwg 2014 June 06, 8:44 a.m.