


FILE NAME: 14-0107-021_E03A1
 DATE: 2014.10.27
 SHEET TITLE: MEZZANINE POWER & SYSTEMS - DEMOLITION
 PROJECT No: 2013-173
 ADDRESS: 381 SHERBROOK STREET

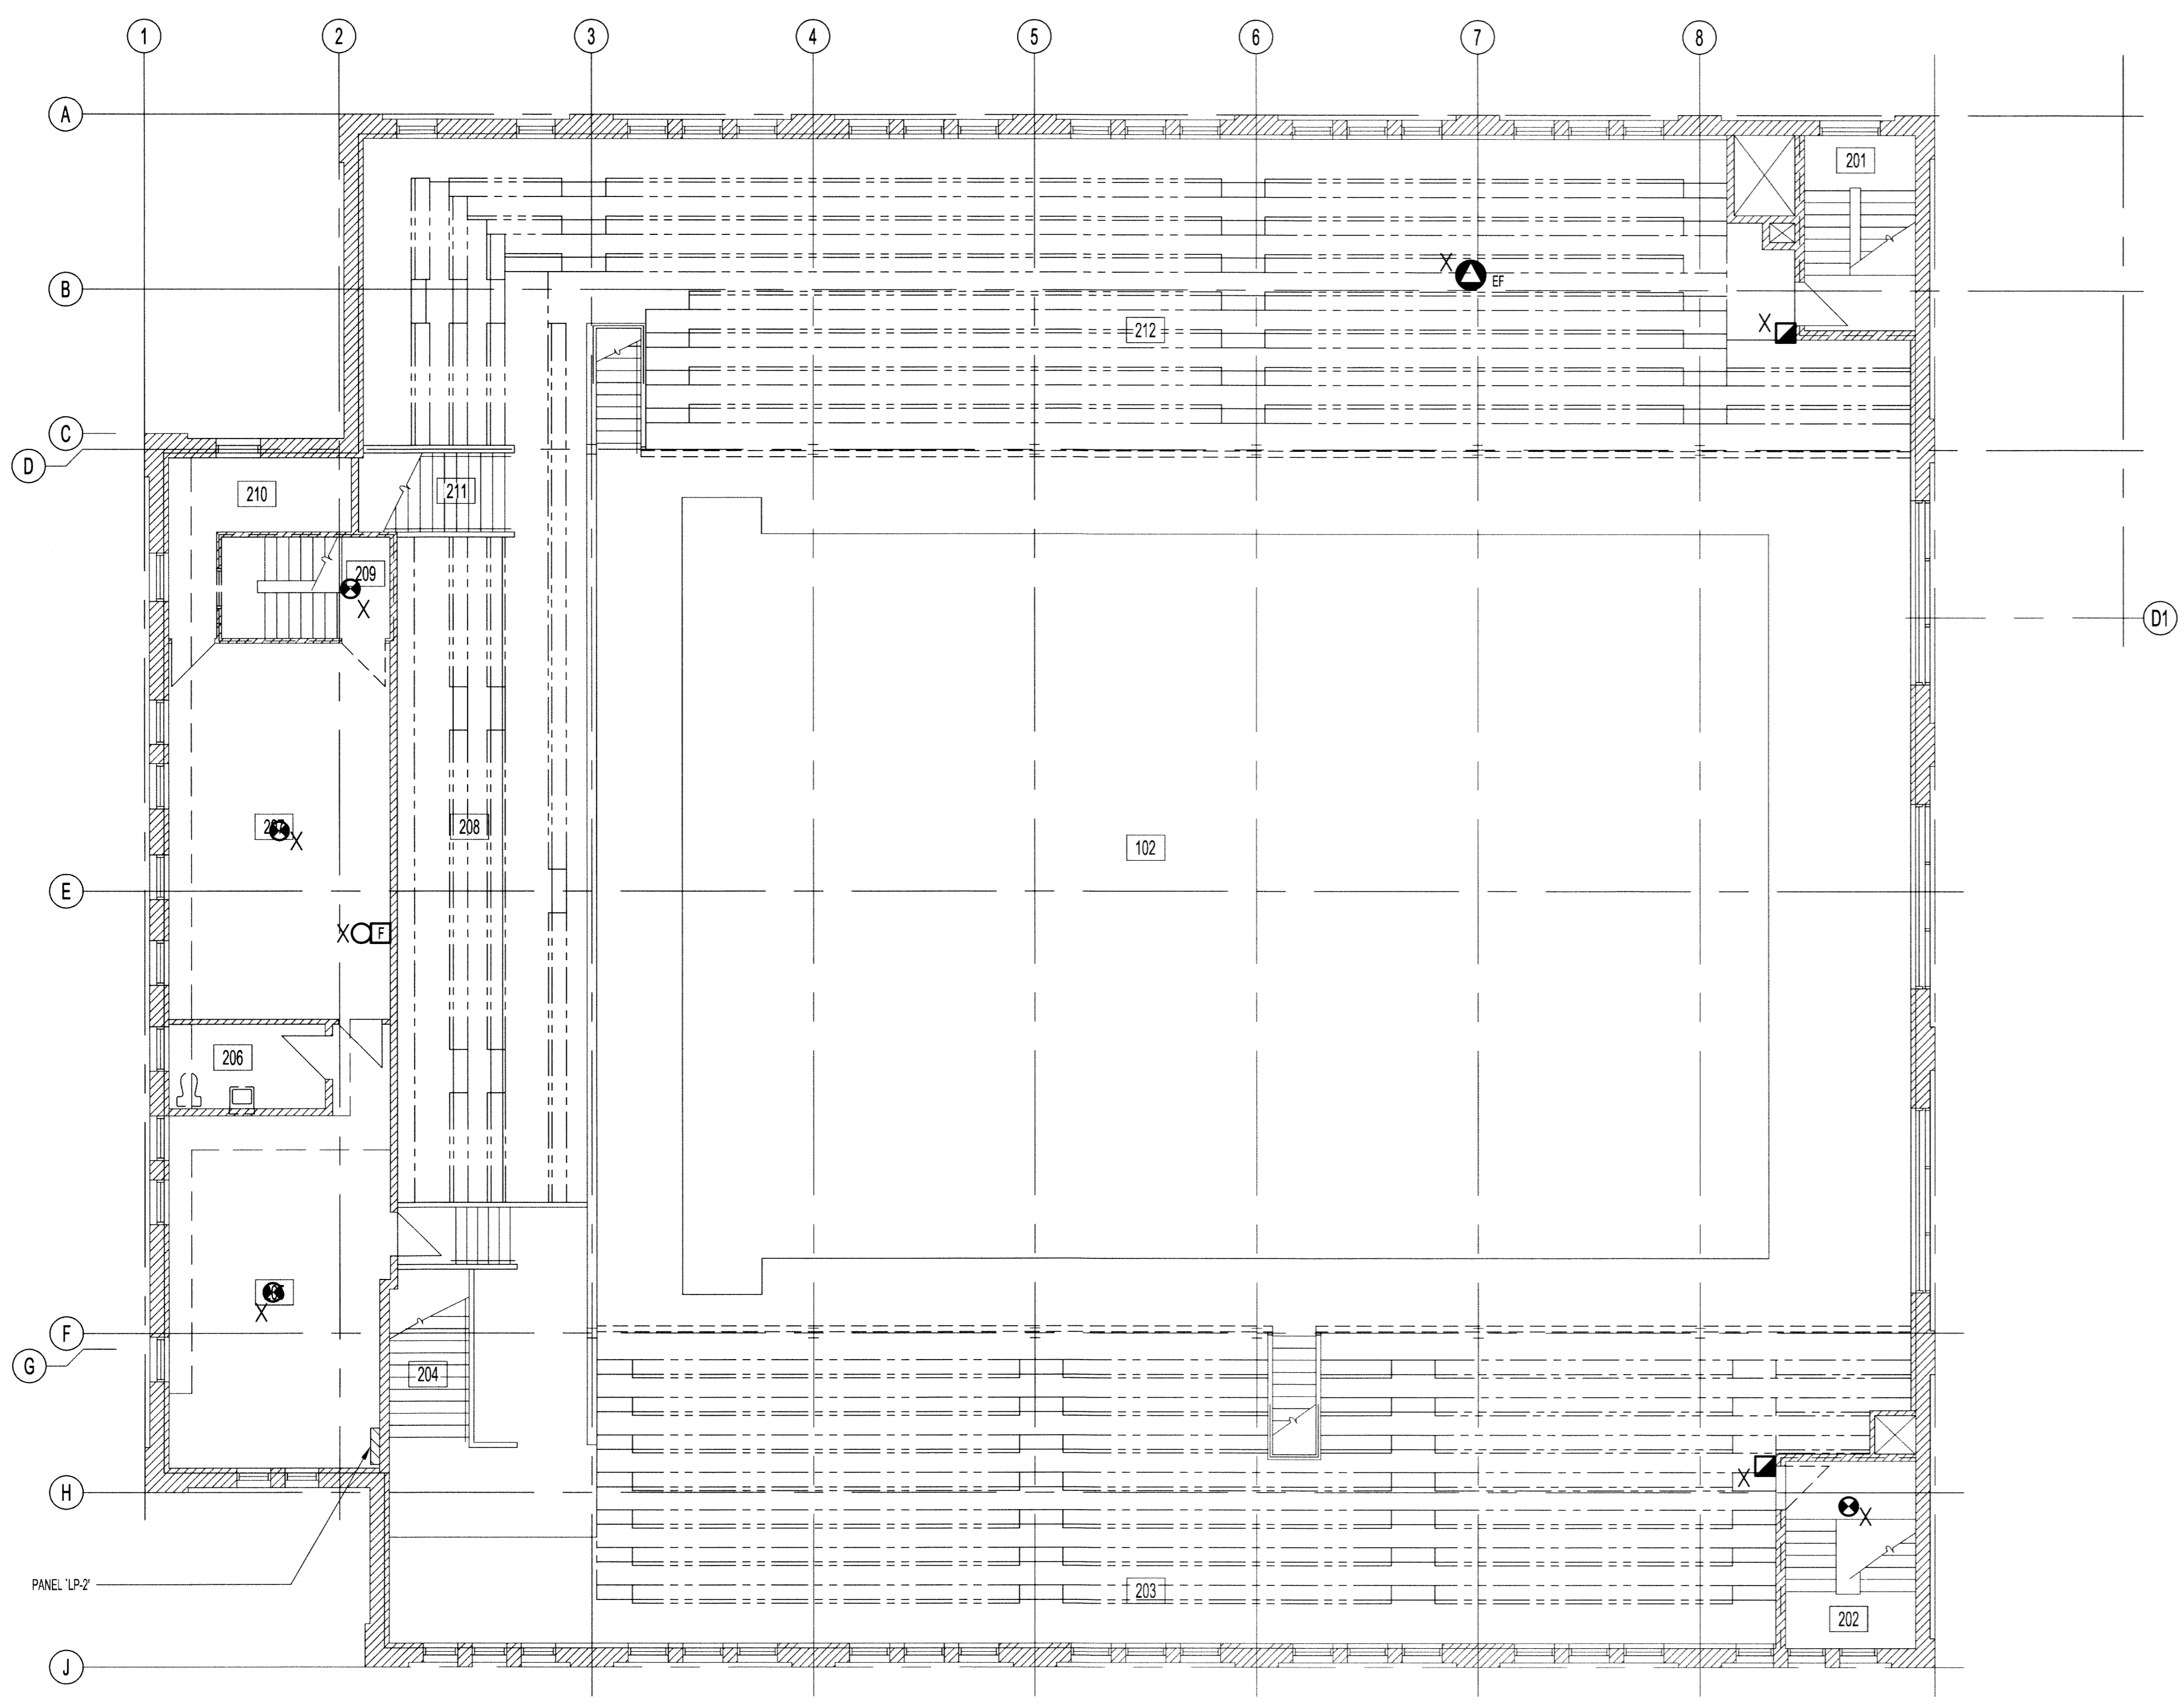

MEZZANINE PLAN - POWER & SYSTEMS DEMOLITION
 SCALE: 1/8"=1'-0"

ELECTRICAL NOTES:
 1. DISCONNECT AND REMOVE THE EXISTING FIRE ALARM SYSTEM INCLUDING CONDUIT AND DEVICES.

NOTES:
 THESE DRAWINGS SHALL NOT BE SCALED.
 THE CONTRACTOR SHALL VISIT THE SITE AND SATISFY ONESELF ALL DIMENSIONS, DATUM, AND DETAILED INFORMATION SHOWN ARE CORRECT.
 THE CONTRACTOR IS TO REVIEW AND COORDINATE ALL ARCHITECTURAL, MECHANICAL, ELECTRICAL AND STRUCTURAL DRAWINGS FOR ADDITIONAL OPENINGS THROUGH FLOORS, WALLS, AND CEILINGS FOR DUCT, PIPE & ELECTRICAL RISERS AND ALL OPENINGS NOT SHOWN ON DRAWINGS.
 ALL OPENINGS THROUGH FIRE ASSEMBLIES ARE TO BE FIRE STOPPED AND SEALED WITH U.L.C. APPROVED FIRE STOPPING TO MAINTAIN THE INTEGRITY OF THE FIRE SEPARATION, AND PROVIDE A SMOKE-TIGHT BARRIER.
 ALL PRODUCTS AND MATERIALS TO BE USED AND INSTALLED SHALL CONFORM WITH MANUFACTURERS SPECIFICATIONS & APPLICABLE CODES.
 THE CONTRACTOR SHALL BE RESPONSIBLE TO PATCH AND MAKE GOOD ALL EXISTING CONSTRUCTION AFFECTED BY THE REMOVAL OF ALL ITEMS FORMING THE PART OF THE RENOVATION WORK.
 WHERE NEW FLOORING AND BASE IS TO BE INSTALLED IN EXISTING AREAS (REFER TO FLOOR PLAN AND ROOM SCHEDULE) THE EXISTING FLOORING SURFACE AND BASE MUST BE REMOVED, UNLESS OTHERWISE NOTED. ALL FLOOR SURFACES SHALL BE PREPARED IN ACCORDANCE TO MANUFACTURERS RECOMMENDATIONS FOR INSTALLATION OF NEW FLOOR.
 WHERE PAINTING OF EXISTING WALLS IS INDICATED ON THE ROOM SCHEDULE, THESE WALLS MUST BE CLEANED OF ANY EXISTING WALL COVERING, PATCHED & PREPARED TO ACCEPT NEW MATERIAL, UNLESS OTHERWISE NOTED.

RENOVATION LEGEND:
 X EXISTING ELECTRICAL EQUIPMENT TO BE REMOVED AND TURNED OVER TO THE OWNER OR AS DIRECTED BY THE ENGINEER. REMOVE, BLANK OFF, EXTEND OR RELOCATE ALL ASSOCIATED WIRING AND MAKE SAFE.
 * EXISTING ELECTRICAL EQUIPMENT TO BE REMOVED AND REINSTALLED OR RELOCATED AS SHOWN UPON COMPLETION OF NEW CEILING OR WALL CONSTRUCTION. RE-WIRE OR EXTEND WIRING AS REQUIRED.
 ✓ EXISTING ELECTRICAL EQUIPMENT TO REMAIN IN ITS PRESENT LOCATION. REWIRE OR EXTEND WIRING AS REQUIRED.

LEGEND:

 PANELBOARD
 MOTOR LOAD
 FIRE ALARM CONTROL PANEL (FACP)
 FIRE ALARM PULL STATION
 FIRE ALARM BELL
 SMOKE DETECTOR
 HEAT DETECTOR

GENERAL DEMOLITION NOTES:
 1. REMOVE ALL ABANDONED ELECTRICAL EQUIPMENT INCLUDING BUT NOT LIMITED TO SWITCHES, CONDUITS AND JUNCTION BOXES.
 2. ALL EXISTING EQUIPMENT NOT SHOWN ON THE PLAN SHALL REMAIN. IF FURTHER CLARIFICATION IS REQUIRED, THE CONTRACTOR SHALL OBTAIN WRITTEN DIRECTION FROM THE CONTRACT ADMINISTRATION.

No.	REVISION/DESCRIPTION	BY	DATE
0	ISSUED FOR CONSTRUCTION		15.02.17



DRAWN	GON	CHECKED	DESIGNED	CLS	APPROVED
DATE	2014.10.27	USER	APPROVAL		

THE CITY OF WINNIPEG
 PLANNING, PROPERTY AND DEVELOPMENT DEPARTMENT
 MUNICIPAL ACCOMMODATIONS DIVISION
 3-65 GARRY STREET, R3C 4K4

PROJECT
SHERBROOK POOL
 REFURBISHMENT OF SHERBROOK POOL

381 SHERBROOK STREET
 SHEET TITLE

ELECTRICAL
 MEZZANINE PLAN
 POWER & SYSTEMS - DEMOLITION

SCALE	PROJECT No:	SHEET No:
AS SHOWN	2013-173	E03

