


TRANSPORT STORAGE
 SHOP FACILITIES
 2185-707
 OVERHAUL & REPAIR SHOP FLOOR PLAN - POWER
 DRAWN BY: [Signature]
 CHECKED BY: [Signature]
 APPROVED BY: [Signature]


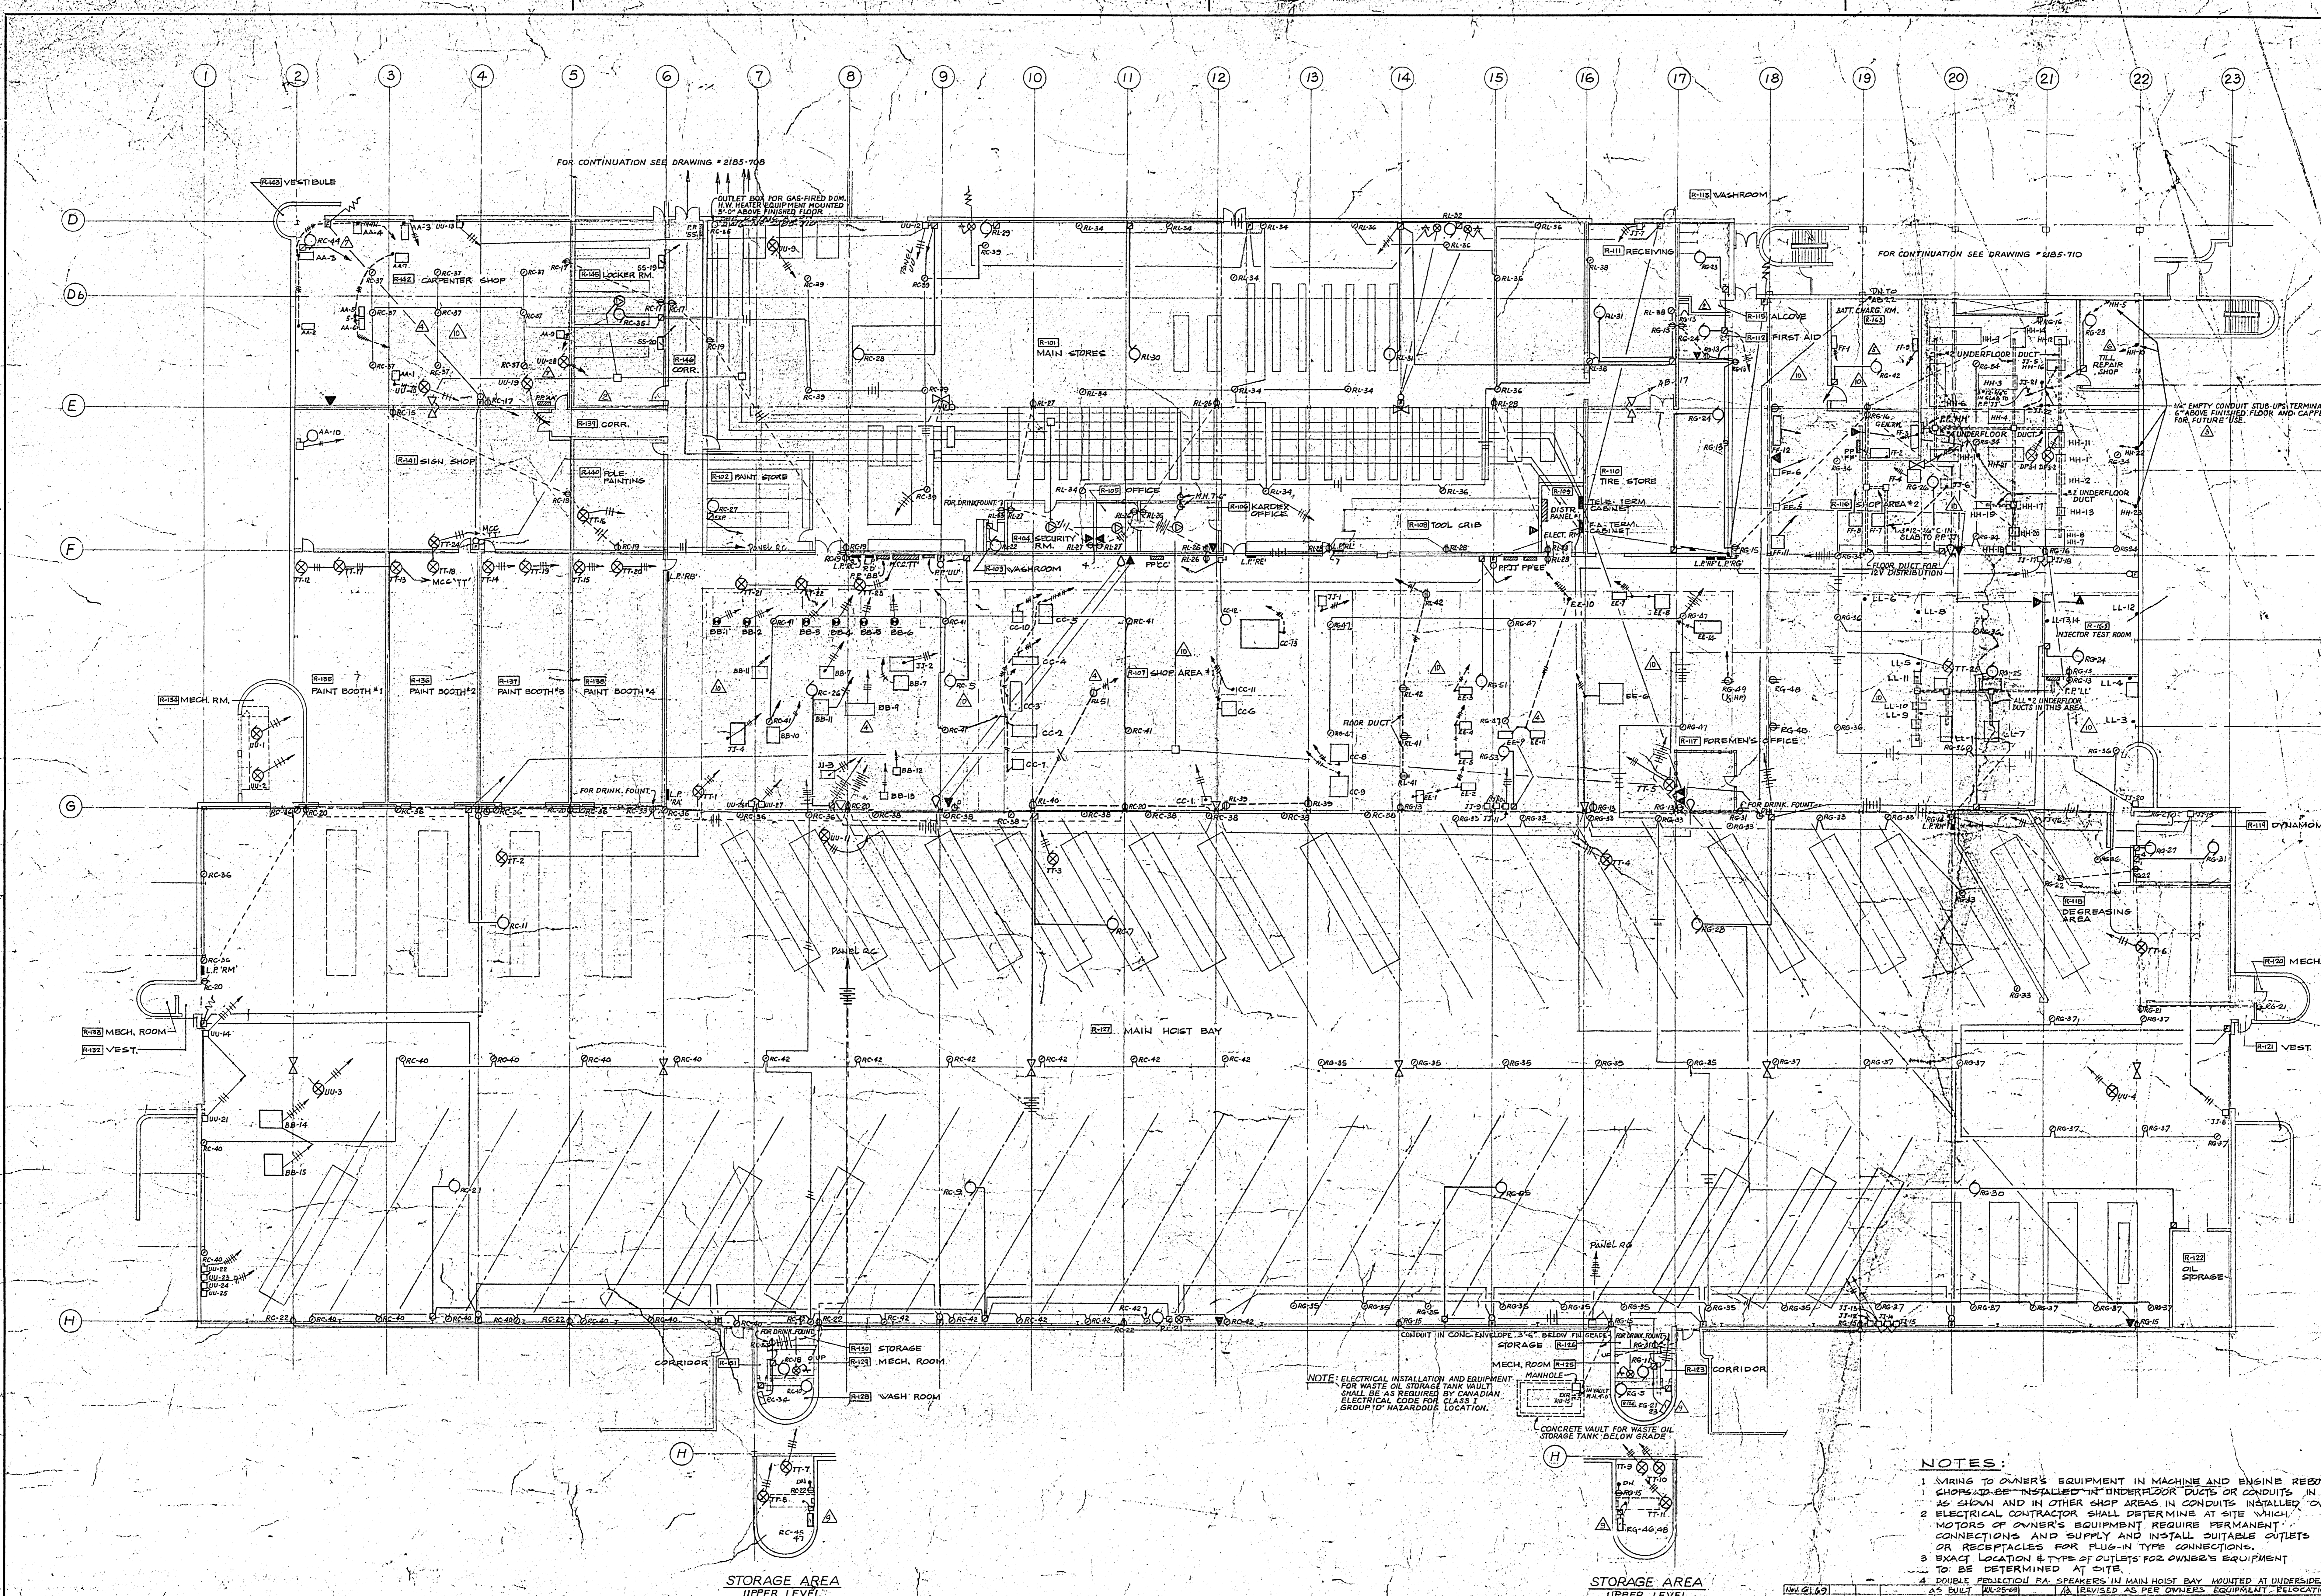


OVERHAUL AND REPAIR SHOP FLOOR PLAN SCALE 1/8"=1'-0"

NOTE: ELECTRICAL INSTALLATION AND EQUIPMENT FOR WASTE OIL STORAGE TANK WALLY SHALL BE AS REQUIRED BY CANADIAN ELECTRICAL CODE FOR CLASS 2 GROUP 1 HAZARDOUS LOCATION.

- NOTES:**
1. WIRING TO OWNER'S EQUIPMENT IN MACHINE AND ENGINE REBUILD SHOPS TO BE INSTALLED IN UNDERFLOOR DUCTS OR CONDUITS IN SLAB AS SHOWN AND IN OTHER SHOP AREAS IN CONDUITS INSTALLED OVERHEAD.
 2. ELECTRICAL CONTRACTOR SHALL DETERMINE AT SITE WHICH MOTORS OF OWNER'S EQUIPMENT REQUIRE PERMANENT CONNECTIONS AND SUPPLY AND INSTALL SUITABLE OUTLETS OR RECEPTACLES FOR PLUG-IN TYPE CONNECTIONS.
 3. EXACT LOCATION & TYPE OF OUTLETS FOR OWNER'S EQUIPMENT TO BE DETERMINED AT SITE.
 4. DOUBLE PROTECTION PA. SPEAKERS IN MAIN HOIST BAY MOUNTED AT UNDERSIDE OF JOISTS.

NO.	DATE	ISSUE NO.	REV.	DESCRIPTION	DRAWN BY
1	1967	1	1	ISSUED FOR CONSTRUCTION	[Signature]
2	1967	2	1	FOR TENDER	[Signature]
3	1967	3	1	GENERAL REVISIONS	[Signature]
4	1967	4	1	ISSUED FOR CONSTRUCTION	[Signature]
5	1967	5	1	FOR TENDER	[Signature]
6	1967	6	1	GENERAL REVISIONS	[Signature]
7	1967	7	1	ISSUED FOR CONSTRUCTION	[Signature]
8	1967	8	1	FOR TENDER	[Signature]
9	1967	9	1	GENERAL REVISIONS	[Signature]
10	1967	10	1	ISSUED FOR CONSTRUCTION	[Signature]

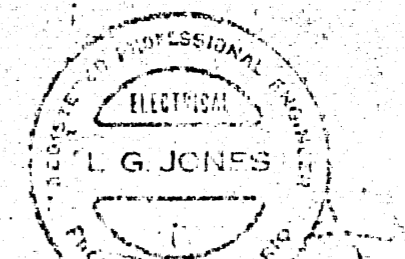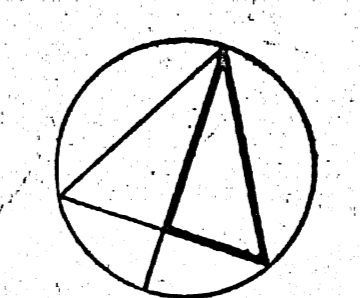

ISSUE OR REVISION
METROPOLITAN CORPORATION OF GREATER WINNIPEG
 STREETS AND TRANSIT DIVISION
TRANSIT STORAGE AND SHOP FACILITIES
OVERHAUL & REPAIR SHOP FLOOR PLAN - POWER
 CONSULTING PROFESSIONAL ENGINEERS
A. D. MARGISON AND ASSOCIATES LIMITED
 515 KING STREET, DON MILLS, ONTARIO
 ARCHITECTS
William Ross & Blackburn
 50 BROAD STREET, WINNIPEG, MANITOBA
 DATE: 1/17/67
 DRAWN BY: L.G.J.
 CHECKED BY: [Signature]
 APPROVED BY: [Signature]
 2185-707
 ELECTRICAL