 
 

 
 


 
 
 







LEGEND

-  3 LAMP FLUORESCENT LIGHT FIXTURE SURFACE OR PENDANT MOUNTED
-  2 LAMP FLUORESCENT LIGHT FIXTURE T-BAR RECESSED MOUNTED
-  600mm (24") WALL MOUNTED FLUORESCENT LIGHT FIXTURE
-  WALL PACK LIGHT FIXTURE
-  CEILING MOUNTED POT LIGHT
-  PHOTOCELL
-  COMBINATION EXIT SIGN C/W EMERGENCY LTG. LAMPS AND BATTERY UNIT
-  EXIT SIGN
-  REMOTE MTD. DUAL EMERGENCY LAMPS
-  SPST WALL SWITCH
-  3 WAY WALL SWITCH
-  OCCUPANCY SENSOR WALL SWITCH
-  VACANCY SENSOR WALL SWITCH
-  N.L. NIGHT LIGHT




LIGHTING FIXTURE SCHEDULE			
TYPE	DESCRIPTION	MANUFACTURER	LAMP
A	OUTDOOR POLE MOUNTED ROADWAY LED, 347 VOLT LUMINAIRE	STREETWORKS NVN-AE-03-E- 9-T3-10K-AP	LED
B	VAPOUR TIGHT, CORROSION RESISTANT 3 LAMP, FLUORESCENT	COOPER LIGHTING CAT. No. VT3-332DR-UNV-EB81-WL-SSL OR APPROVED EQUAL	28W T8 (46")
C	RT5SX - 28W, 2-LAMP, FLUORESCENT FIXTURE, ENERGY EFFICIENT, RUGGED, STEEL REFLECTOR WITH EMBOSSED FACETS. HOUSING FORMED FROM COLD-ROLLED STEEL, RECESSED, TWO-PIECE REFRACTIVE SYSTEM, C/W HIGHLY EFFICIENT PROGRAM-START ELECTRONIC BALLAST, CLASS P, THERMALLY PROTECTED.	LITHONIA LIGHTING CAT. No. 2RT5SX-28T5-MVOLT-GEB95-LPM835P OR APPROVED EQUAL	28W T5 (46")
D	2 - 14 inch T5 FLUORESCENT LAMPS IN 600X600mm RECESSED FLUORESCENT FIXTURE SUITABLE FOR INSTALLATION IN STANDARD LAY-IN CEILING TILE CONSTRUCTION	LITHONIA LIGHTING CAT. No. 2RT5S-14T5-MVOLT-GEB115-LP835 OR APPROVED EQUAL	14W T5 (22")
F	COOPER METALUX VAPOUR TITE	COOPER LIGHTING VT3-232DR-UNV-EB81-WL-SSL	T8
G	LITHONIA LIGHTING LED RECESSED DOWNLIGHTING 4" BAFFLE LED MODULE, MATTE WHITE	4BEMW LED 30K 120V L3LED T24	10.3W 570L
H	21W LED OUTDOOR LED FLOOD SERIES, 120V LIGHTING FIXTURE, DIE CAST ALUMINUM CONSTRUCTION, POWDER COAT BRONZE FINISH, WALL MOUNT ABOVE DOOR, COMPLETE WITH PHOTOCELL CONTROL.	COOPER LIGHTING ALL PRO CAT. No. F-S-S1530L-PC-ES OR APPROVED EQUAL	21W LED
K	LED CANOPY LIGHT, 20 LEADS, 4000K, TYPE V C/W PIR MOTION / AMBIENT	LITHONIA LIGHTING DSXC LED 20C 700 40K T5R PIR DWHXD	
L	WALL MOUNT 600mm LONG #12 PATTERN ACRYLIC LENS C/W 2 14W T5 FLUORESCENT LAMPS	LITHONIA LIGHTING WC-2-14T5-A12-120-GEB10IS OR APPROVED EQUAL	2 - T5 14 W FLUOR.
EMERG. LIGHT	EMERGENCY LIGHT FIXTURE WITH 2 LED HEADS, WHITE ENCLOSURE, WITH 120V INPUT LINE CORD.	COOPER CAT. No. RCS-1-4-2-LED-2 OR APPROVED EQUAL	

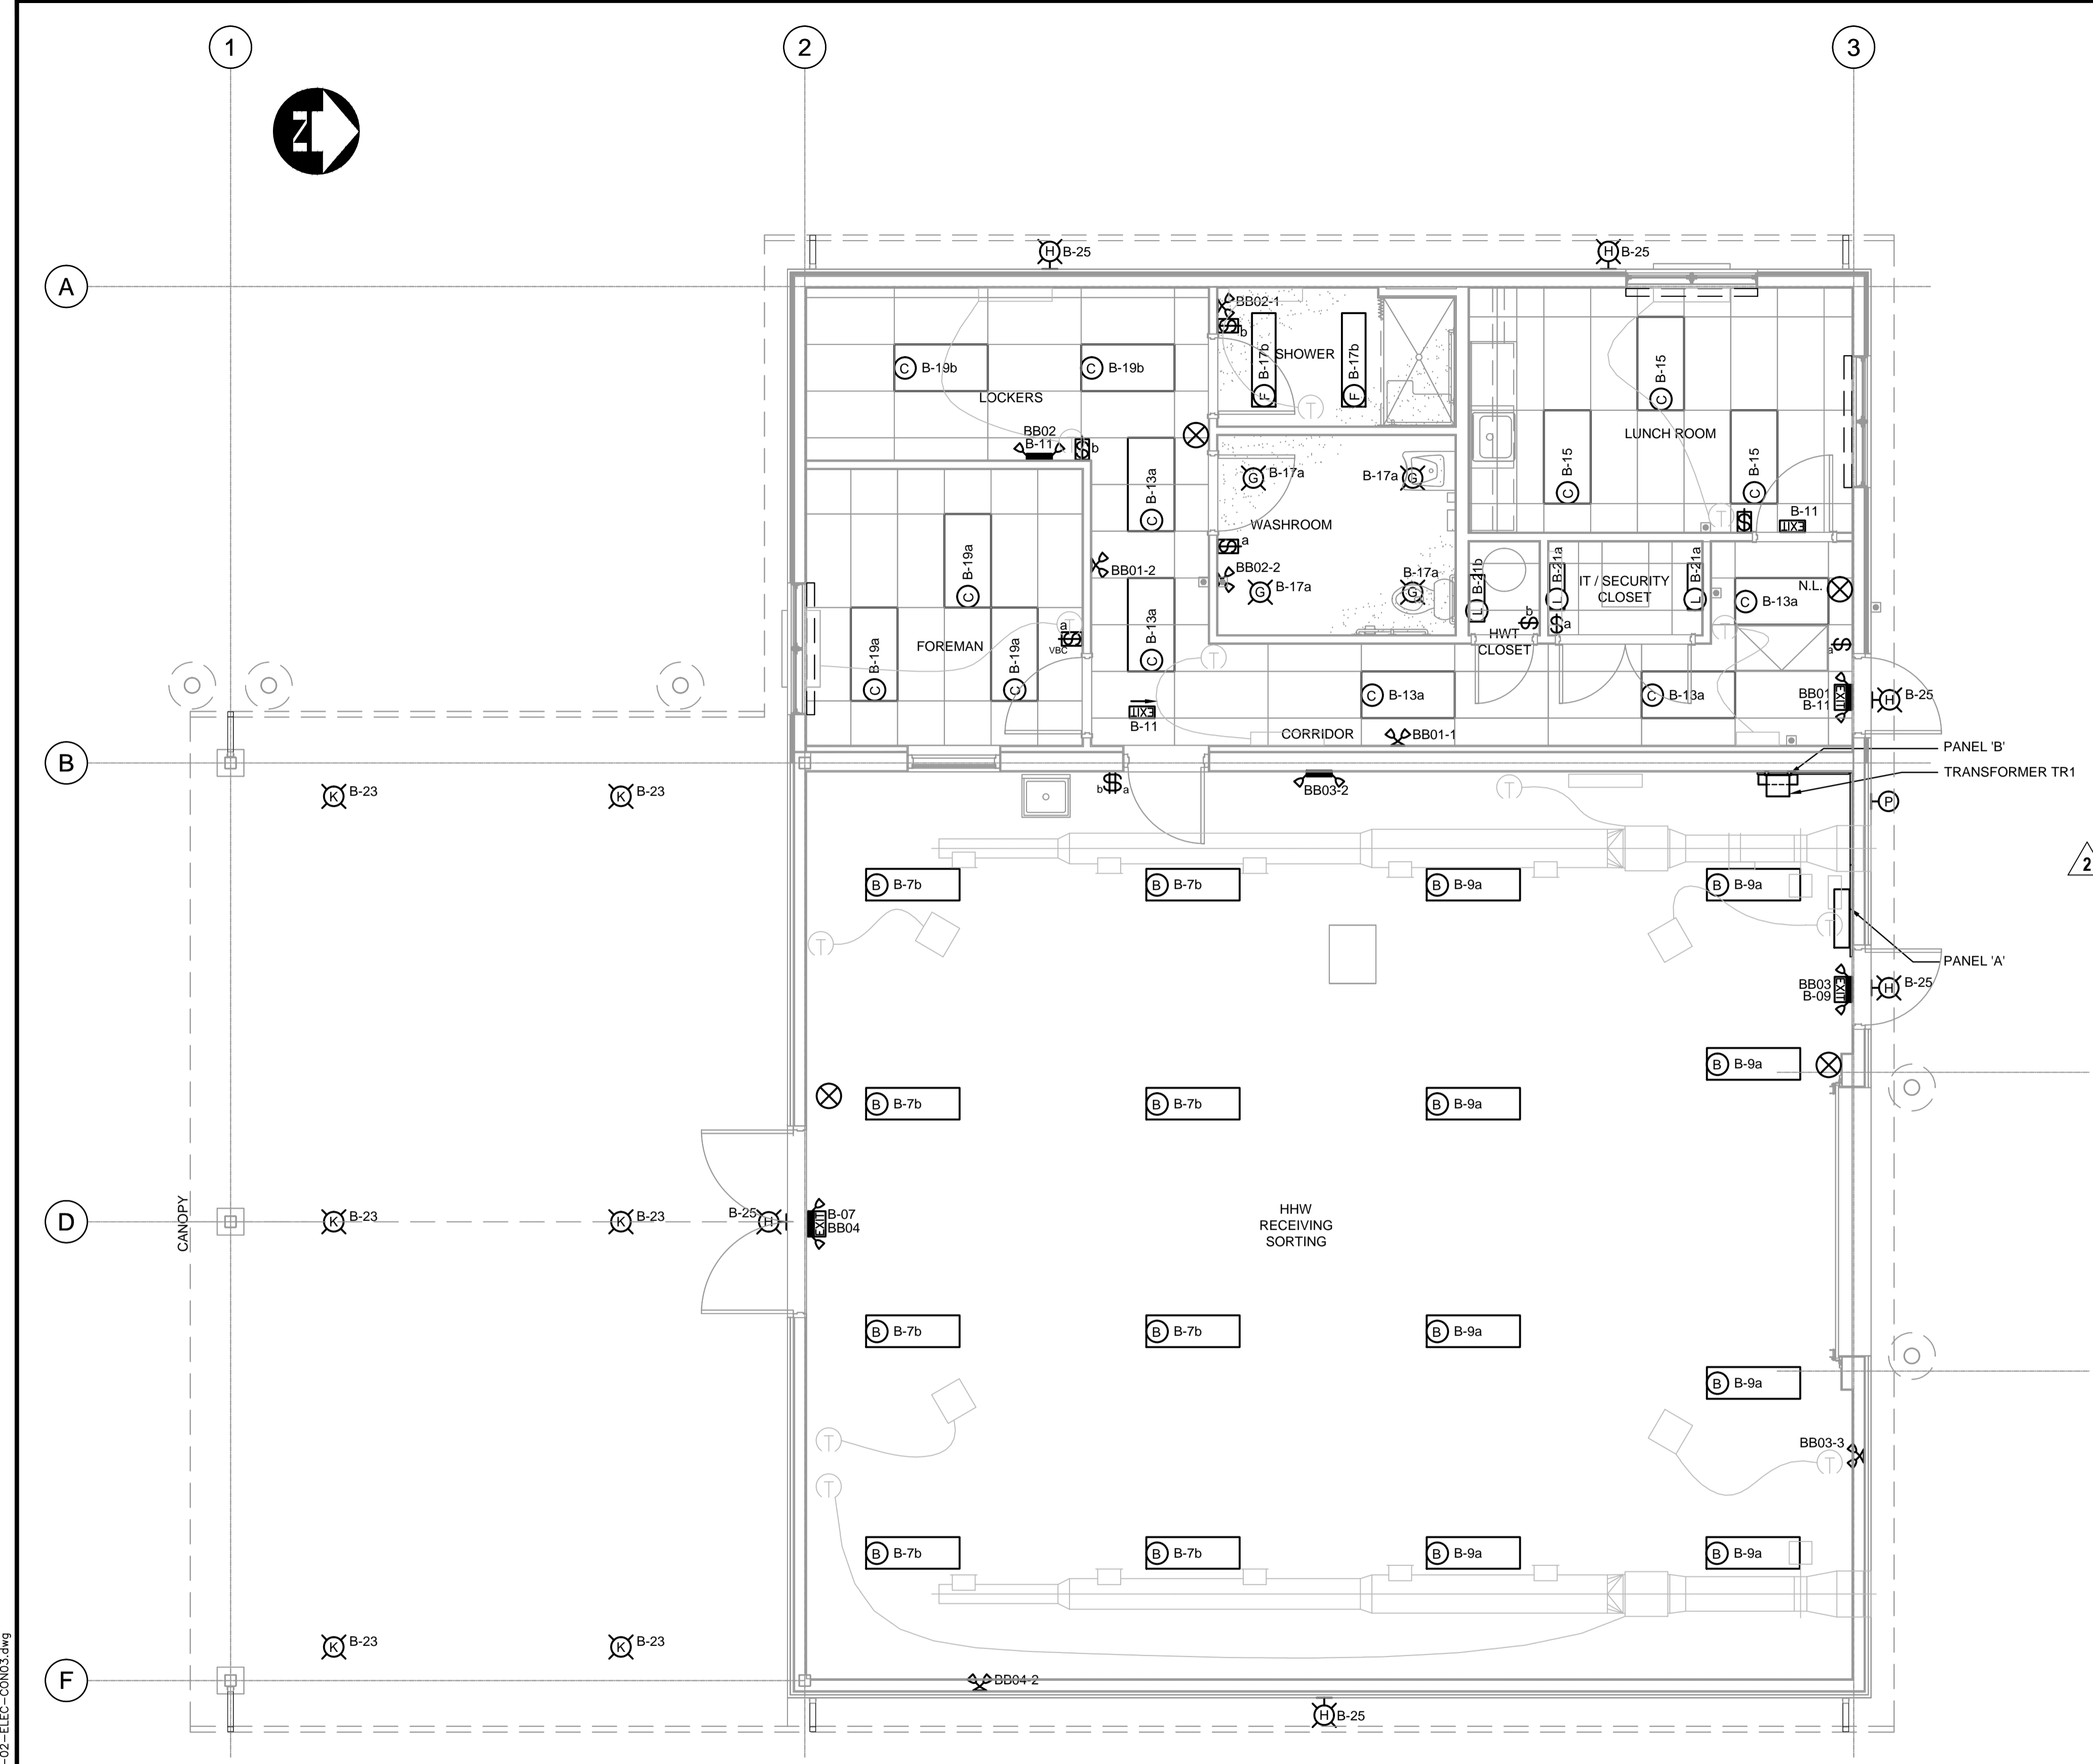C:\projects\win\working_directory\active\4046\024576A\138224-02-ELEC-COING.dwg

HHW EWASTE BUILDING - LIGHTING
1:50



B.M. ELEV.	DESIGNED BY	BLM
	DRAWN BY	SCK
	CHECKED BY	BLM
	APPROVED BY	ARR
	HOR. SCALE	AS NOTED
	VERTICAL	VERTICAL
ISSUED FOR ADDENDUM #1	16/03/14	ARR
1 ISSUED FOR TENDER	16/03/04	ARR
NO. REVISIONS	DATE	BY

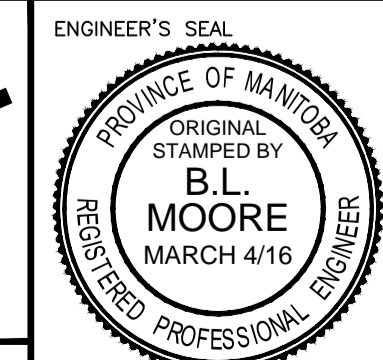

THE CITY OF WINNIPEG PUBLIC WORKS DEPARTMENT

4R WINNIPEG DEPOT
PACIFIC AVENUE

HHW EWASTE BUILDING LIGHTING PLAN

CITY DRAWING NUMBER: 1-0851A-E0003-001
SHEET 35 OF 43
CONSULTANT DRAWING NUMBER: E-3

CONSULTANT PROJECT NUMBER: 13-8224

METRIC
WHOLE NUMBERS INDICATE MILLIMETRES
DECIMALIZED NUMBERS INDICATE METRES