



# THE CITY OF WINNIPEG

## PUBLIC WORKS DEPARTMENT


### ENGINEERING DIVISION

# 2015 LOCAL STREET AND ALLEY RENEWAL PROGRAM

## CLARENCE AV, SWAN LAKE BAY AND

## VARIOUS OTHER LOCATIONS

### BID OPPORTUNITY No. 18-2015

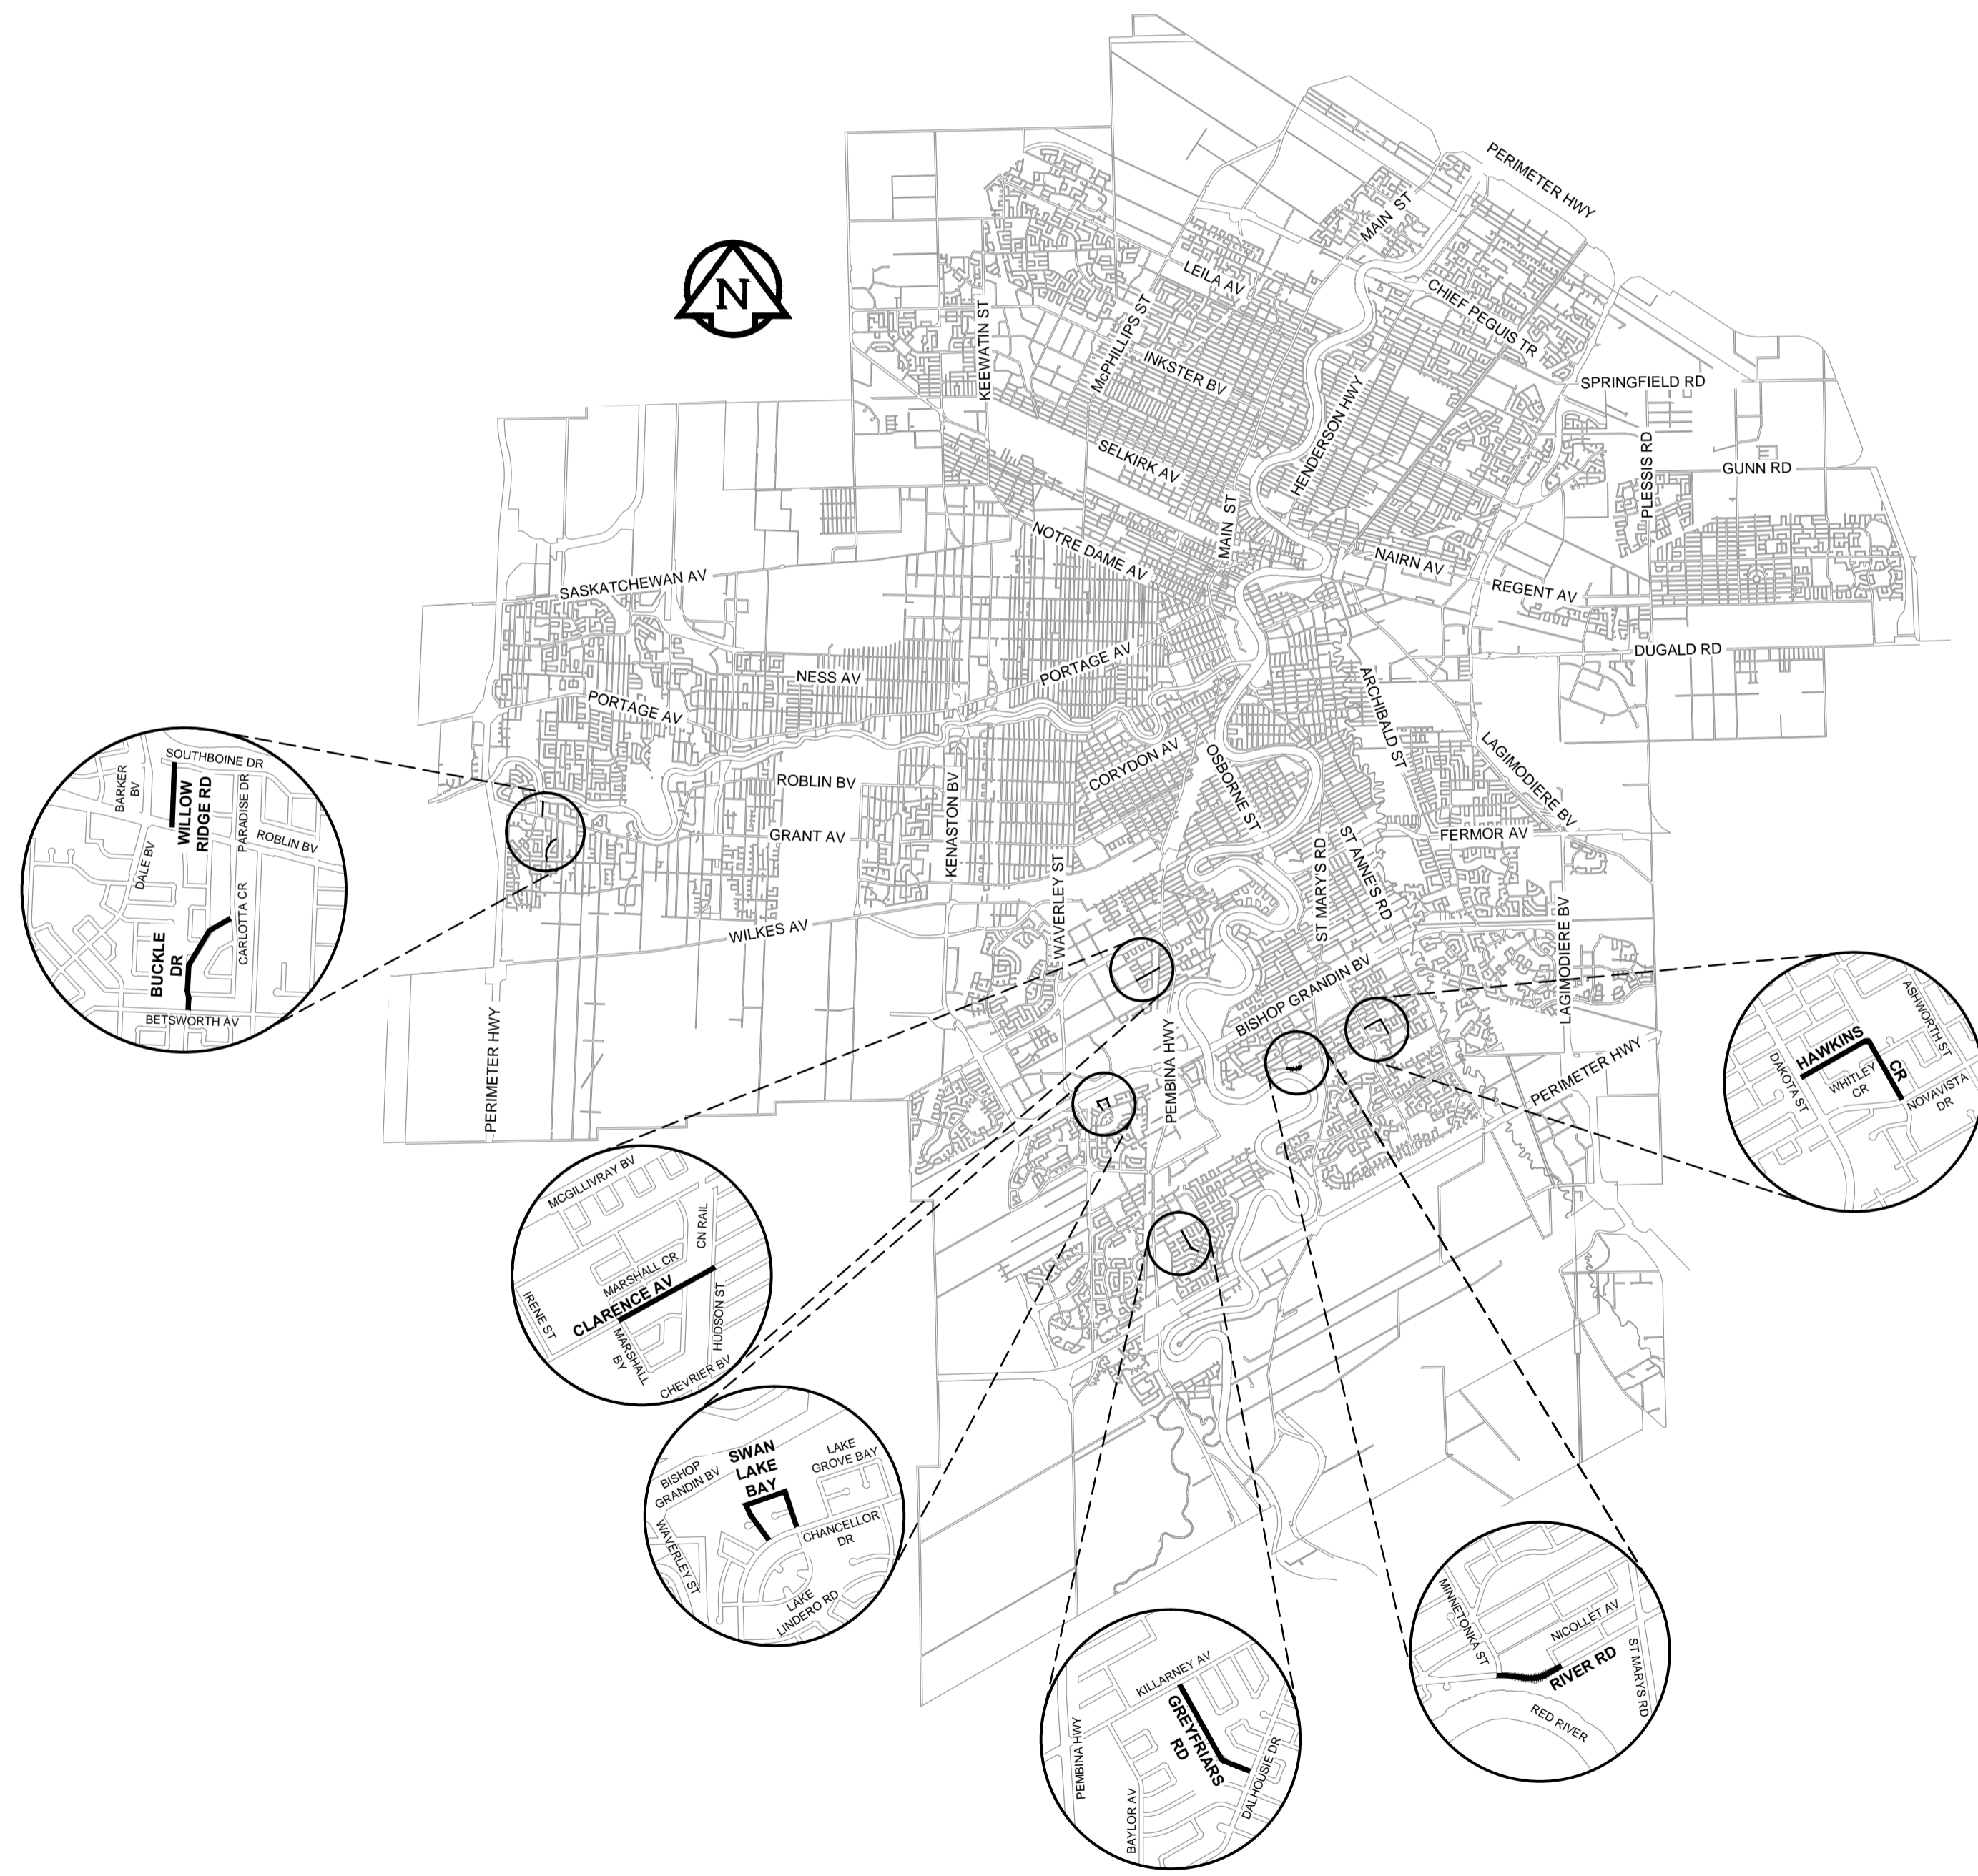

**LOCATION PLAN**

SCALE: 1:100,000  
0 2500 5000m

RELEASED FOR CONSTRUCTION BY:

STREETS PROJECT ENGINEER

DATE

**DRAWING LIST**

DRAWING NUMBER	DESCRIPTION
0	COVER SHEET AND LOCATION PLAN

**WILLOW RIDGE ROAD - ROBLIN BV TO SOUTHBOINE DR REHABILITATION**

HORIZONTAL AND VERTICAL ALIGNMENT	
1	STA 0+080 TO STA 0+210
2	STA 0+210 TO STA 0+320
3	STA 0+320 TO STA 0+420

**BUCKLE DRIVE - BETSWORTH AV TO CARLOTTA CR REHABILITATION**

HORIZONTAL AND VERTICAL ALIGNMENT	
4	STA 0+080 TO STA 0+210
5	STA 0+210 TO STA 0+310
6	STA 0+310 TO STA 0+420
7	STA 0+420 TO STA 0+530
8	STA 0+500 TO STA 0+650

**CLARENCE AVENUE - MARSHALL BAY (W LEG) TO HUDSON ST CONCRETE RECONSTRUCTION**

HORIZONTAL AND VERTICAL ALIGNMENT	
9	STA 0+080 TO STA 0+215
10	STA 0+215 TO STA 0+340
11	STA 0+340 TO STA 0+480
12	STA 0+480 TO STA 0+620

**SWAN LAKE BAY - CHANCELLOR DR TO CHANCELLOR DR ASPHALT RECONSTRUCTION**

HORIZONTAL AND VERTICAL ALIGNMENT	
13	STA 0+000 TO STA 0+100
14	STA 0+100 TO STA 0+235
15	STA 0+235 TO STA 0+360
16	STA 0+360 TO STA 0+490
17	STA 0+490 TO STA 0+595

**STREET LIGHTING PROJECT**

1-04707-DD-50000-0255	SWAN LAKE BAY - CHANCELLOR DR TO CHANCELLOR DR (CONTRACTOR TO REPLACE EXISTING UNDERGROUND STREET LIGHTING PLANT)
-----------------------	--

DRAWING NUMBER	DESCRIPTION
----------------	-------------

**GREYFRIARS ROAD - KILLARNEY AV TO DALHOUSIE DR REHABILITATION**


HORIZONTAL AND VERTICAL ALIGNMENT	
18	STA 0+080 TO STA 0+210
19	STA 0+210 TO STA 0+340
20	STA 0+340 TO STA 0+460
21	STA 0+460 TO STA 0+550
22	STA 0+550 TO STA 0+680

**RIVER ROAD - MINNETONKA ST TO NICOLLET AV REHABILITATION**

HORIZONTAL AND VERTICAL ALIGNMENT	
23	STA 0+080 TO STA 0+190
24	STA 0+190 TO STA 0+300
25	STA 0+300 TO STA 0+420

**HAWKINS CRESCENT - DAKOTA ST TO NOVAVISTA DR REHABILITATION**

HORIZONTAL AND VERTICAL ALIGNMENT	
26	STA 0+080 TO STA 0+200
27	STA 0+200 TO STA 0+320
28	STA 0+320 TO STA 0+440
29	STA 0+440 TO STA 0+570
30	STA 0+570 TO STA 0+690
31	STA 0+690 TO STA 0+810

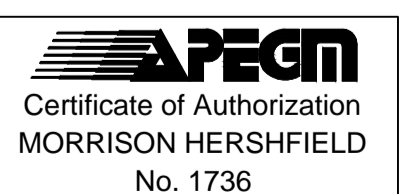

COVER SHEET AND LOCATION PLAN

CITY DRAWING No. N/A REV B

CONSULTANT NO. W150003 - Cover Sheet.dwg