




THE CITY OF WINNIPEG WATER AND WASTE DEPARTMENT

SHOAL LAKE INTAKE FUEL STORAGE & DELIVERY SYSTEM REHABILITATION BID OPPORTUNITY NO. 231-2015

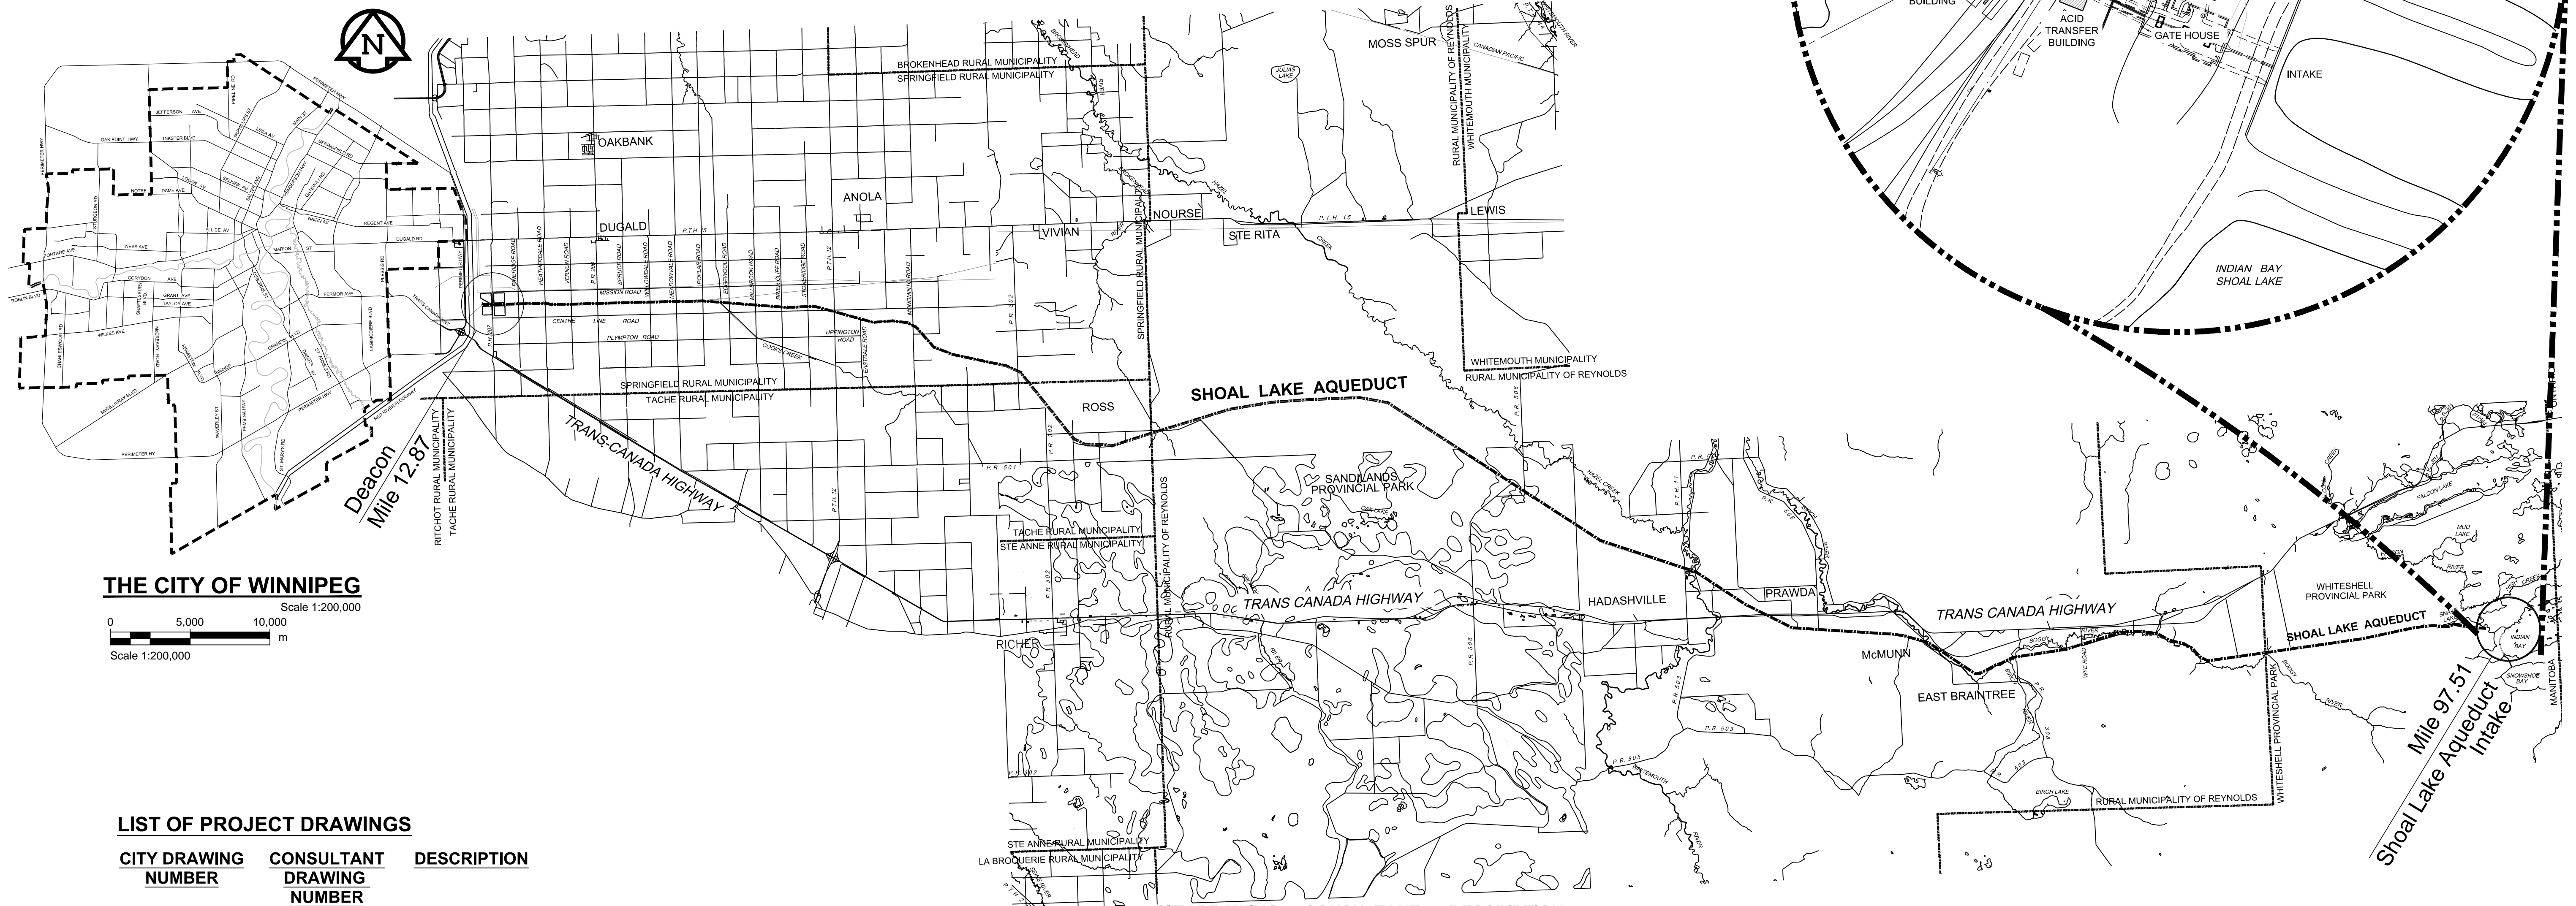

THE CITY OF WINNIPEG
Scale 1:200,000
0 5,000 10,000
m
Scale 1:200,000

LIST OF PROJECT DRAWINGS

CITY DRAWING NUMBER	CONSULTANT DRAWING NUMBER	DESCRIPTION
1-0600A-D0001-001	D0001	COVER SHEET
1-0600A-C0001-001	C0001	SITE PLAN DEMOLITION & NEW FUEL STORAGE LAYOUT
1-0600A-S0001-001	S0001	GENERAL NOTES & ABBREVIATIONS
1-0600A-S0002-001	S0002	DIESEL & GASOLINE FUEL TANK SLAB & SECTIONS
1-0600A-S0003-001	S0003	TANK SLAB DETAILS
1-0600A-M0001-001	M0001	LEGENDS, ABBREVIATIONS, DESIGN NOTES & SCHEDULES
1-0600A-P0005-001	P0005-001	PROCESS & INSTRUMENTATION DIAGRAM LEGEND & DETAILS
1-0600A-P0005-002	P0005-002	PROCESS & INSTRUMENTATION DIAGRAM LEGEND & DETAILS
1-0600A-P0006-001	P0006	DIESEL & GASOLINE FUEL DISPENSING PROCESS & INSTRUMENTATION DIAGRAM
1-0600A-P0007-001	P0007	PUMPHOUSE DIESEL FUEL SYSTEM PROCESS & INSTRUMENTATION DIAGRAM
1-0600A-M0002-001	M0002	DIESEL & GASOLINE FUEL TANK LAYOUT
1-0600A-M0003-001	M0003	PUMPHOUSE & GATEHOUSE DEMOLITION PLANS
1-0600A-M0004-001	M0004	PUMPHOUSE & GATEHOUSE DIESEL FUEL SYSTEM PLANS

CITY DRAWING NUMBER	CONSULTANT DRAWING NUMBER	DESCRIPTION
1-0600A-M0005-001	M0005	INTERIOR BUILDING ELEVATIONS
1-0600A-M0006-001	M0006	DIESEL FUEL SYSTEM SECTION & DETAILS
1-0600A-M0007-001	M0007	DIESEL & GASOLINE FUEL SYSTEMS DETAILS
1-0600A-M0008-001	M0008	DIESEL & GASOLINE FUEL SYSTEMS PROFILE & SECTION
1-0600A-M0009-001	M0009	PIPE WALKOVER PLAN, SECTION, ELEVATION AND DETAILS
1-0600A-E0001-001	E0001	SITE PLAN
1-0600A-E0002-001	E0002	SCHEDULE & DETAILS
1-0600A-E0003-001	E0003	SINGLE LINE DIAGRAM
1-0600A-E0004-001	E0004	CLASSIFICATION
1-0600A-E0005-001	E0005	PUMPHOUSE PLAN
1-0600A-A0001-001	A0001	TYPICAL INSTRUMENT LOOP DIAGRAM



ISSUED FOR TENDER, BID OPP. 231-2015
ISSUE DATE: APRIL 13, 2015